



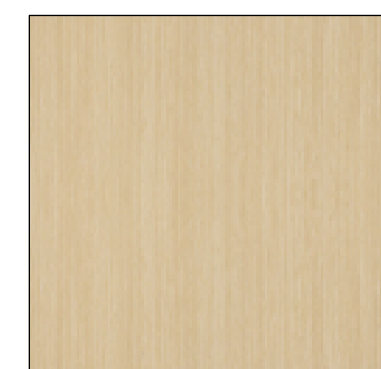

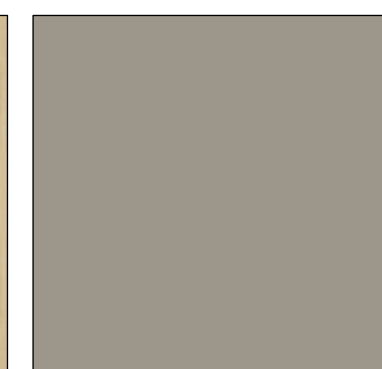


1 COMP PLAN VIEW
 SCALE: 3/32"=1'

CASEWORK FINISHES: TBA

			
HM Laminate LBA clear on ash CP	HM Paint/Plastic NH brushed nickel	CQ glacier white	91 FF91

 LAB & RX FINISHES: TBA

		
HM Paint/Plastic AN clear anodized aluminum	1S savannah	LU soft white

Contractors/ Subcontractors to check and verify all dimensions on site prior to proceeding with the work.

This document and any associated materials are the sole property of Workscapes and are not for use other than to internally evaluate Workscapes' services. They are not to be disseminated, distributed, or otherwise conveyed to any third parties without the express written permission of Workscapes.

Project No.: 89853
Sheet Size: 24X36
Scale: SEE PLAN
Designer: K.COTTRELL
Location: TAMPA, FL
Date: 3/2/2026
Signed:

Revisions:
02-17-2026_R1.ADD.FILLER
03-02-2026_R2.ADJ.SCOPE
date.....
date.....
date.....
date.....
date.....
date.....

This drawing is intended to indicate furniture location and configuration only and is not to be used permitting or construction.

For exact architectural configurations, refer to architectural contract documents prepared by others.

Sheet:



Workscapes
Tampa

501 E Kennedy Blvd
Suite 100
Tampa, FL 33602
813.620.0048
IC # 806001003

Facility Name: Orlando Health Melbourne Hospital

Project Name: Freestanding ER - Viera

OPC Project #: 23/23960034-19987

Meibourne Viera FSED
EXAM CASEWORK AND LAB



Lake Andrew Dr & Willet Place, Melbourne, FL 32940

Contractors/ Subcontractors to check and verify all dimensions on site prior to proceeding with the work.

This document and any associated materials are the sole property of Workscapes and are not for use other than to internally evaluate Workscapes' services. They are not to be disseminated, distributed, or otherwise conveyed to any third parties without the express written permission of Workscapes.

Project No.: 89853

Sheet Size: 24X36

Scale: SEE PLAN

Designer: K.COTTRELL

Location: TAMPA, FL

Date: 3/2/2026

Signed:


Revisions:

02-17-2026_R1.ADD.FILLER
03-02-2026_R2.ADJ.SCOPE
date.....
date.....
date.....
date.....
date.....
date.....

This drawing is intended to indicate furniture location and configuration only and is not to be used permitting or construction.

For exact architectural configurations, refer to architectural contract documents prepared by others.

Sheet:

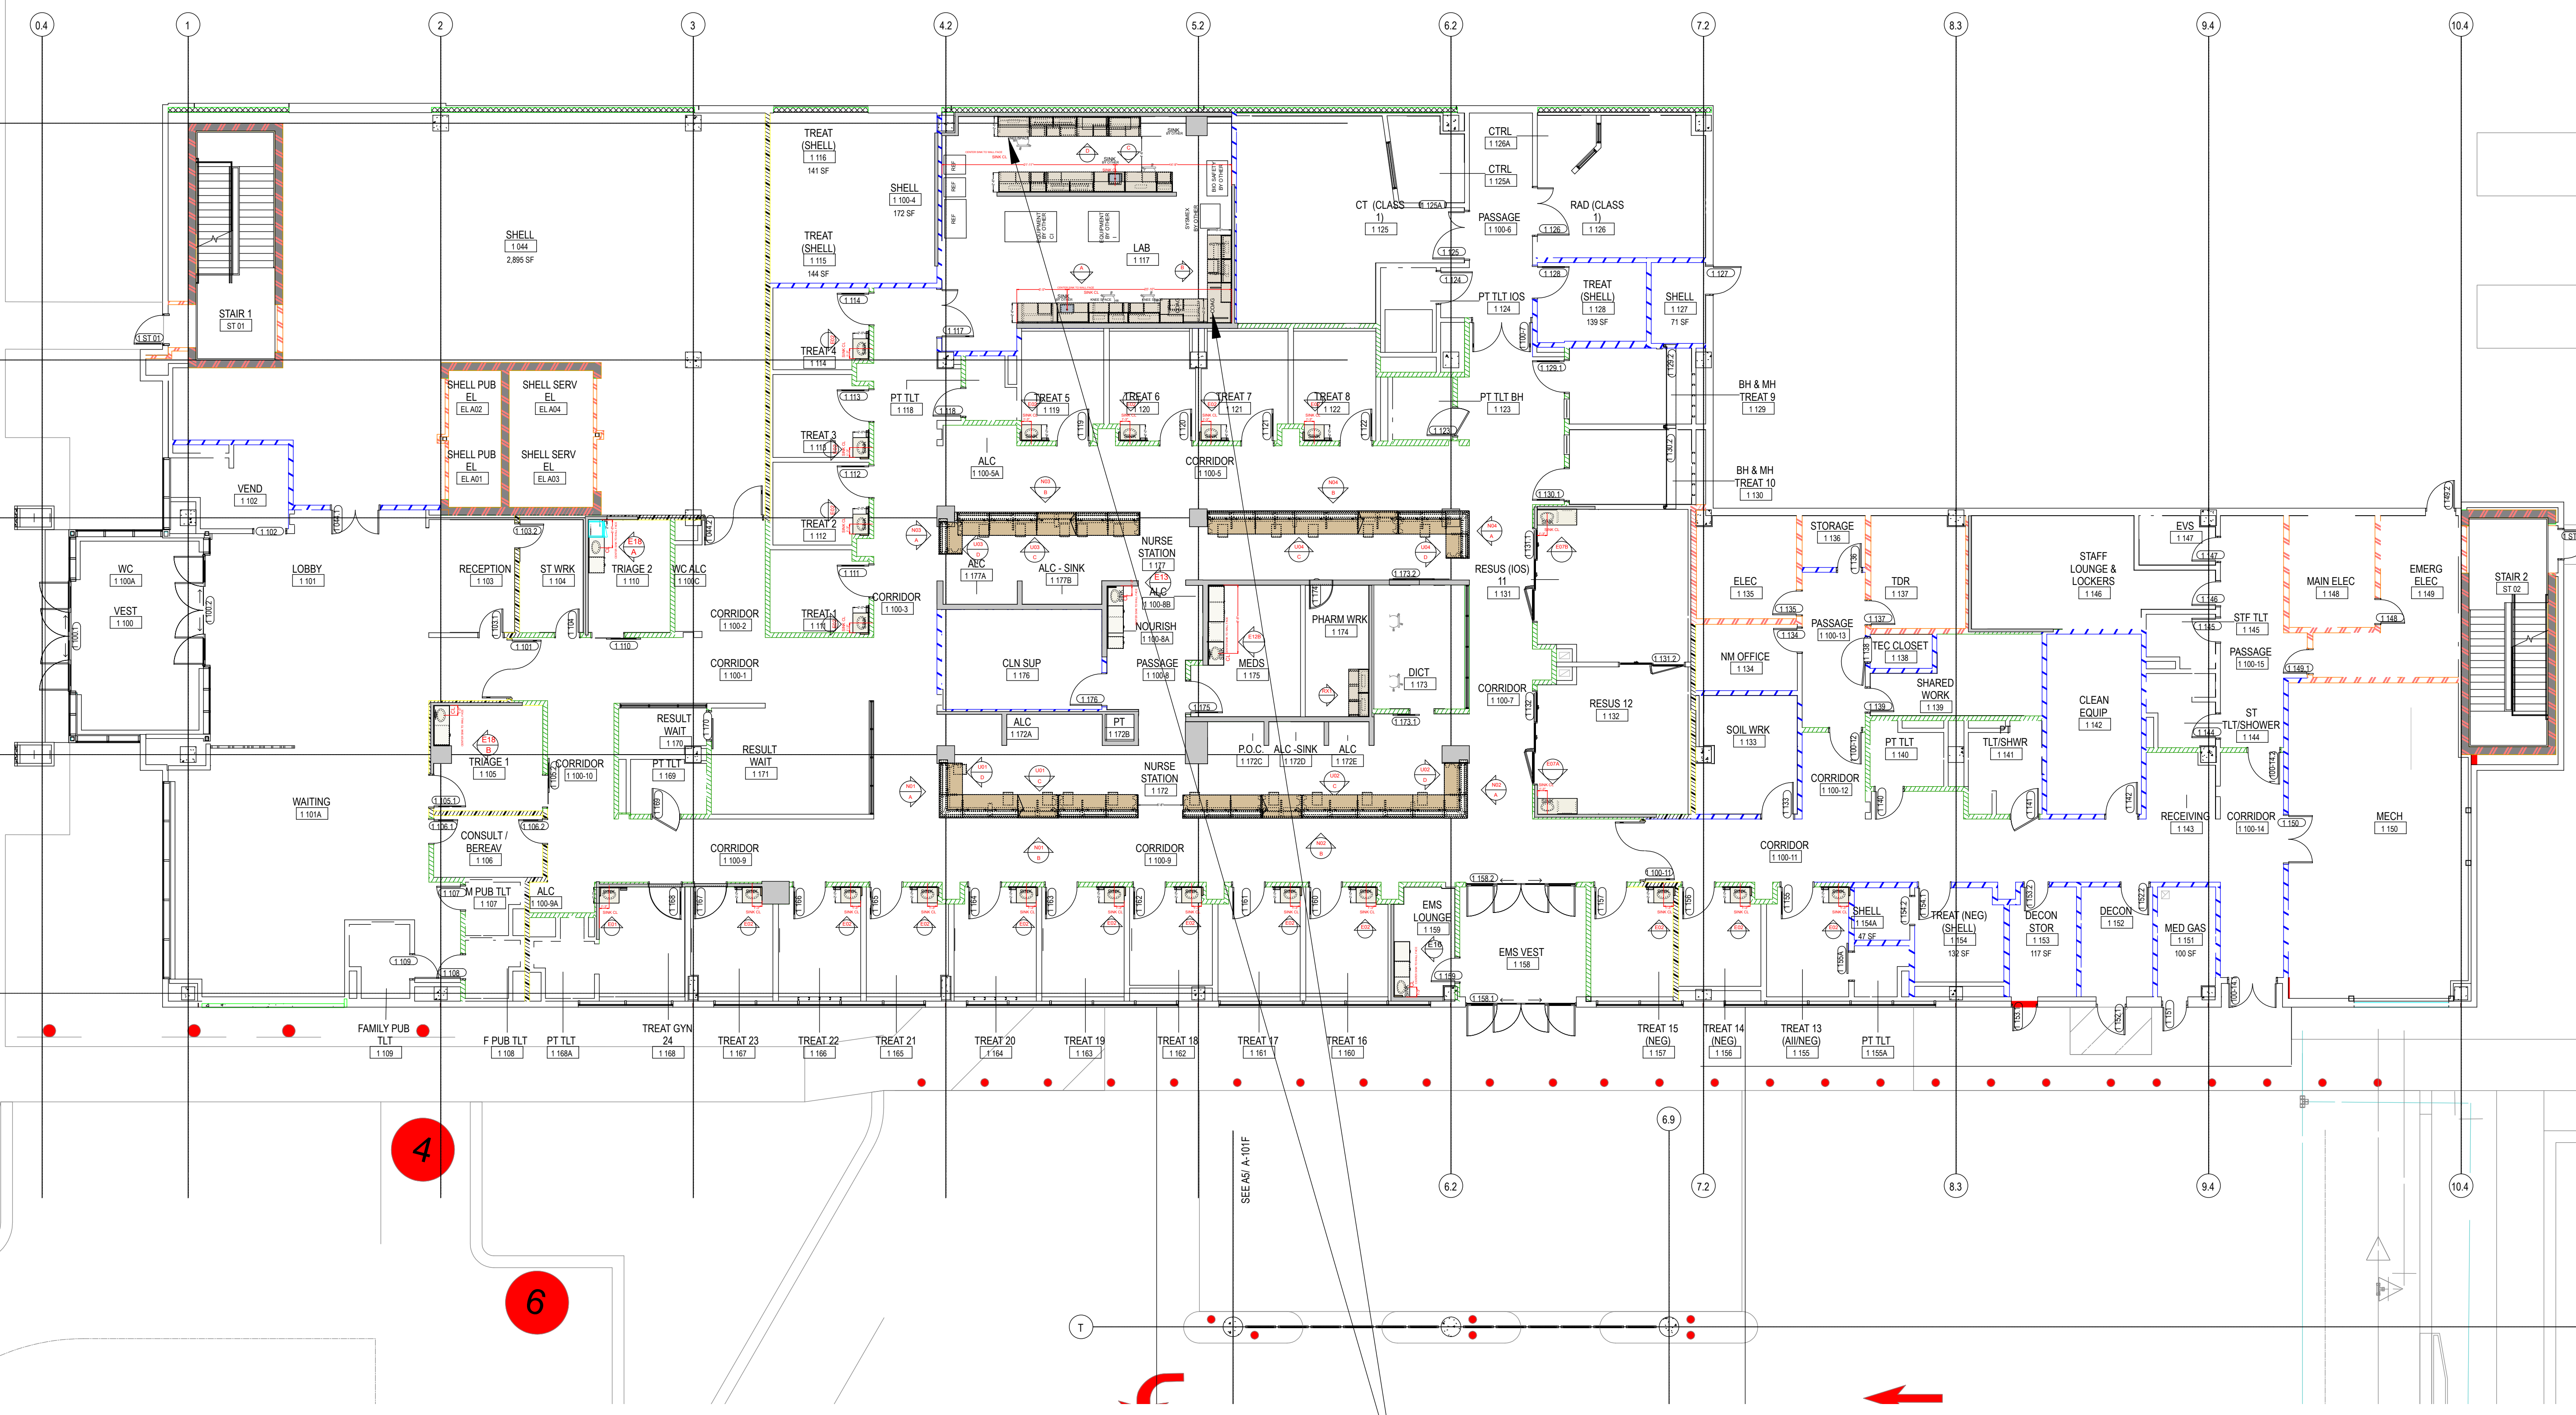


1 UTILITY PLAN VIEW
SCALE: 3/16"=1'

WORKSCAPES NOT RESPONSIBLE FOR CUP SINKS.



MORA CASEWORK DETAILS

Note To Plumber:
When determining the faucet location, Refer to the size of the sink body and fastener below

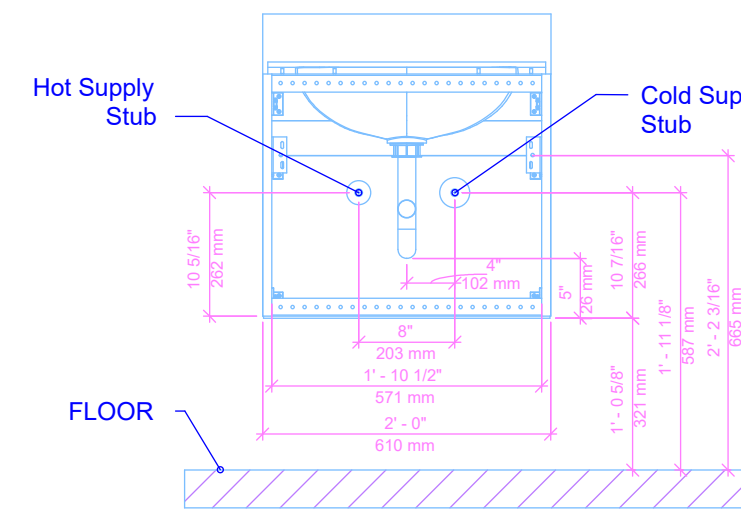

24\"/>

CH607.2430 ADA

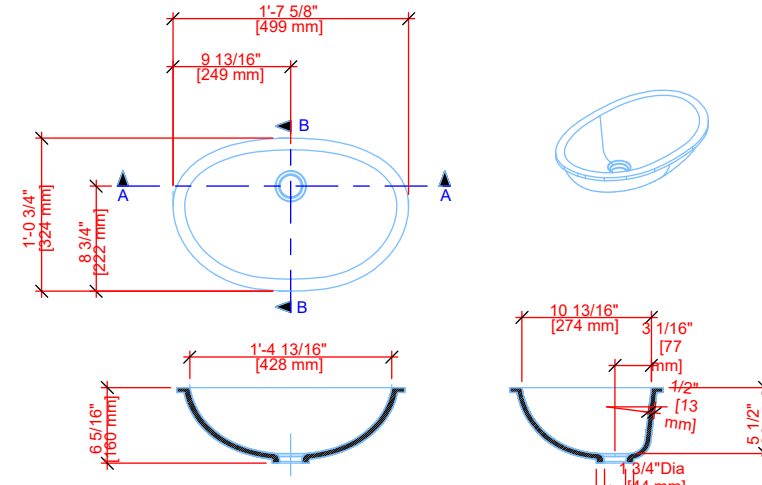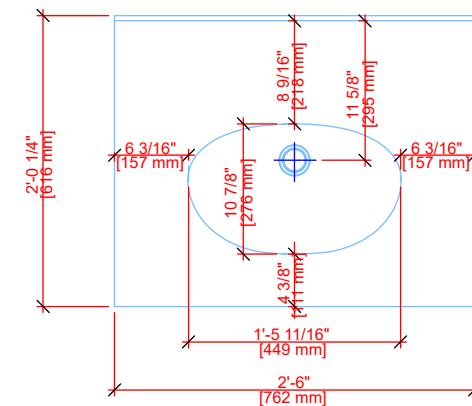


Section A-A Section B-B

SINK ADA DIMENSION (CH607)
3/4\"/>


If integral sink is part of casework supplied, plumbing contractor needs to supply plumbing fixtures – i.e. faucet, strainer, tailpiece, etc. and is responsible for all piping and final connections from sink drain to wall and/or plumbing entry point

SINK DIMENSION FAUCET SPACE
3/4\"/>

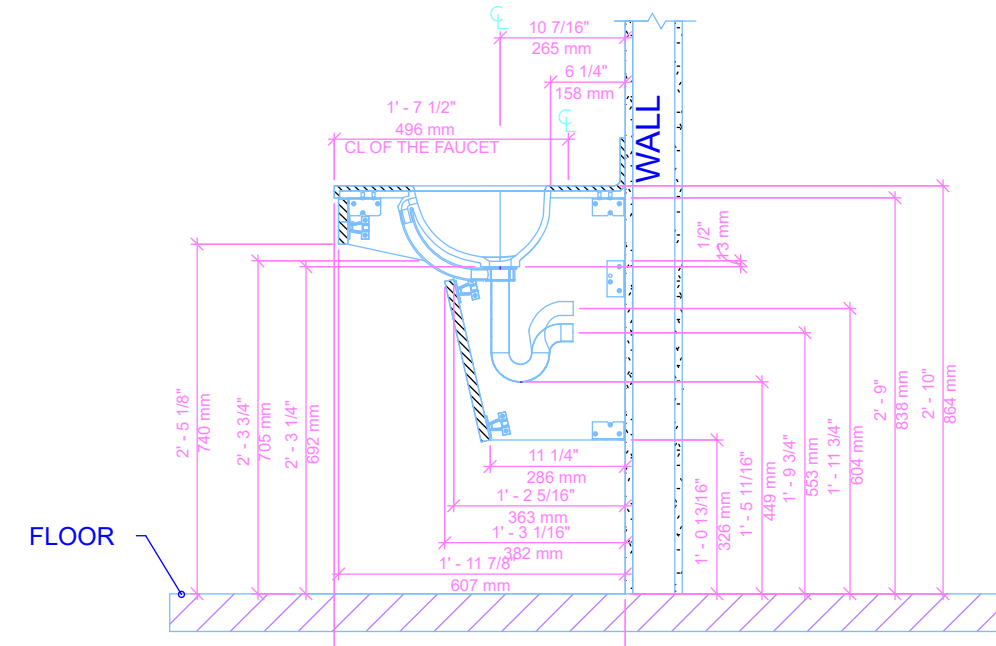


24\"/>

TOP IN SS SINK

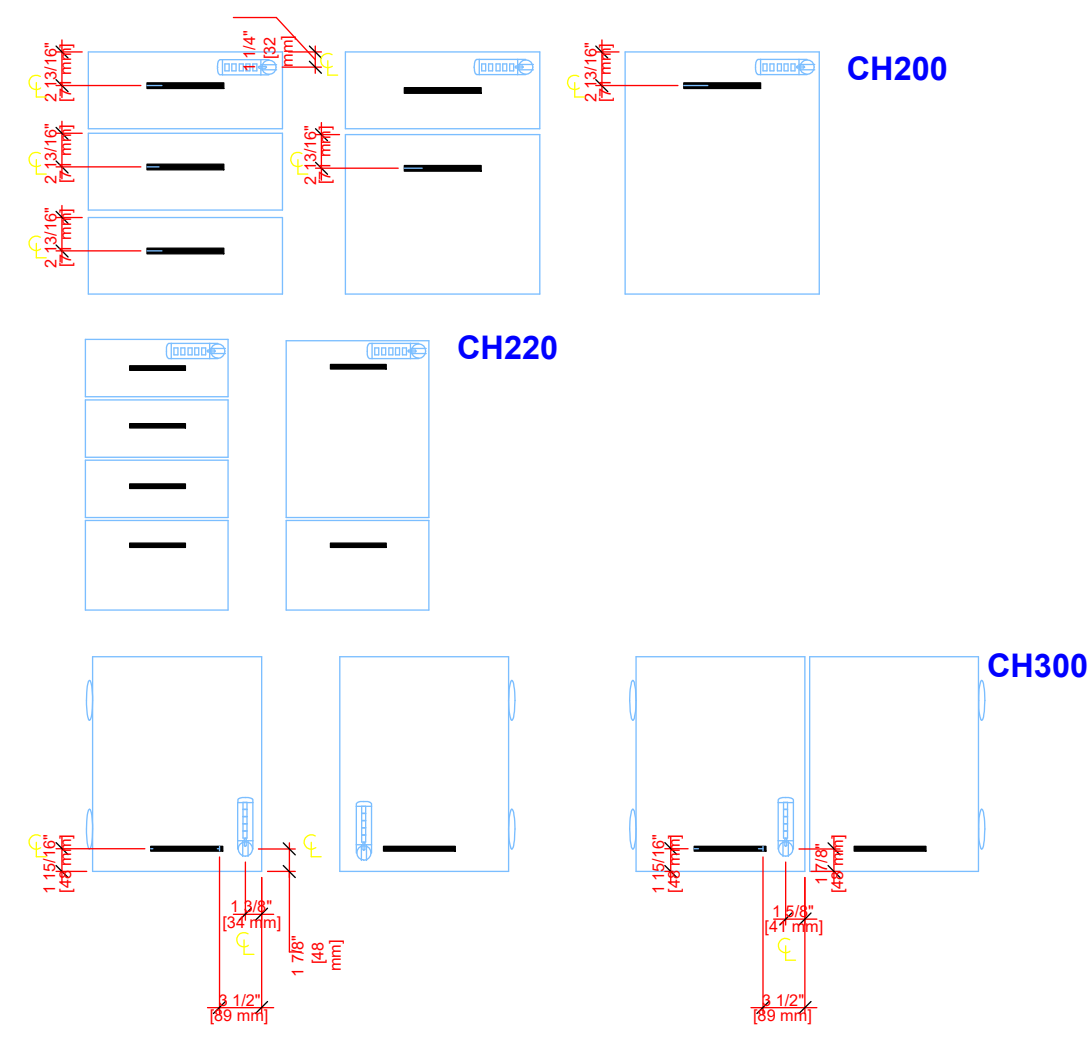

PULLLOCK LOCATIONS AND ORIENTATIONS
3/4\"/>

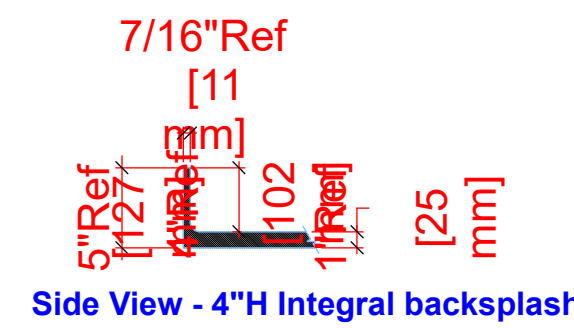


Side View - 4\"/>


INTEGRAL BACKSPLASH DETAIL
1\"/>




EXAMPLE OF OFF SET P-TRAP PLUMBERS NEED TO PROVIDE.

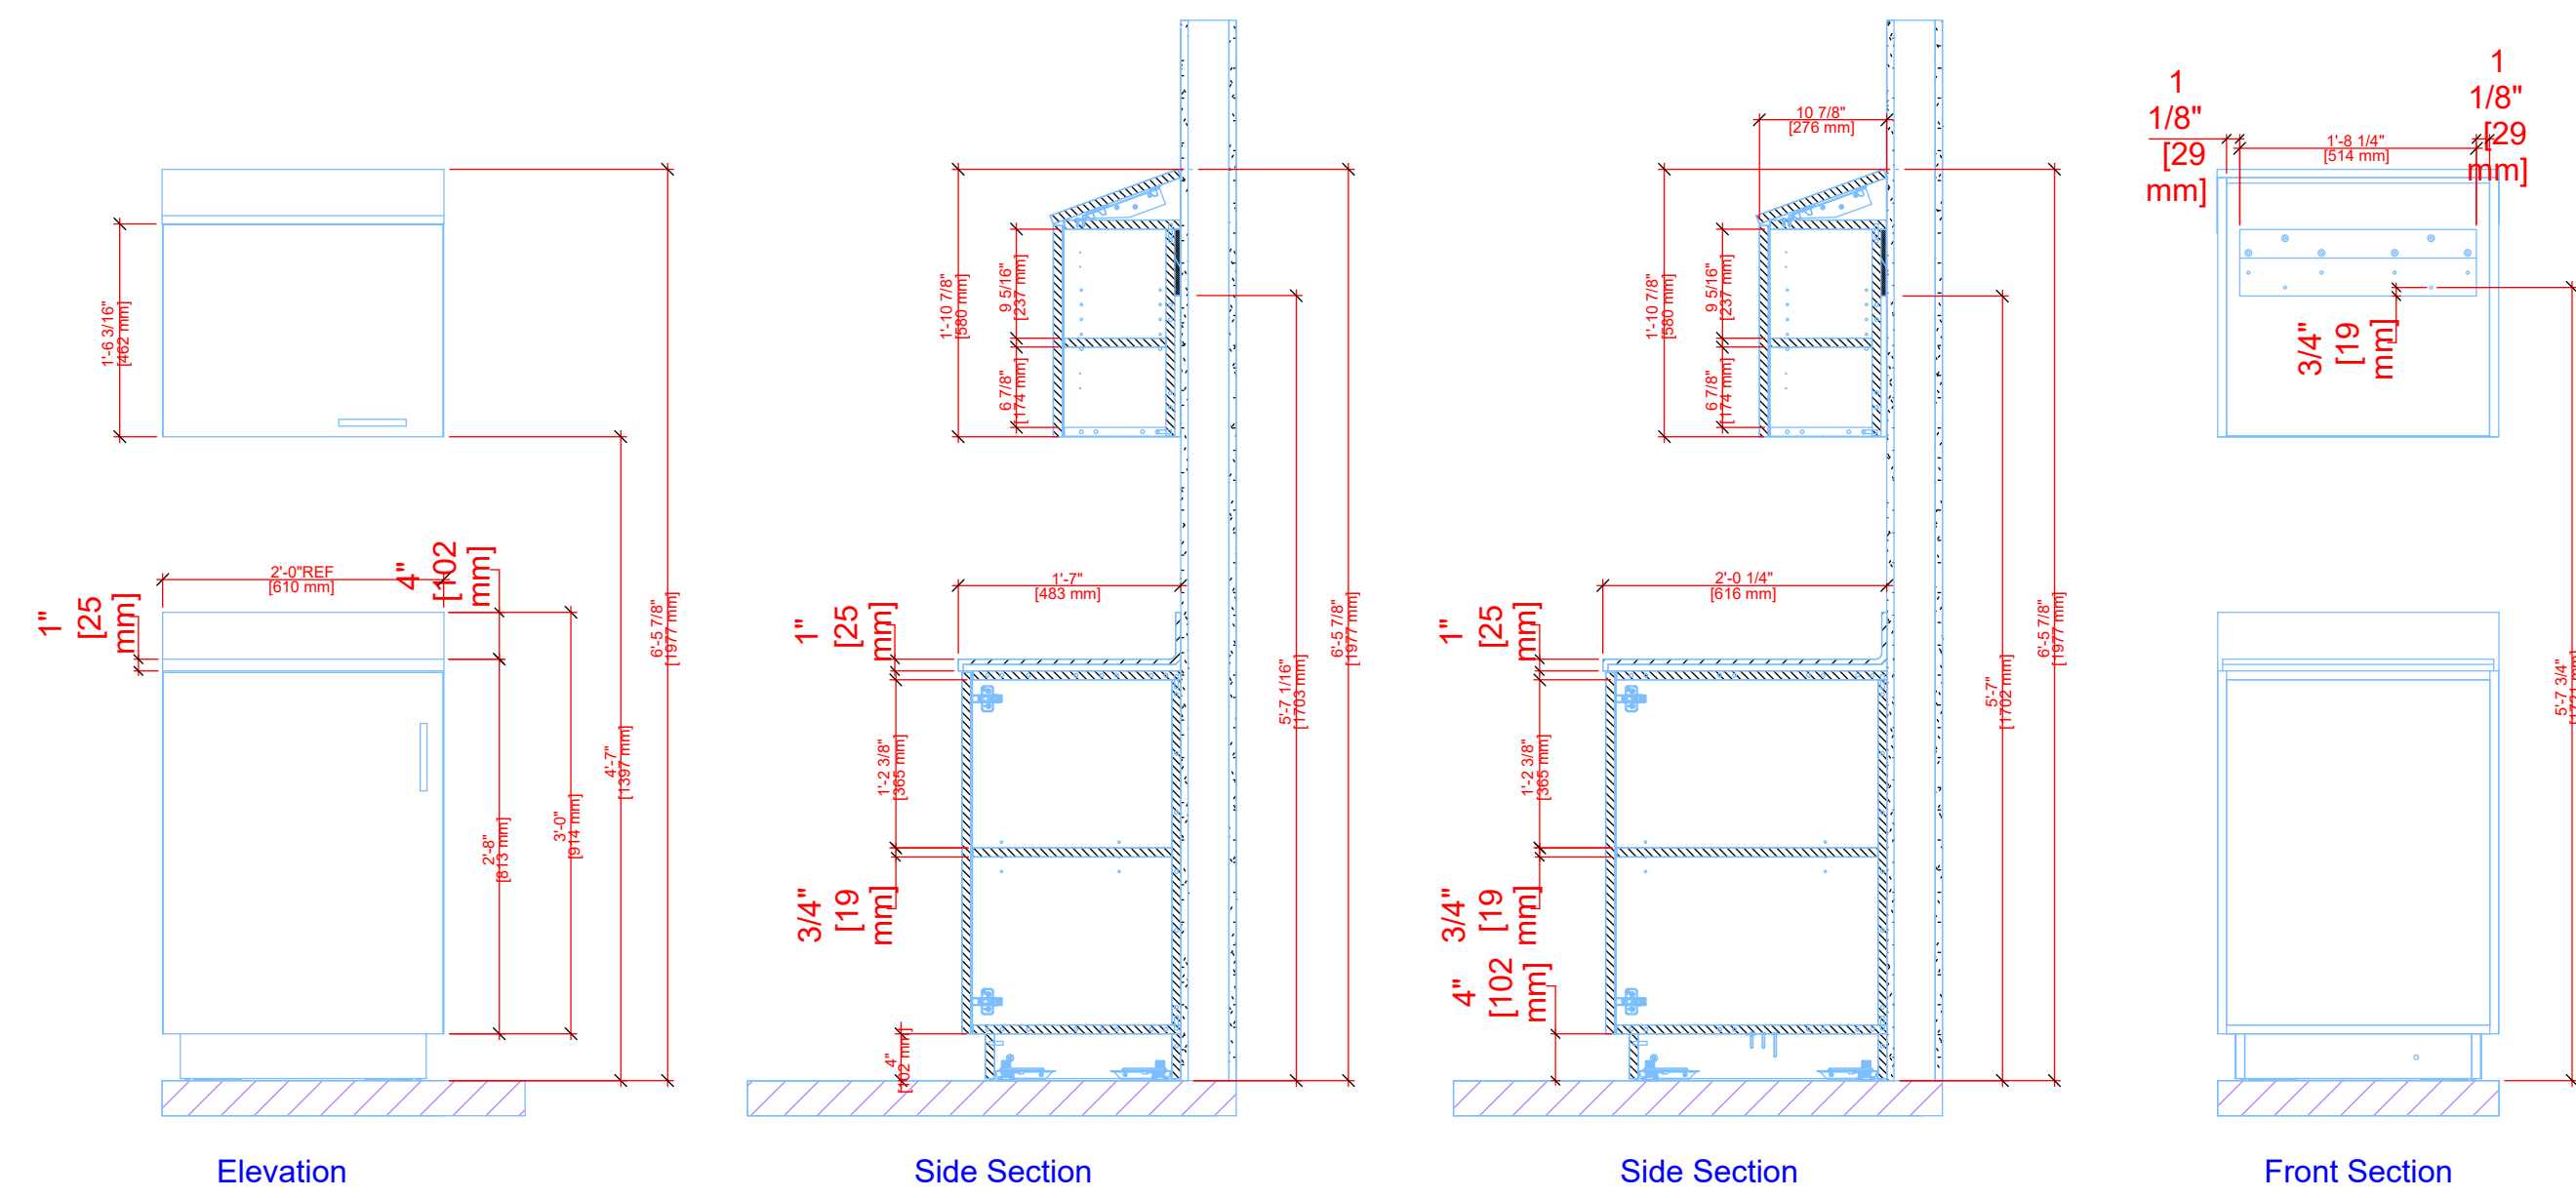

TO THE FLOOR 19\"/>

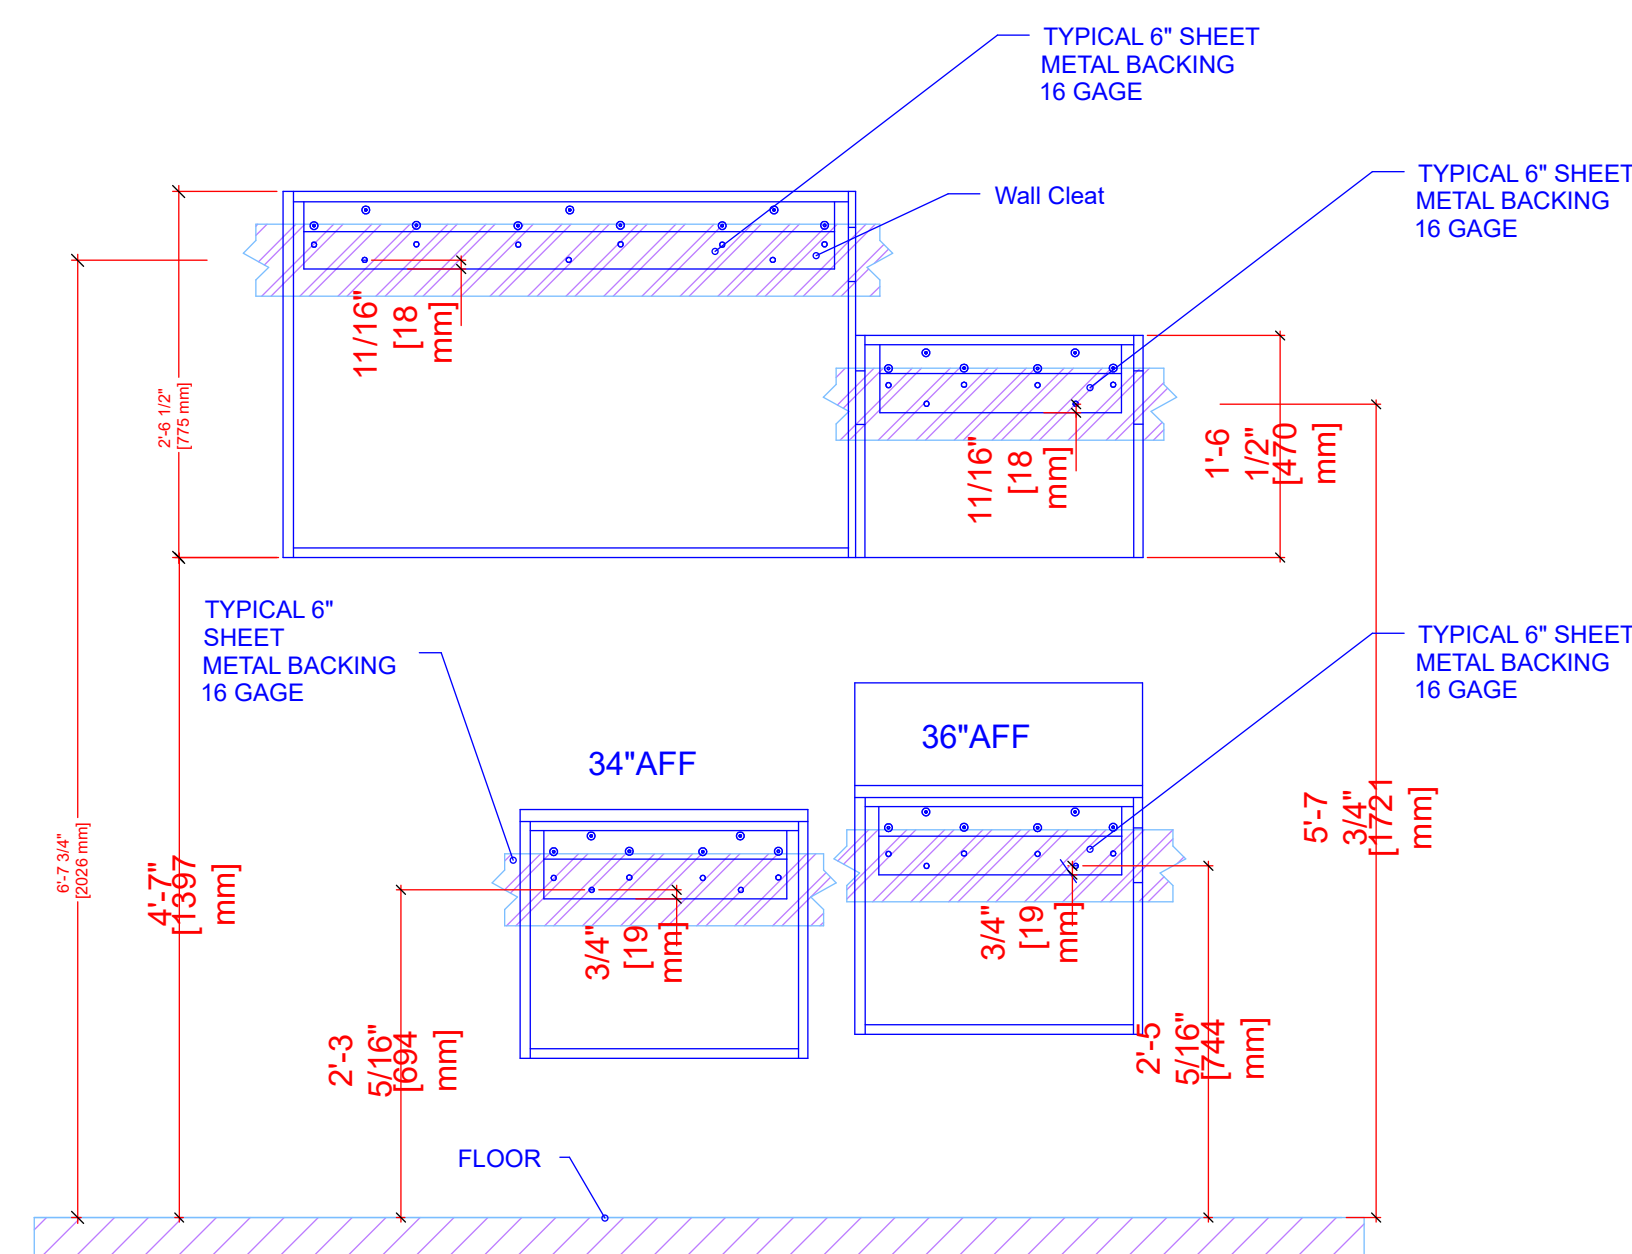

Backing Detail: Wall Mounted Cabinets
3/4\"/>

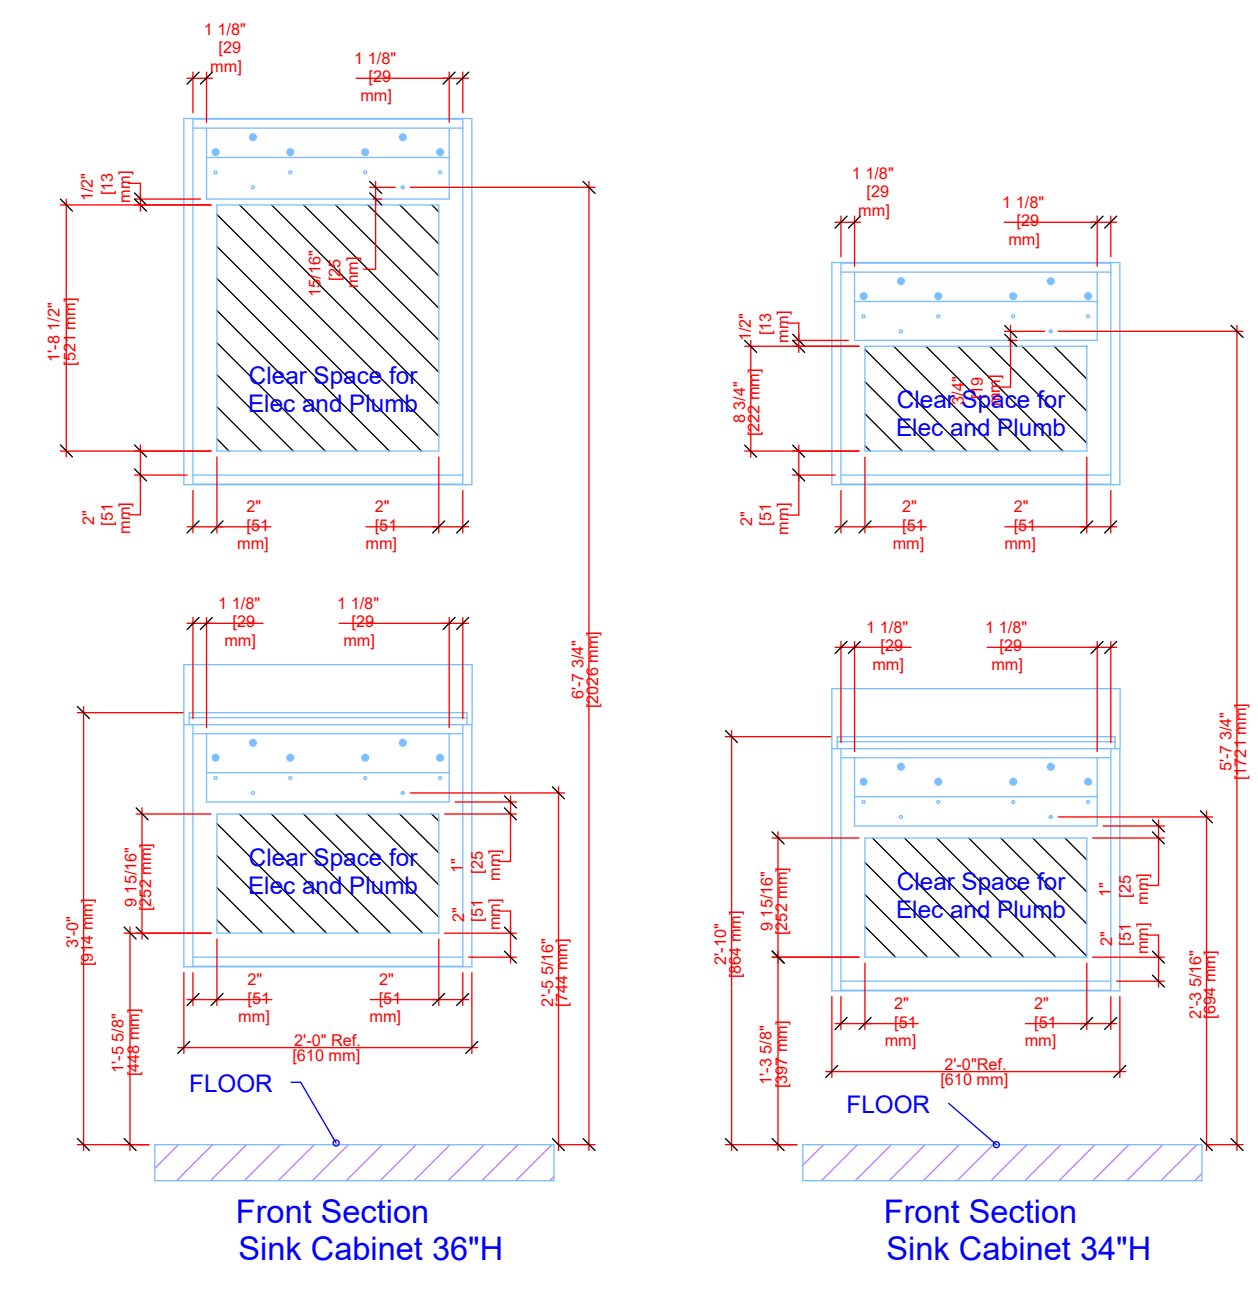

WALL MOUNTED CABINETS CLEAR SPACE
3/4\"/>



workscapes
Tampa
501 E Kennedy Blvd
Suite 100
Tampa, FL 33602
813.620.0048
IC # 806001003

Facility Name: Orlando Health Melbourne Hospital
Project Name: Freestanding ER - Viera
OPC Project #: 23/23960034-19987

Melbourne Viera FSED
EXAM CASEWORK AND LAB
Lake Andrew Dr & Willif Place, Melbourne, FL 32940

Contractors/ Subcontractors to check and verify all dimensions on site prior to proceeding with the work.

This document and any associated materials are the sole property of Workscapes and are not for use other than to internally evaluate Workscapes' services. They are not to be disseminated, distributed, or otherwise conveyed to any third parties without the express written permission of Workscapes.

Project No.: 89853
Sheet Size: 24X36
Scale: SEE PLAN
Designer: K.COTTRELL
Location: TAMPA, FL
Date: 3/2/2026
Signed:

Revisions:
02-17-2026_R1.ADD FILLER
03-02-2026_R2.ADJ SCOPE
date.....
date.....
date.....
date.....
date.....

This drawing is intended to indicate furniture location and configuration only and is not to be used permitting or construction.

For exact architectural configurations, refer to architectural contract documents prepared by others.

Sheet:
3/15

Contractors/ Subcontractors to check and verify all dimensions on site prior to proceeding with the work.

This document and any associated materials are the sole property of Workscapes and are not for use other than to internally evaluate Workscapes' services. They are not to be disseminated, distributed, or otherwise conveyed to any third parties without the express written permission of Workscapes.

Project No.: 89853
Sheet Size: 24X36
Scale: SEE PLAN
Designer: K.COTTRELL
Location: TAMPA, FL
Date: 3/2/2026
Signed:

Revisions:

02-17-2026_R1_ADD FILLER	date.....
03-02-2026_R2_ADJ SCOPE	date.....
	date.....
	date.....
	date.....
	date.....

This drawing is intended to indicate furniture location and configuration only and is not to be used permitting or construction.


For exact architectural configurations, refer to architectural contract documents prepared by others.




1 EXAM TYPICAL SINK LEFT RENDERING
SCALE: NTS




2 EXAM TYPICAL SINK RIGHT EXAM RENDERING
SCALE: NTS

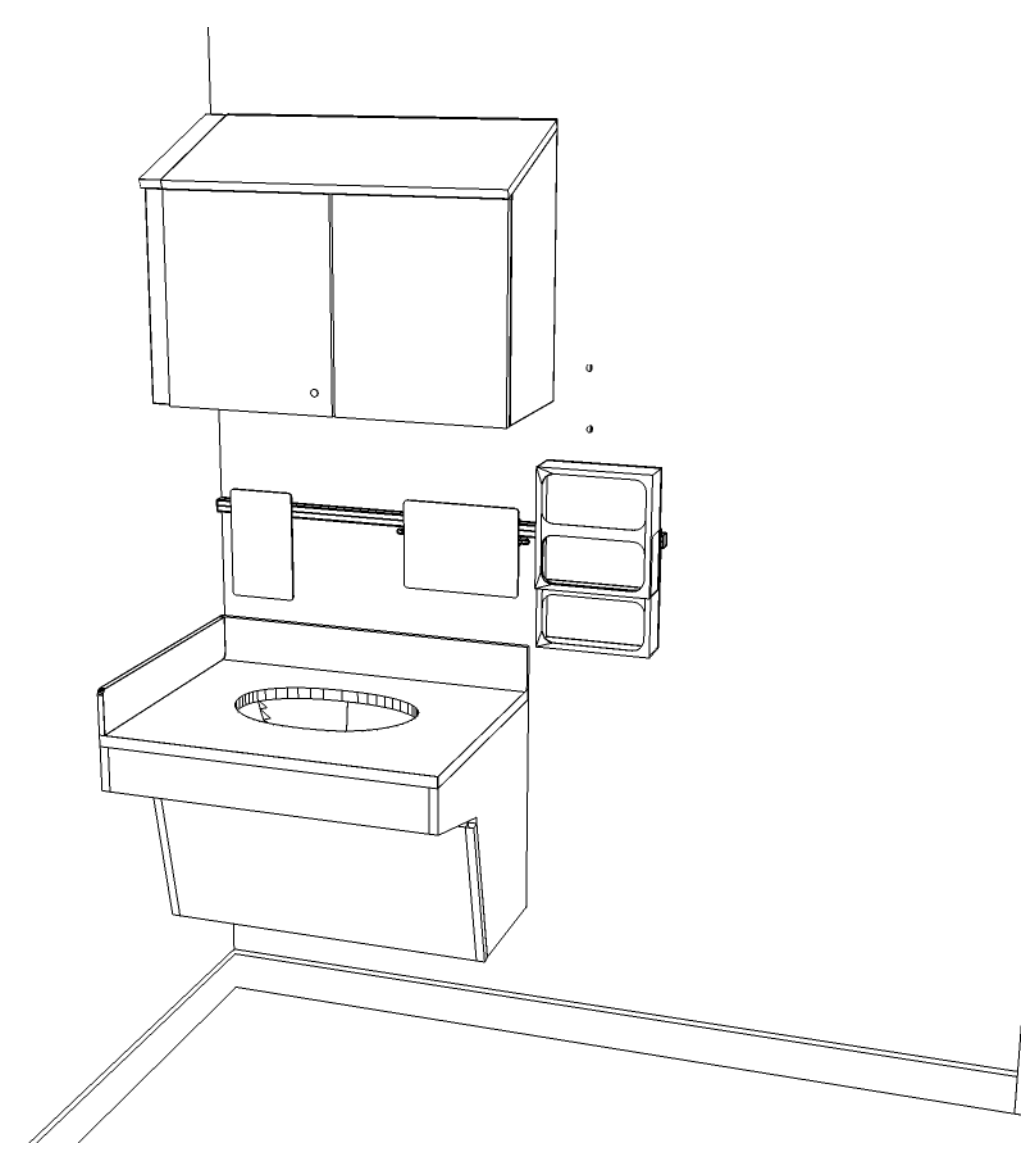


1 EXAM TYPICAL SINK LEFT ISOMETRIC VIEW
SCALE: NTS

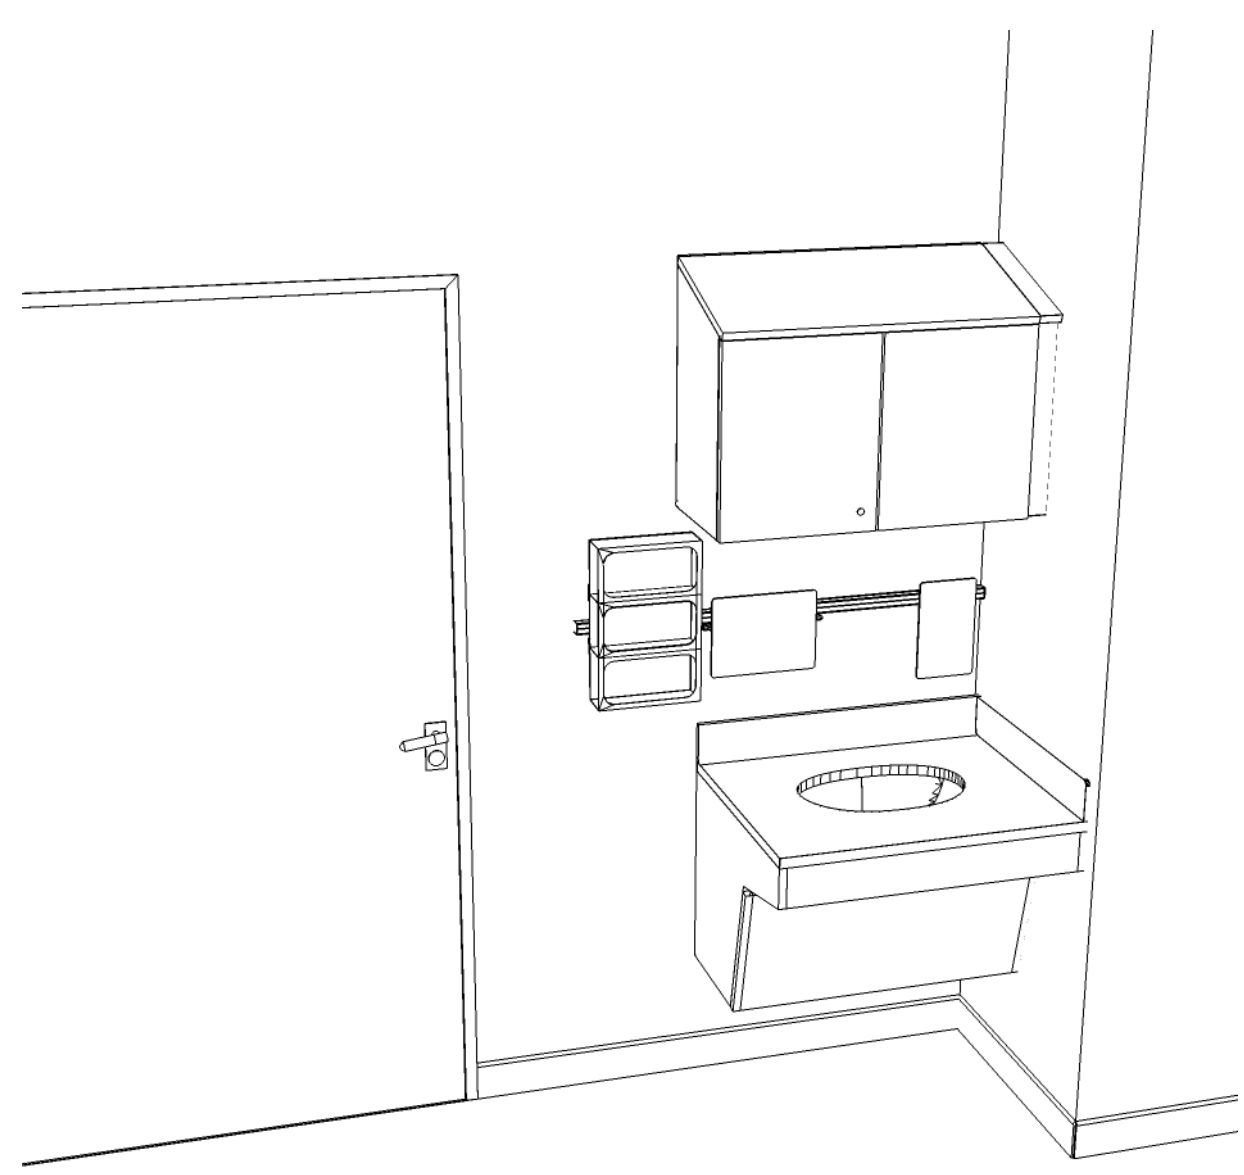


2 EXAM TYPICAL SINK RIGHT ISOMETRIC VIEW
SCALE: NTS

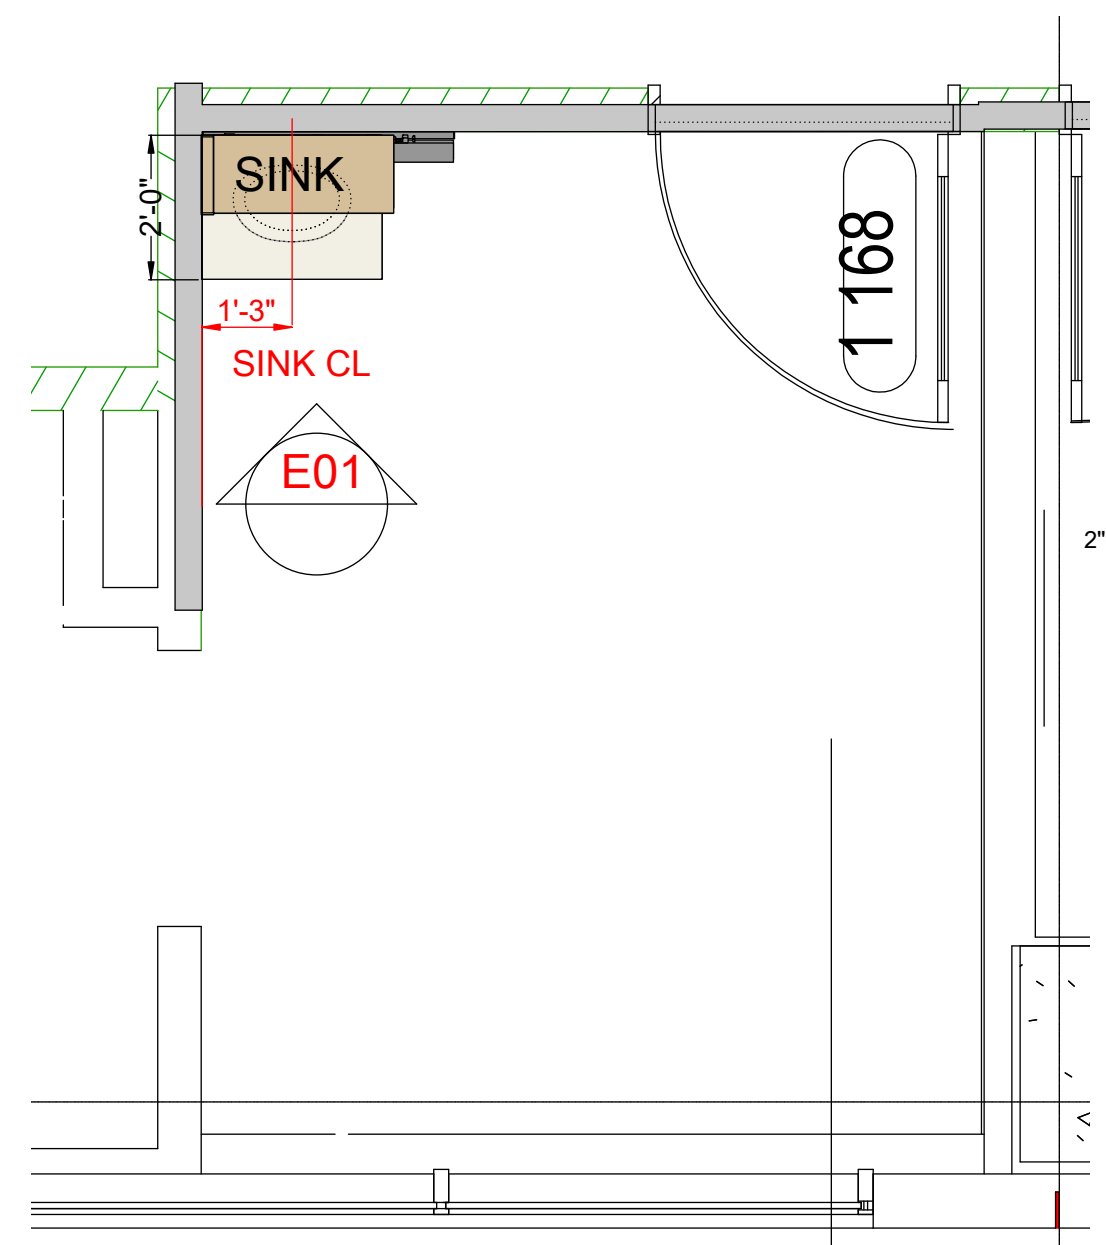


1 EXAM TYPICAL SINK LEFT PLAN VIEW
SCALE: 3/8"=1"
ROOMS INCLUDED: 1168 QTY 1 TOTAL

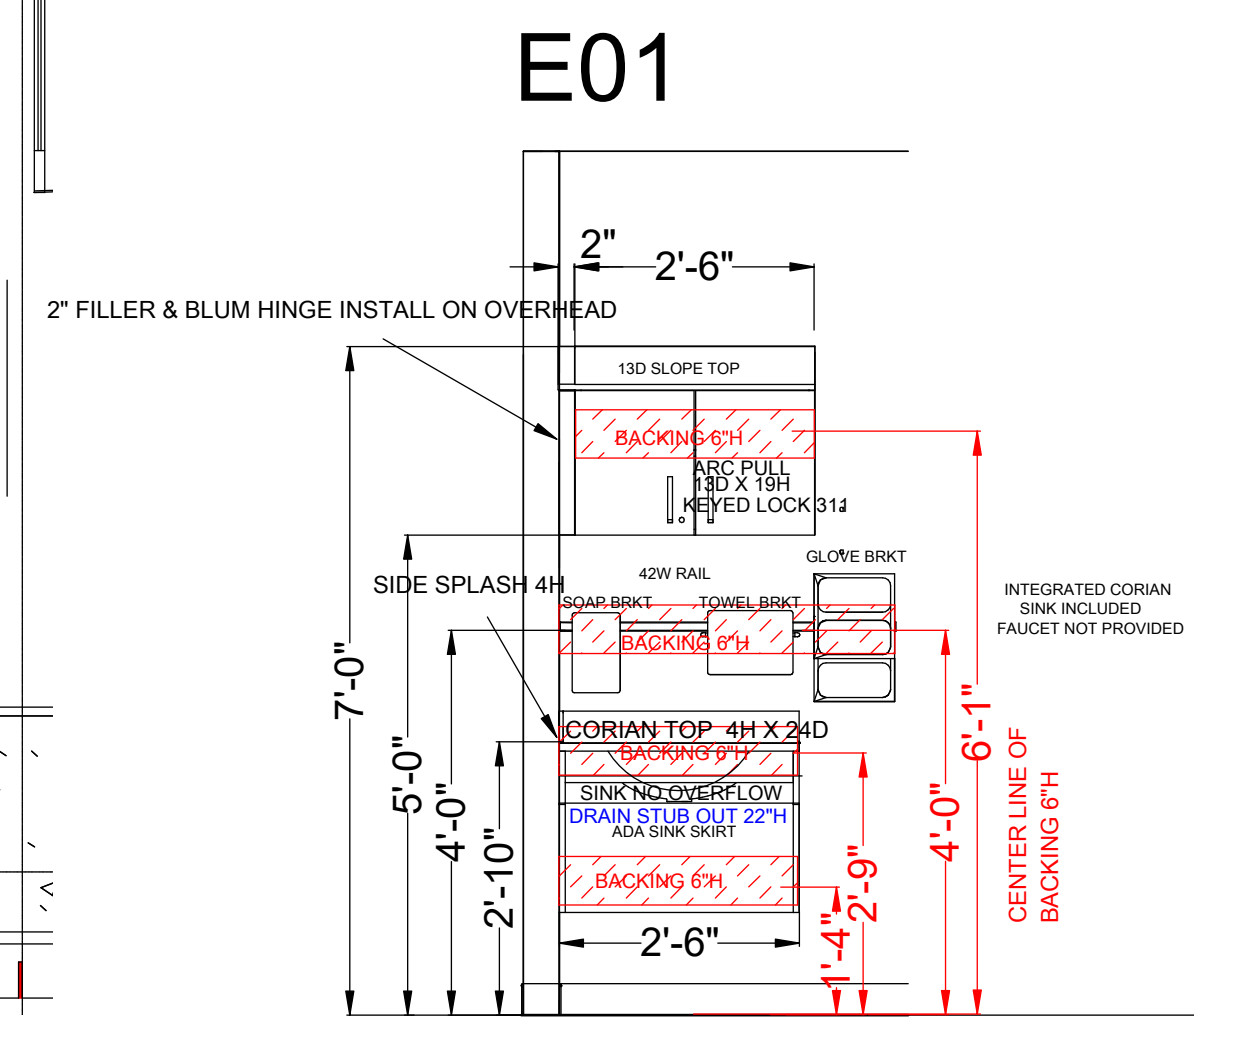


1 EXAM TYPICAL SINK LEFT ELEVATION VIEW
SCALE: 1/2"=1"

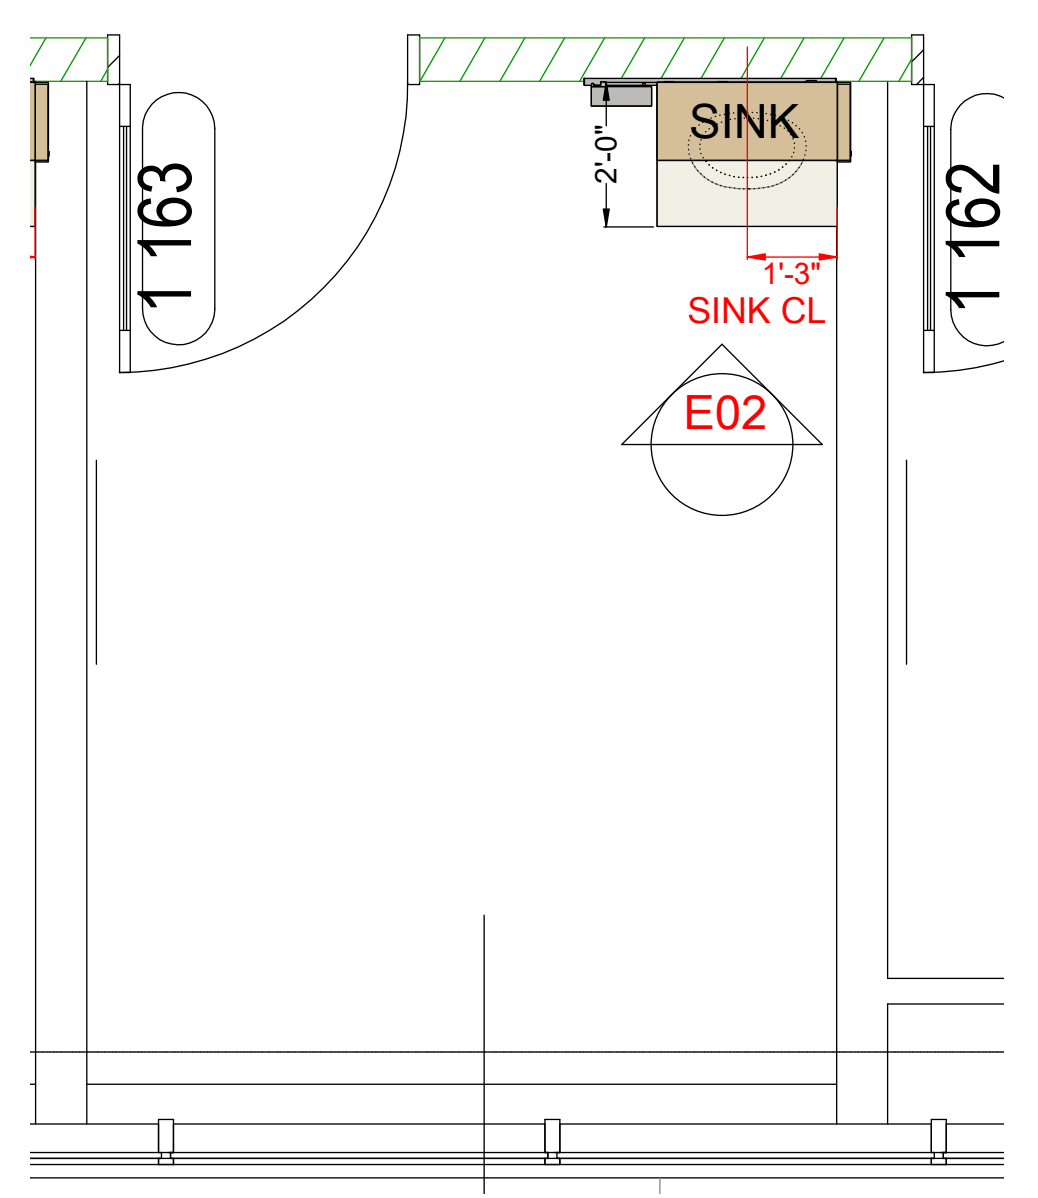

2 EXAM TYPICAL SINK RIGHT PLAN VIEW
SCALE: 3/8"=1"
ROOMS INCLUDED: QTY 19 TOTAL

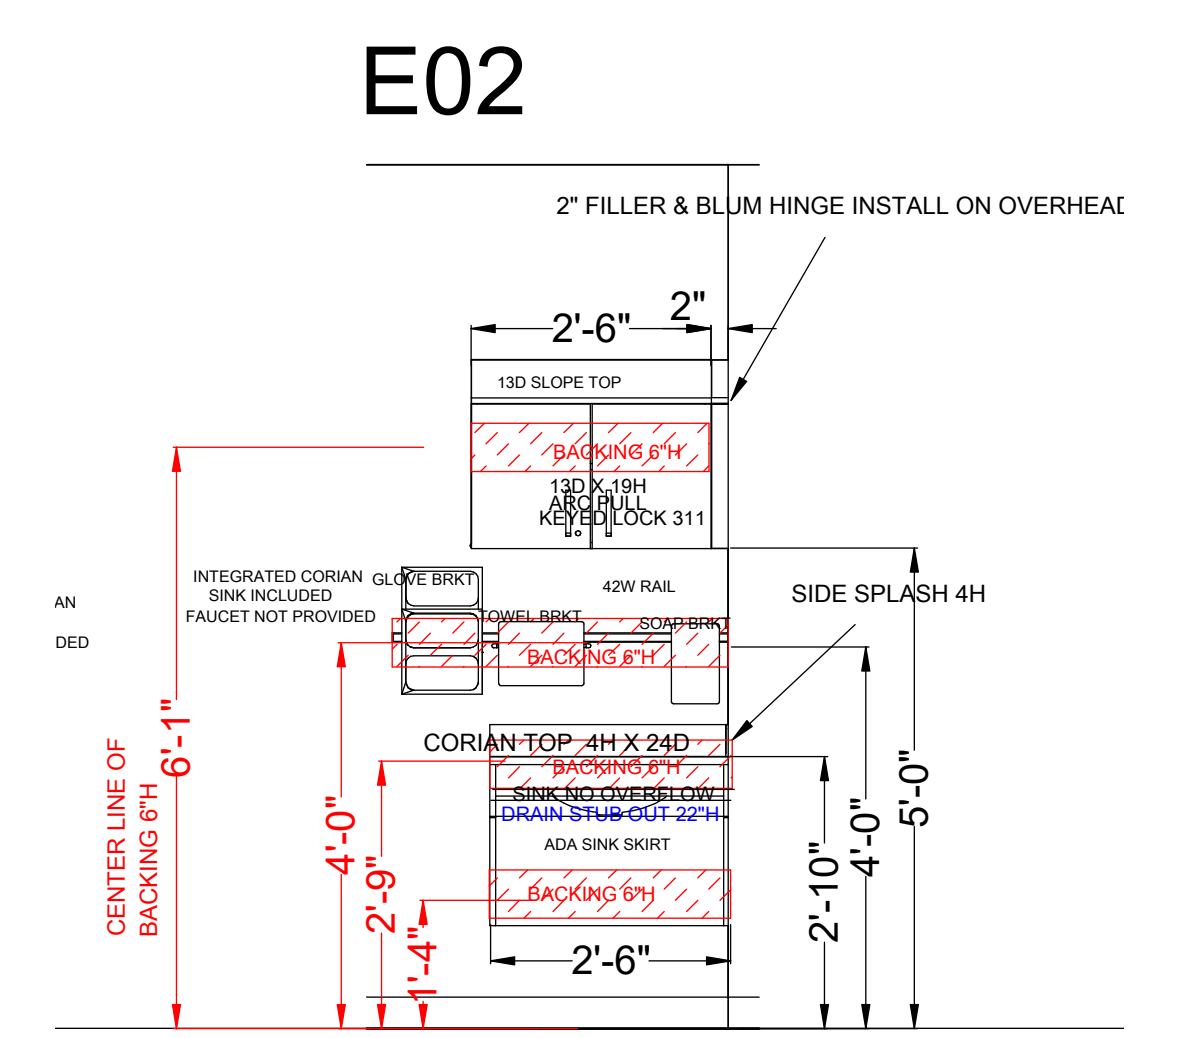

2 EXAM TYPICAL SINK RIGHT ELEVATION VIEW
SCALE: 1/2"=1"

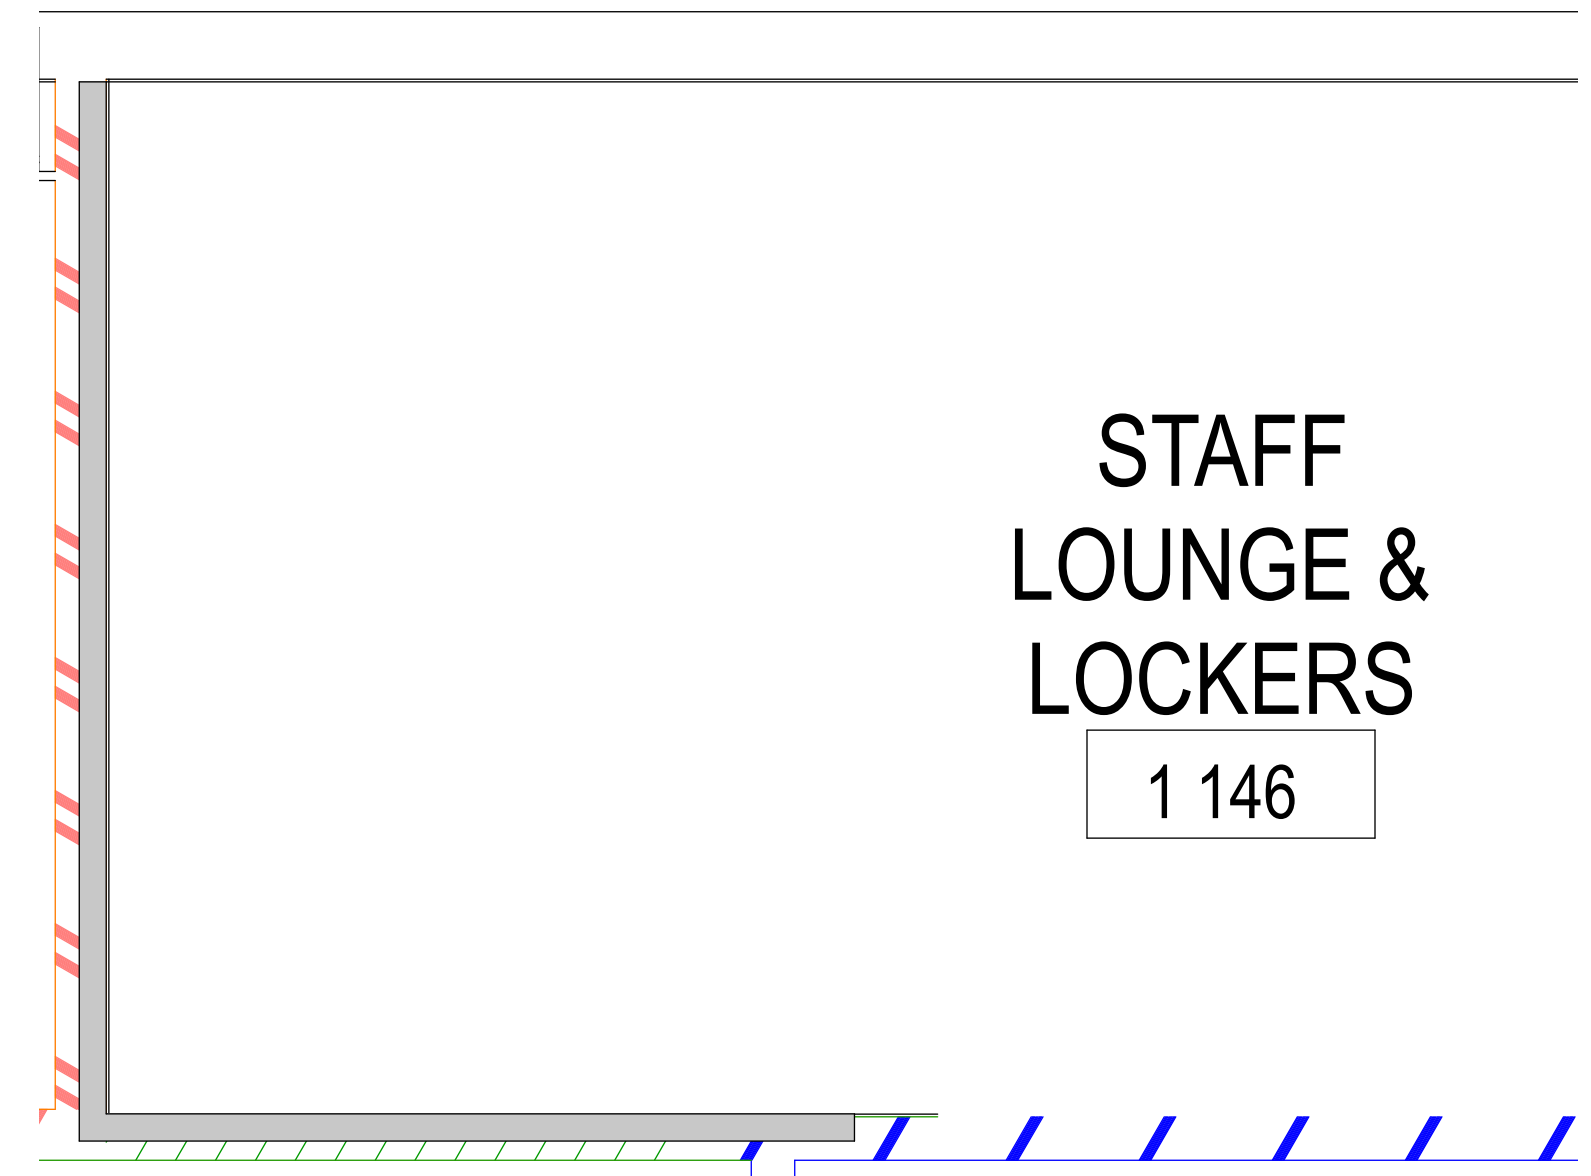


15 STAFF LOUNGE PLAN VIEW RM 1146
SCALE: 3/8"=1"

REMOVED FROM SCOPE


15 STAFF LOUNGE ELEVATION VIEW RM 1146
SCALE: 1/2"=1"

15 STAFF LOUNGE ISOMETRIC VIEW RM 1146
SCALE: NTS


15 STAFF LOUNGE ELEVATION VIEW RM 1146
SCALE: NTS

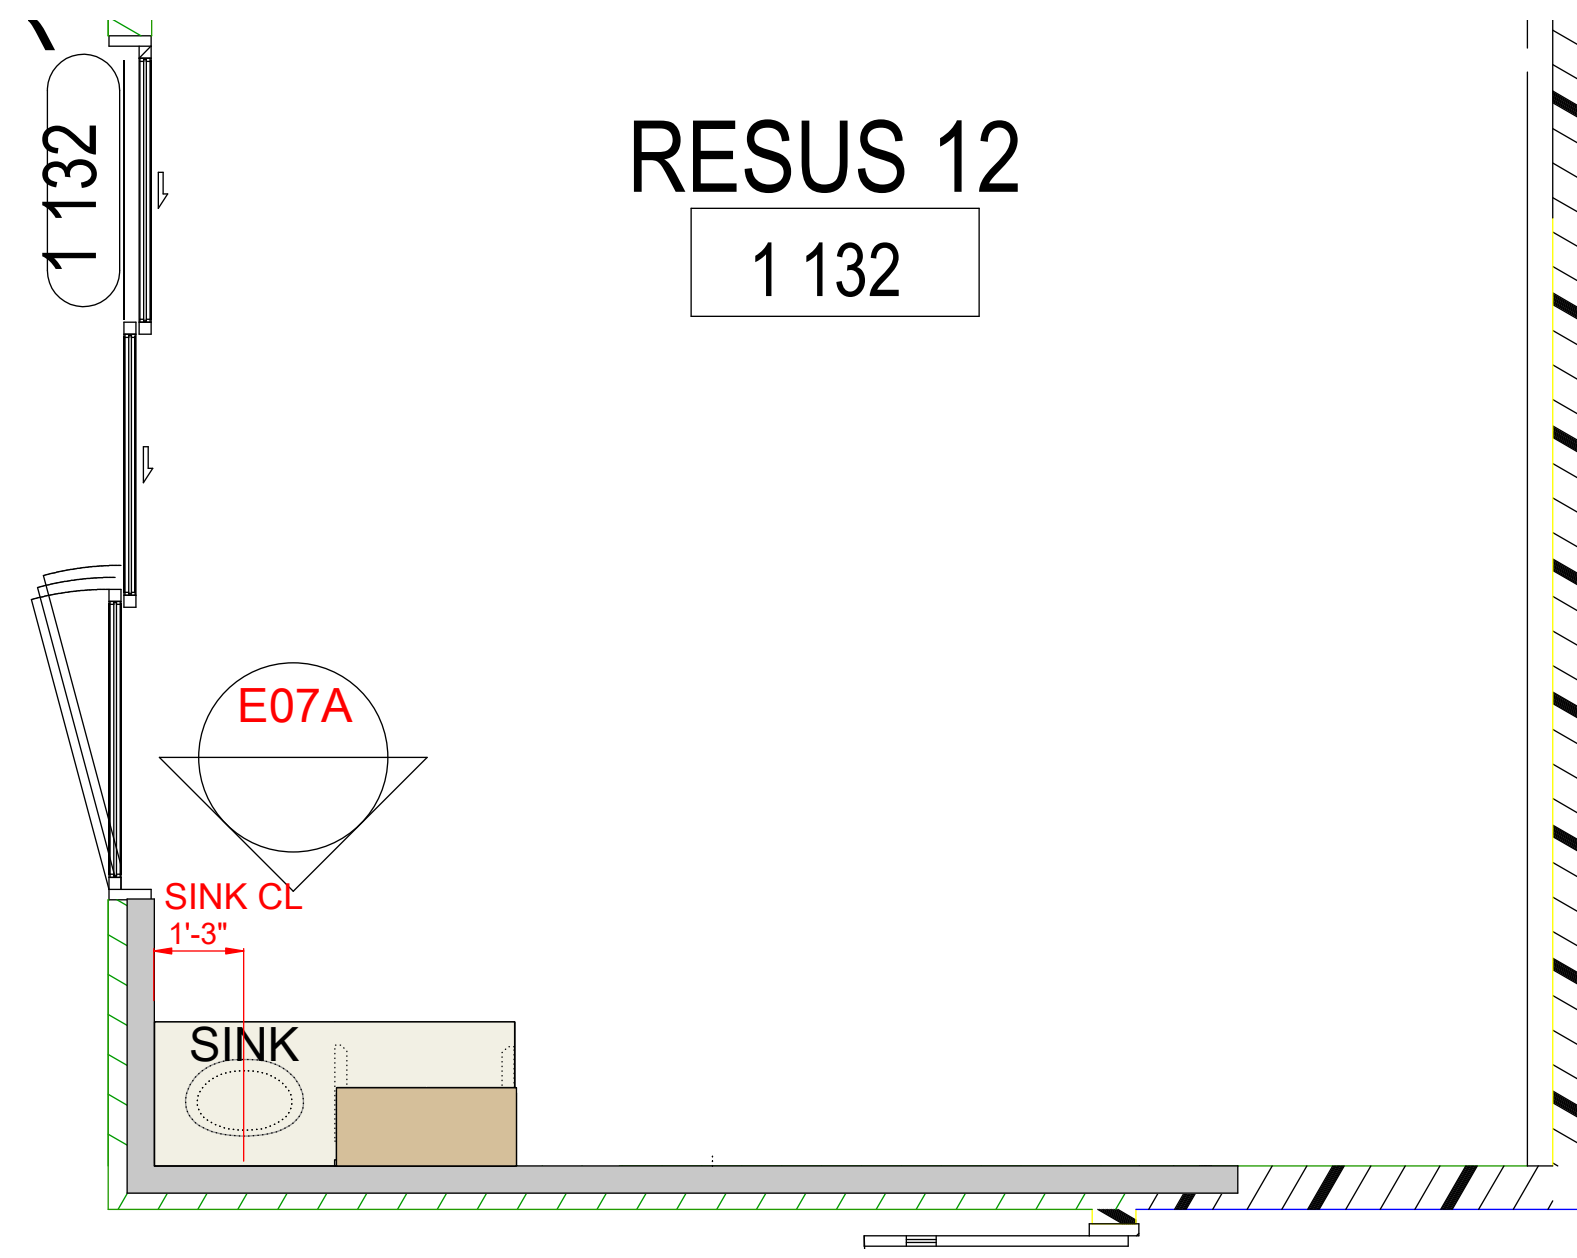

E7A RESUS 12 PLAN VIEW
SCALE: 3/8"=1"

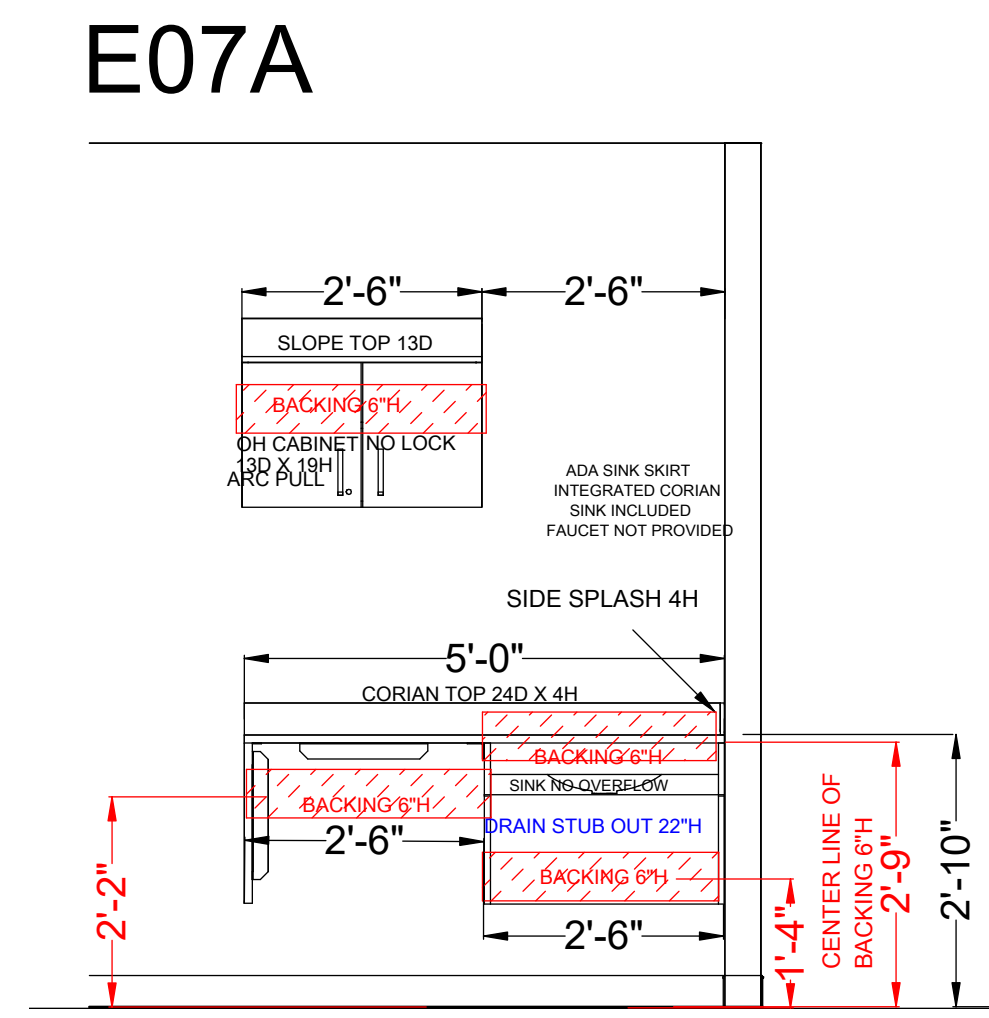


E7A RESUS 12 ELEVATION VIEW
SCALE: 1/2"=1"

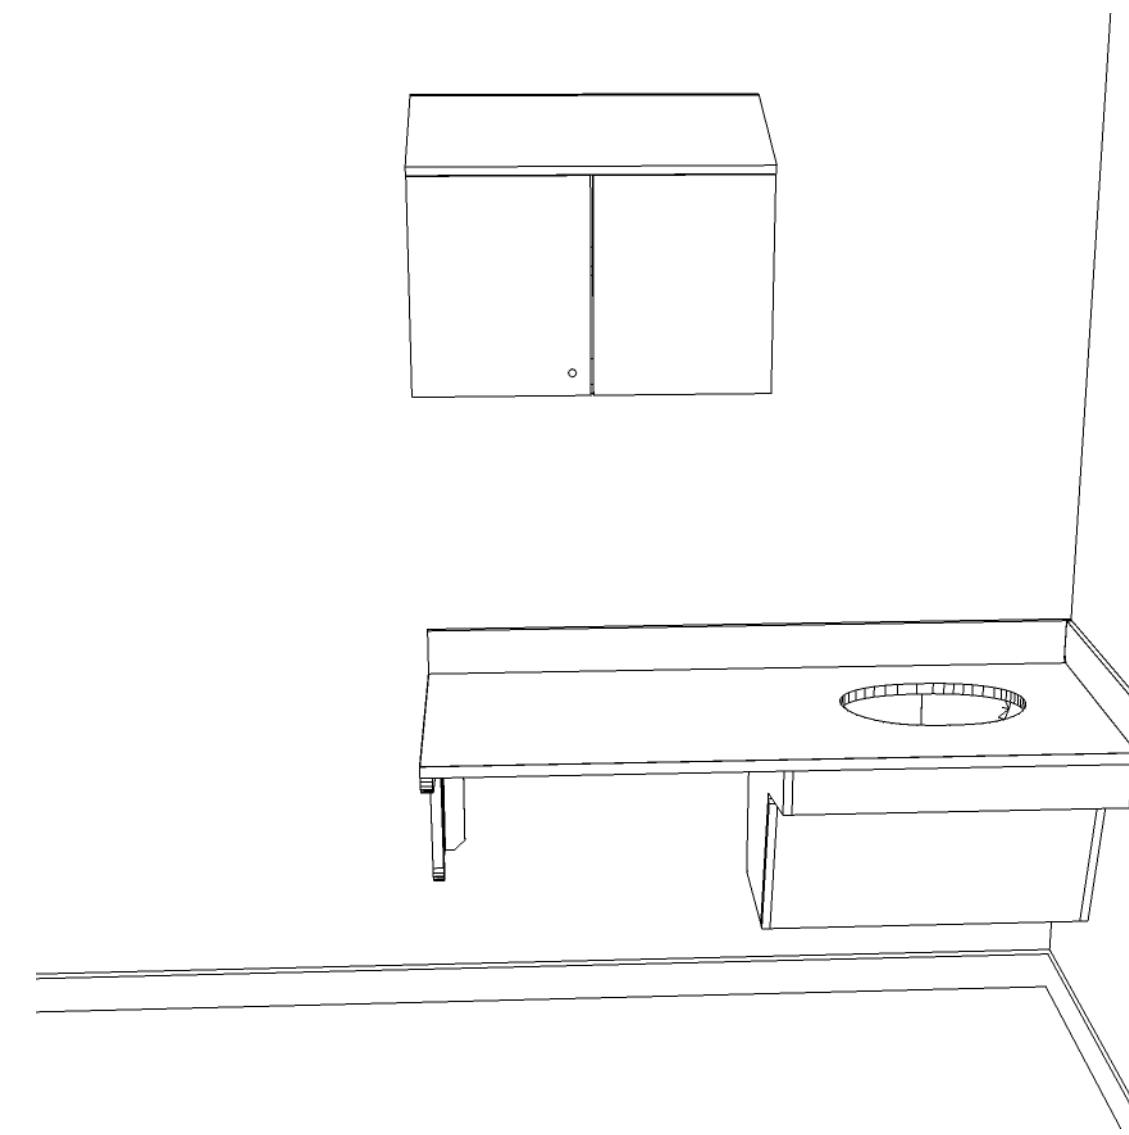


E7A RESUS 12 ISOMETRIC VIEW
SCALE: NTS




E7A RESUS 12 RENDERING
SCALE: NTS

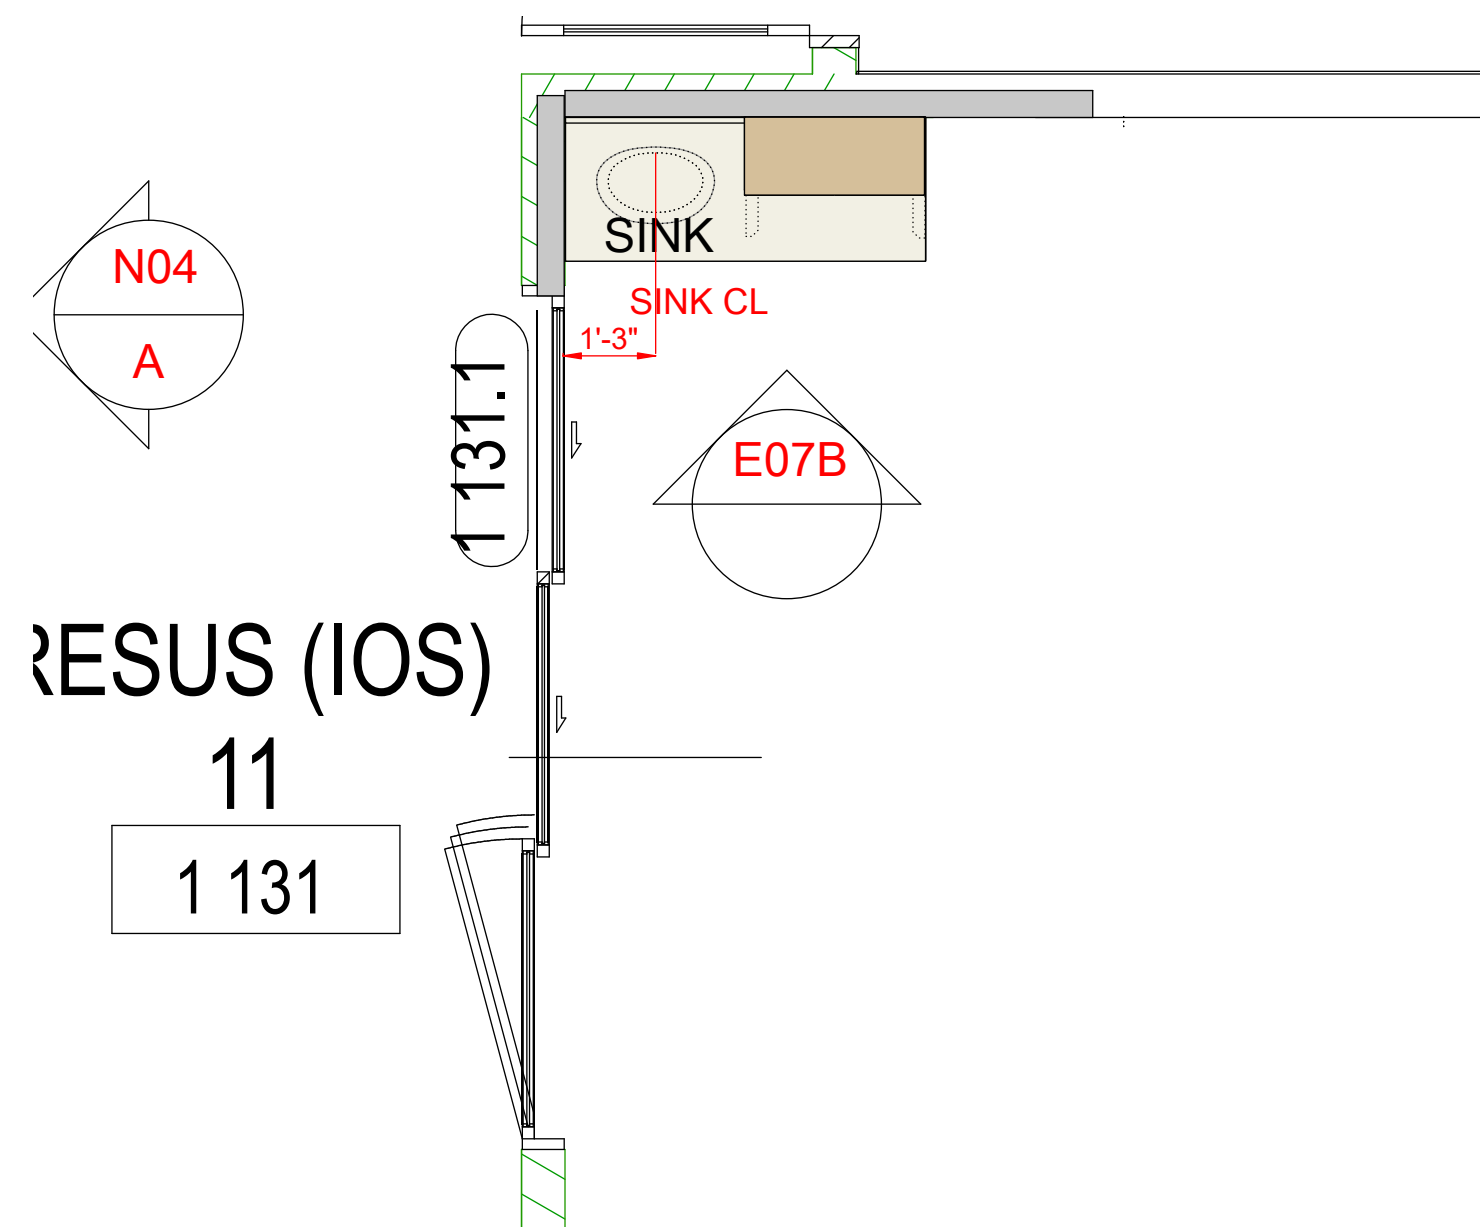

E7B RESUS 11 PLAN VIEW
SCALE: 3/8"=1"

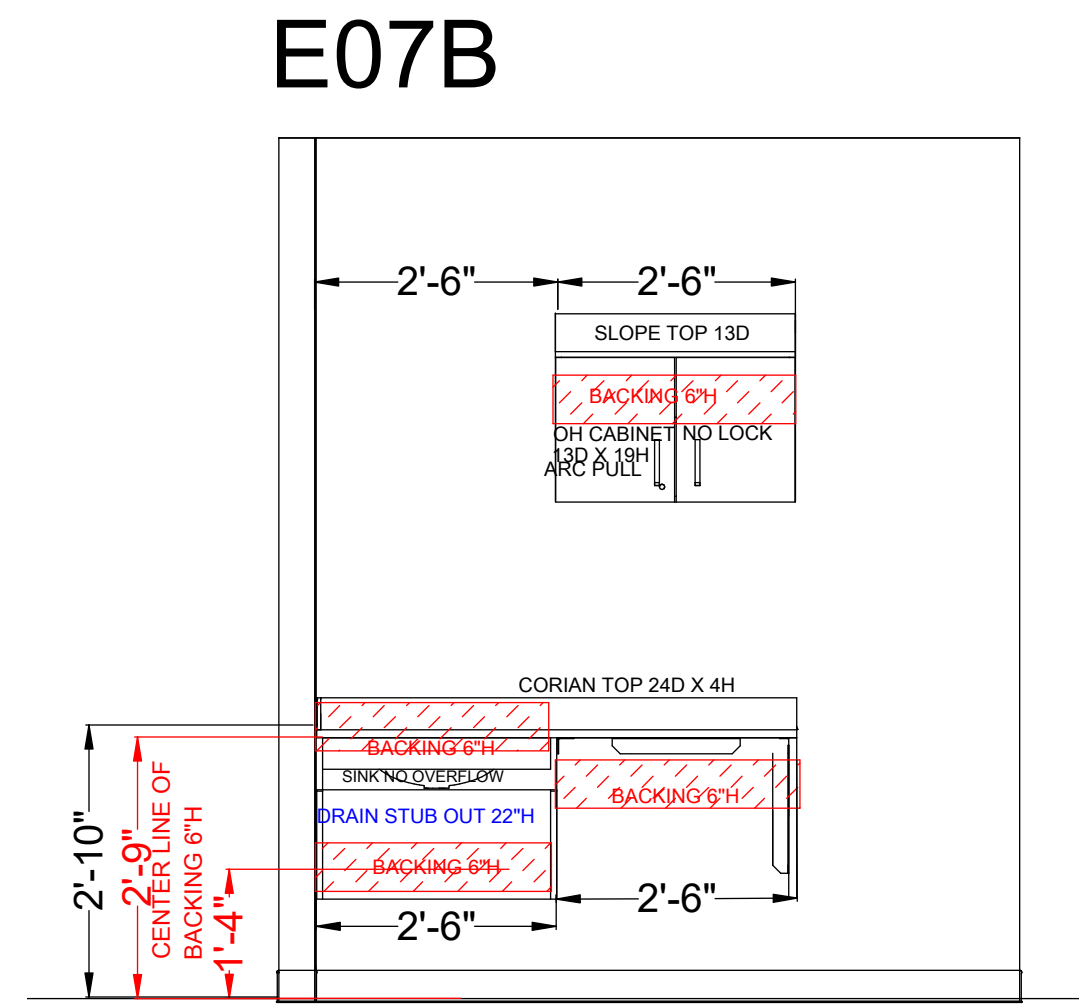


E7B RESUS 11 ELEVATION VIEW
SCALE: 1/2"=1"

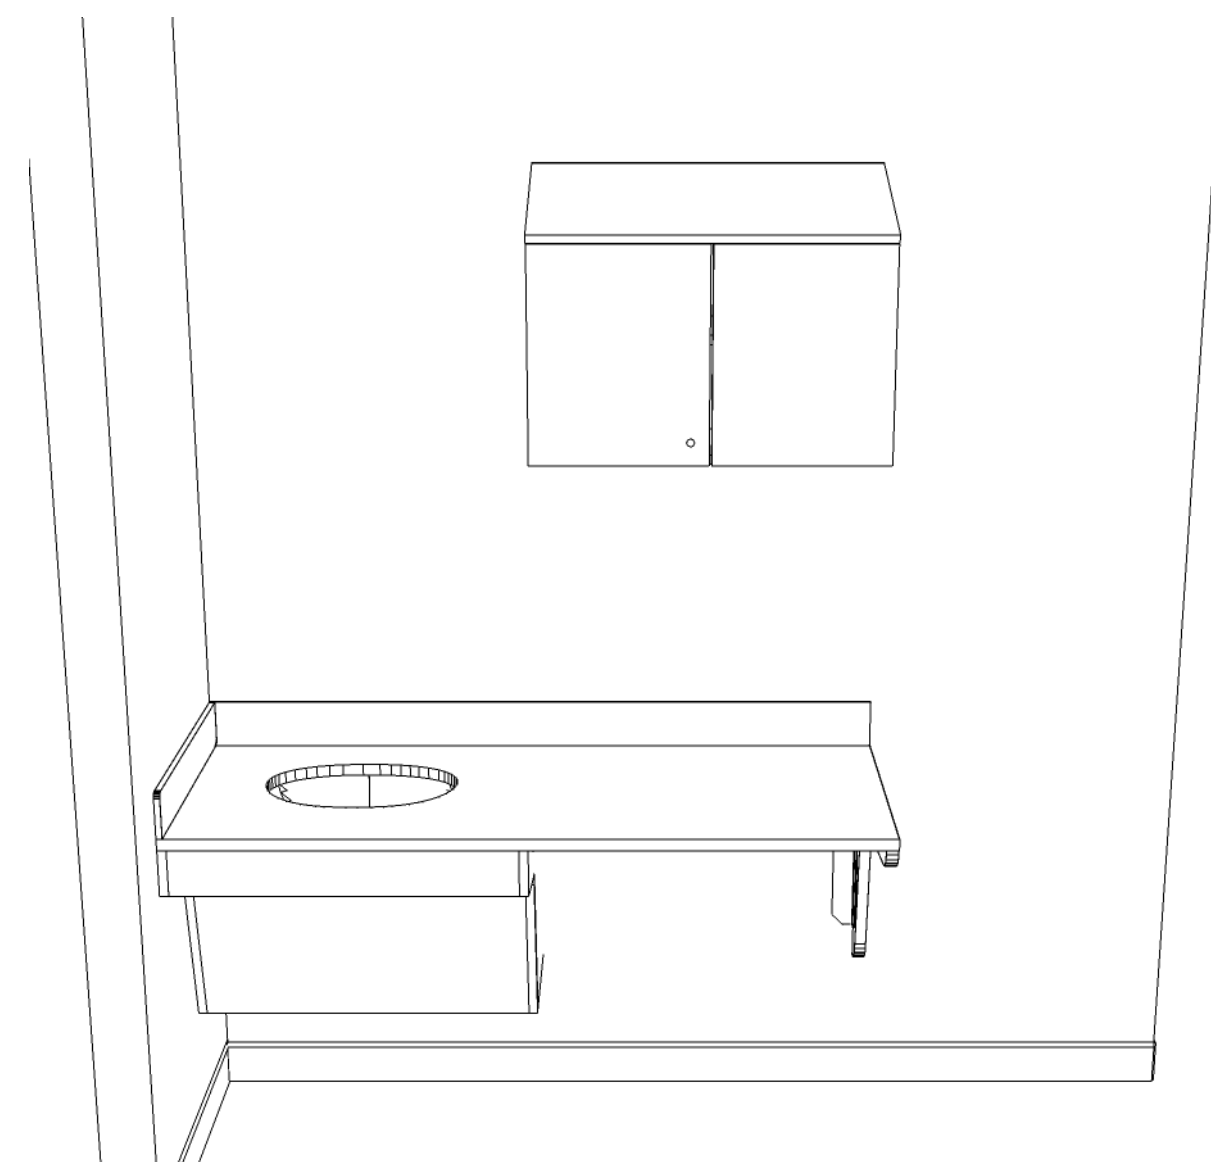


E7B RESUS 11 ISOMETRIC VIEW
SCALE: NTS




E7B RESUS 11 RENDERING
SCALE: NTS

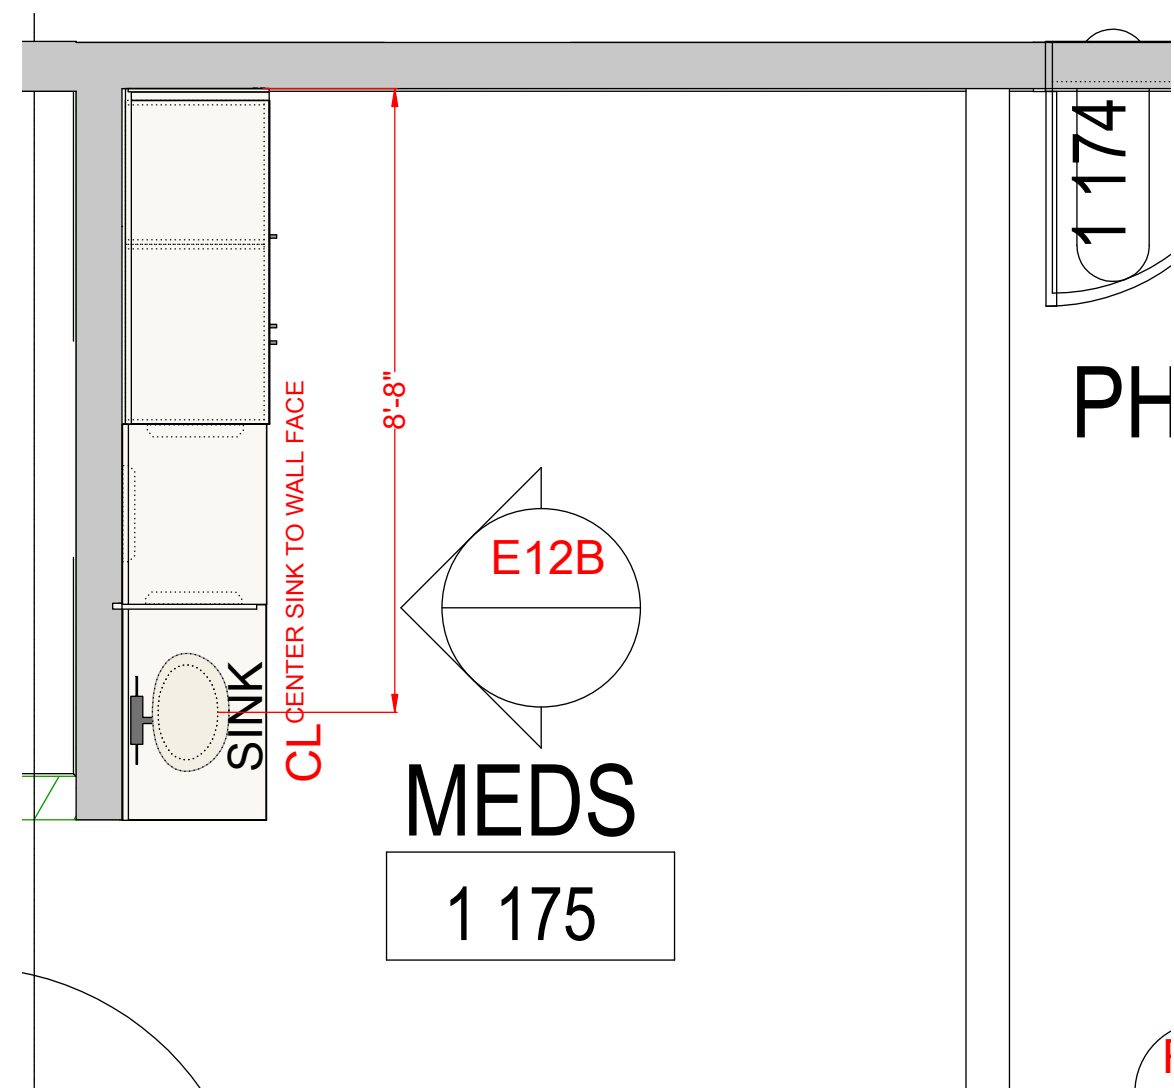

E12B MEDS PLAN VIEW
SCALE: 3/8"=1"

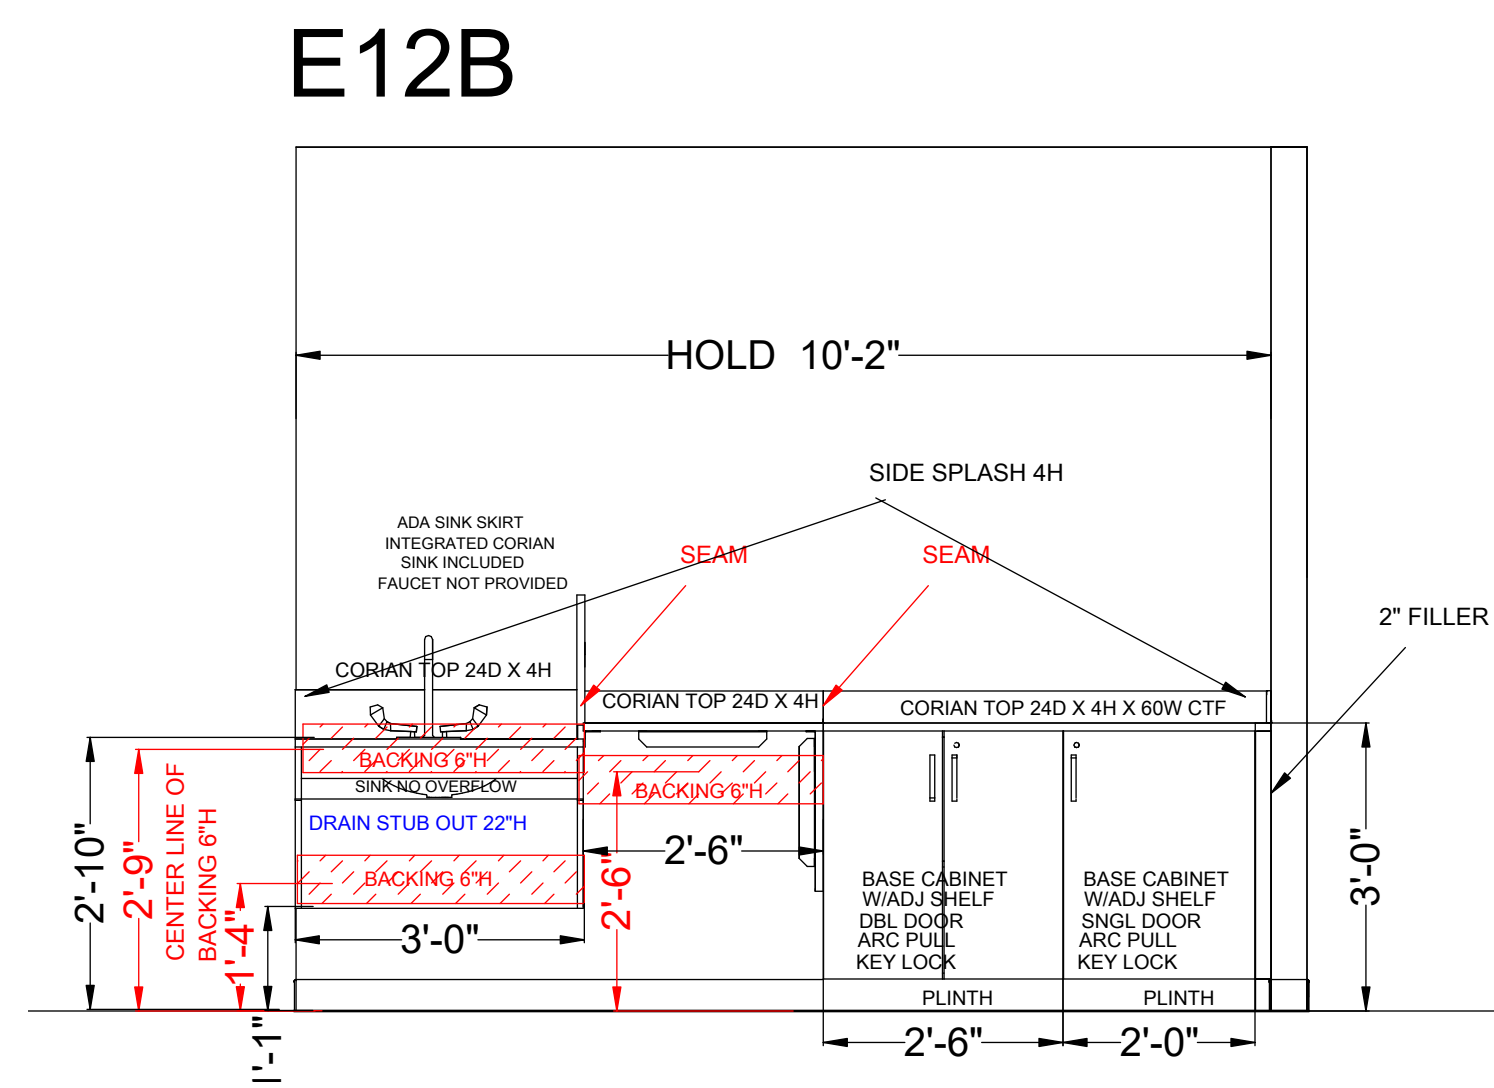

E12B MEDS ELEVATION VIEW
SCALE: 1/2"=1"

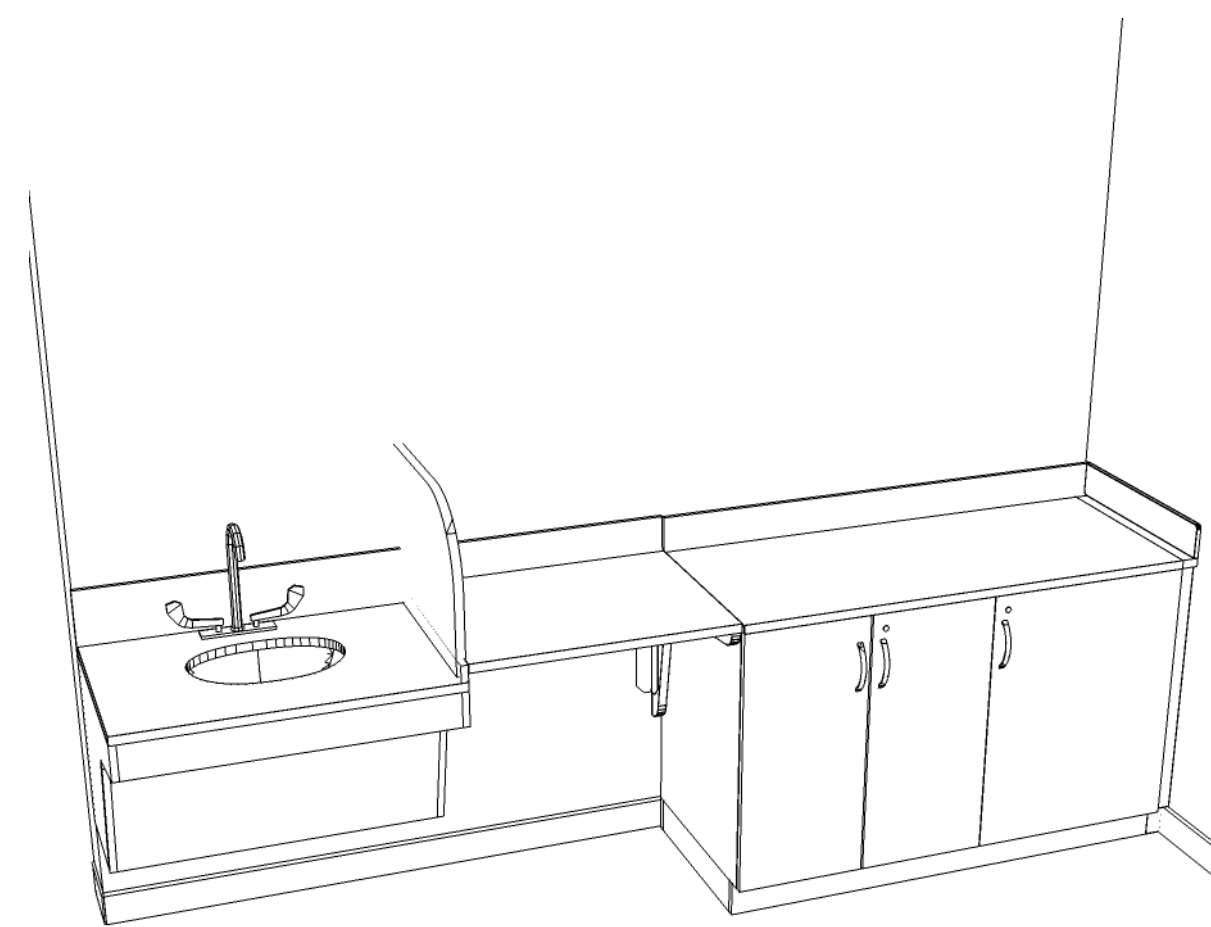

E12B MEDS ELEVATION VIEW
SCALE: NTS



E12B MEDS RENDERING VIEW
SCALE: NTS



workscapes
Tampa

501 E Kennedy Blvd
Suite 100
Tampa, FL 33602
813.620.0048
IC # 806001503

Facility Name: Orlando Health Melbourne Hospital
Project Name: Freestanding ER - Viera
OPC Project #: 23/23960034-19987

Melbourne Viera FSED
EXAM CASEWORK AND LAB



Lake Andrew Dr & Willist Place, Melbourne, FL 32940

Contractors/ Subcontractors to check and verify all dimensions on site prior to proceeding with the work.

This document and any associated materials are the sole property of Workscapes and are not for use other than to internally evaluate Workscapes' services. They are not to be disseminated, distributed, or otherwise conveyed to any third parties without the express written permission of Workscapes.


Project No.: 89853
Sheet Size: 24X36
Scale: SEE PLAN
Designer: K.COTTRELL
Location: TAMPA, FL
Date: 3/2/2026
Signed:

Revisions:
02-17-2026_R1_ADD FILLER
03-02-2026_R2_ADJ SCOPE
date.....
date.....
date.....
date.....
date.....
date.....


This drawing is intended to indicate furniture location and configuration only and is not to be used permitting or construction.

For exact architectural configurations, refer to architectural contract documents prepared by others.


Sheet:

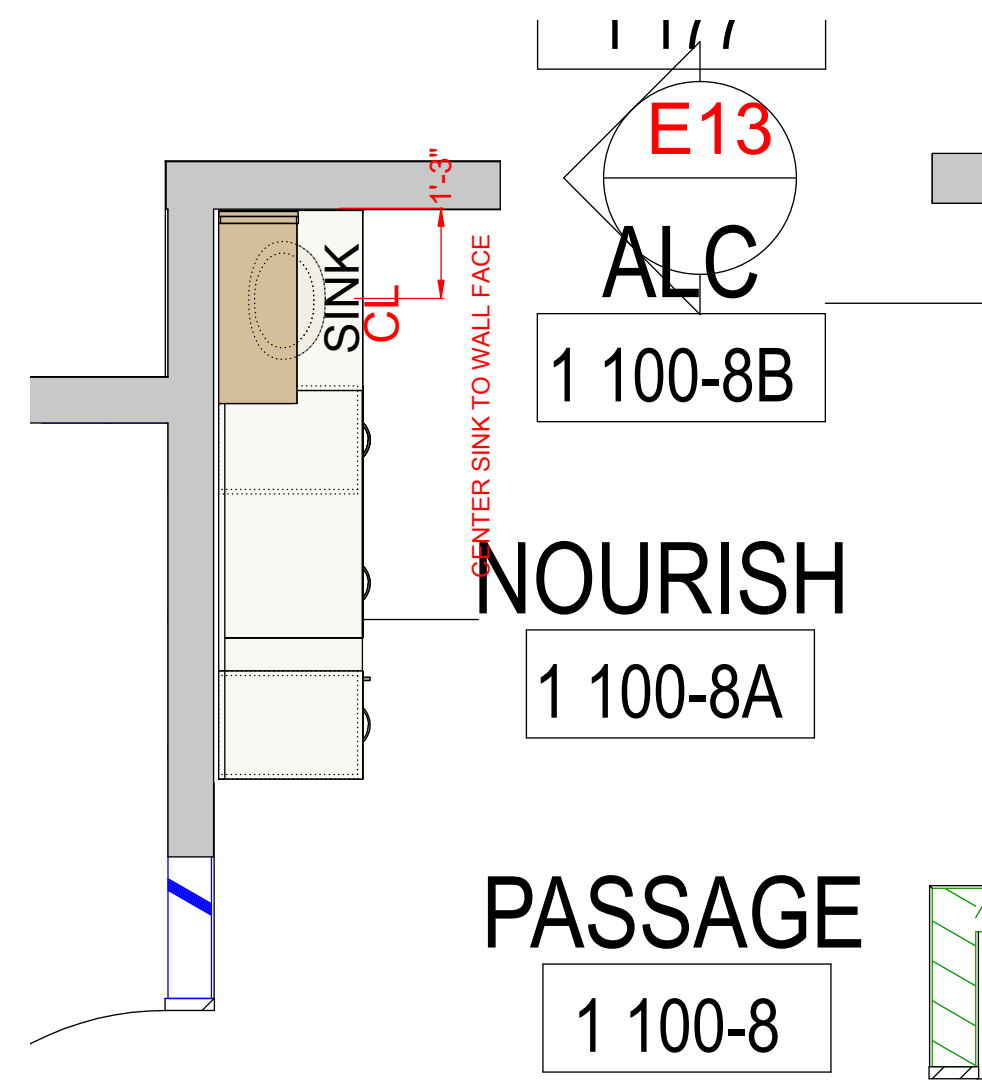

E13 NOURISH PLAN VIEW
SCALE: 3/8"=1"

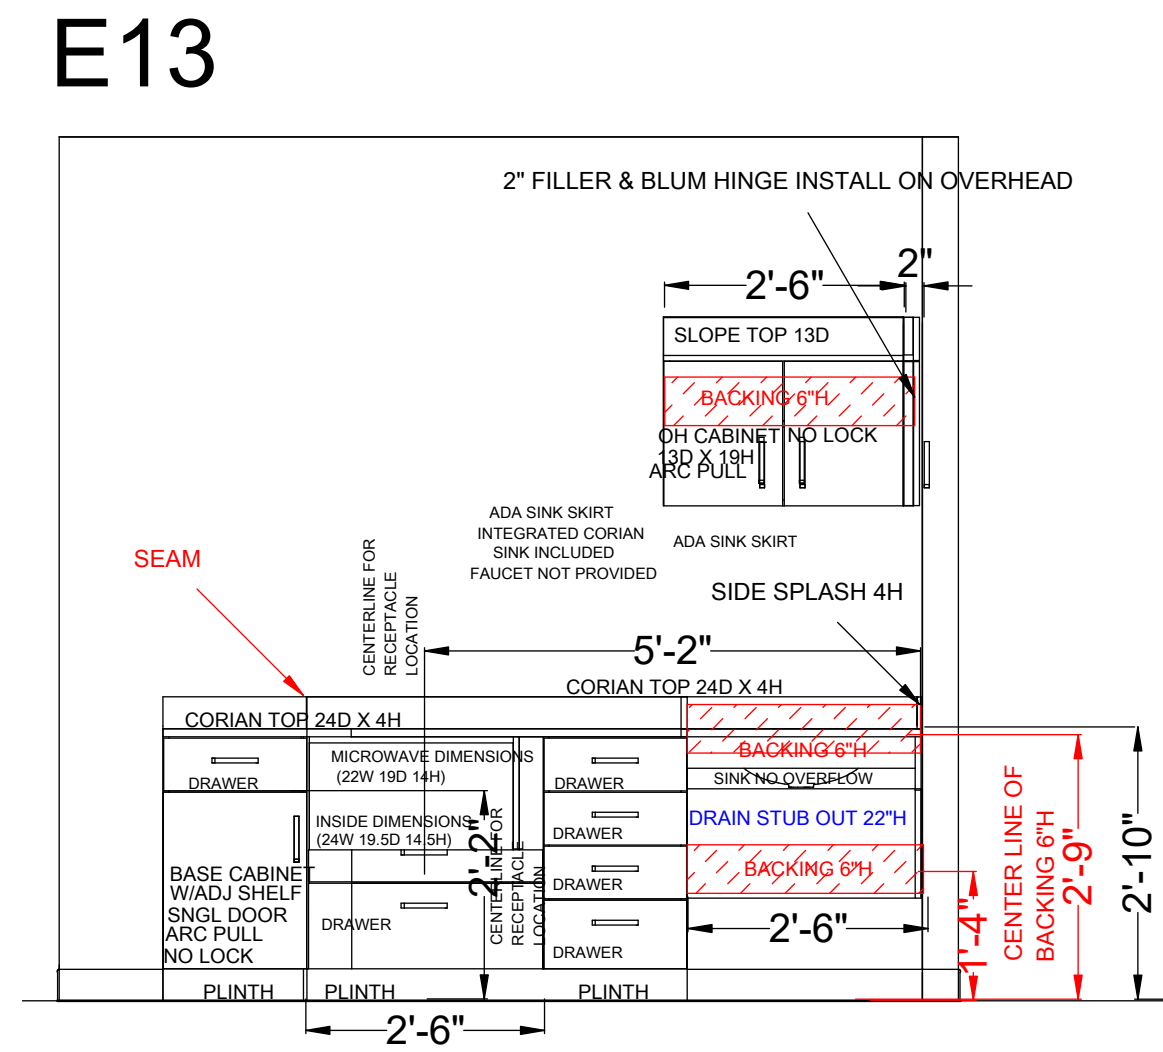

E13 NOURISH ELEVATION VIEW
SCALE: 1/2"=1"

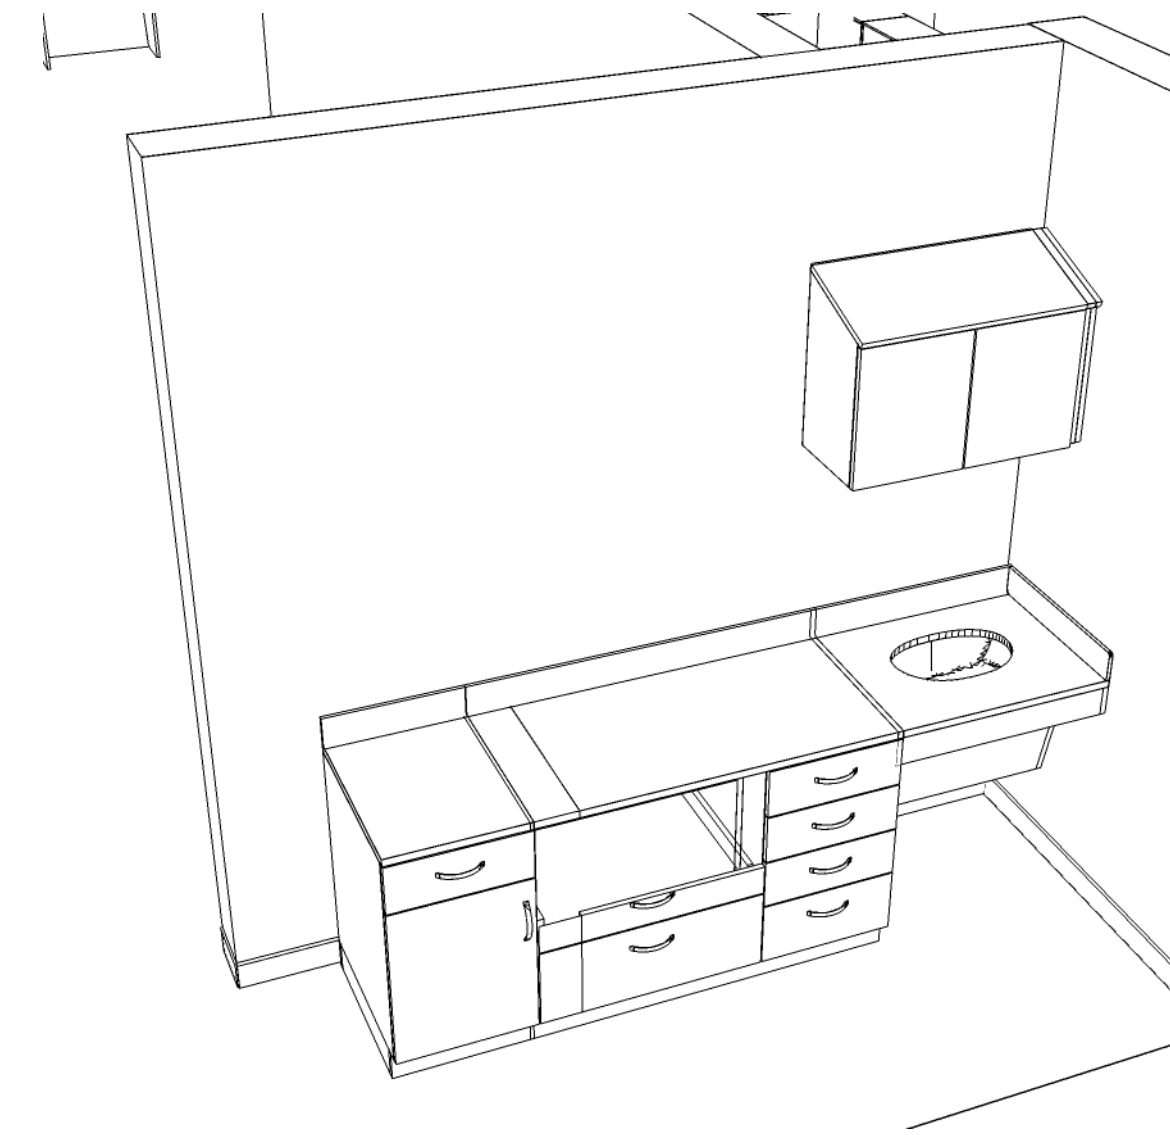

E13 NOURISH ISOMETRIC VIEW
SCALE: NTS



E13 NOURISH RENDERING
SCALE: NTS



workscapes
Tampa

501 E Kennedy Blvd
Suite 100
Tampa, FL 33602
813.620.0048
IC # 80001503

Facility Name: Orlando Health Melbourne Hospital

Project Name: Freestanding ER - Viera

OPC Project #: 23/23960034-19987

Melbourne Viera FSED
EXAM CASEWORK AND LAB



Lake Andrew Dr & Willist Place, Melbourne, FL 32940

Contractors/ Subcontractors to check and verify all dimensions on site prior to proceeding with the work.

This document and any associated materials are the sole property of Workscapes and are not for use other than to internally evaluate Workscapes' services. They are not to be disseminated, distributed, or otherwise conveyed to any third parties without the express written permission of Workscapes.

Project No.: 89853

Sheet Size: 24X36

Scale: SEE PLAN

Designer: K.COTTRELL

Location: TAMPA, FL

Date: 3/2/2026

Signed:

Revisions:

02-17-2026	R1	ADD FILLER	date
03-02-2026	R2	ADJ SCOPE	date
			date
			date
			date
			date

This drawing is intended to indicate furniture location and configuration only and is not to be used permitting or construction.

For exact architectural configurations, refer to architectural contract documents prepared by others.

Sheet:

Contractors/ Subcontractors to check and verify all dimensions on site prior to proceeding with the work.

This document and any associated materials are the sole property of Workscapes and are not for use other than to internally evaluate Workscapes' services. They are not to be disseminated, distributed, or otherwise conveyed to any third parties without the express written permission of Workscapes.


Project No.: 89853
Sheet Size: 24X36
Scale: SEE PLAN
Designer: K.COTTRELL
Location: TAMPA, FL
Date: 3/2/2026
Signed:

Revisions:


02-17-2026	R1	ADD FILLER
03-02-2026	R2	ADJ SCOPE
date		
date		
date		
date		
date		

This drawing is intended to indicate furniture location and configuration only and is not to be used permitting or construction.


For exact architectural configurations, refer to architectural contract documents prepared by others.

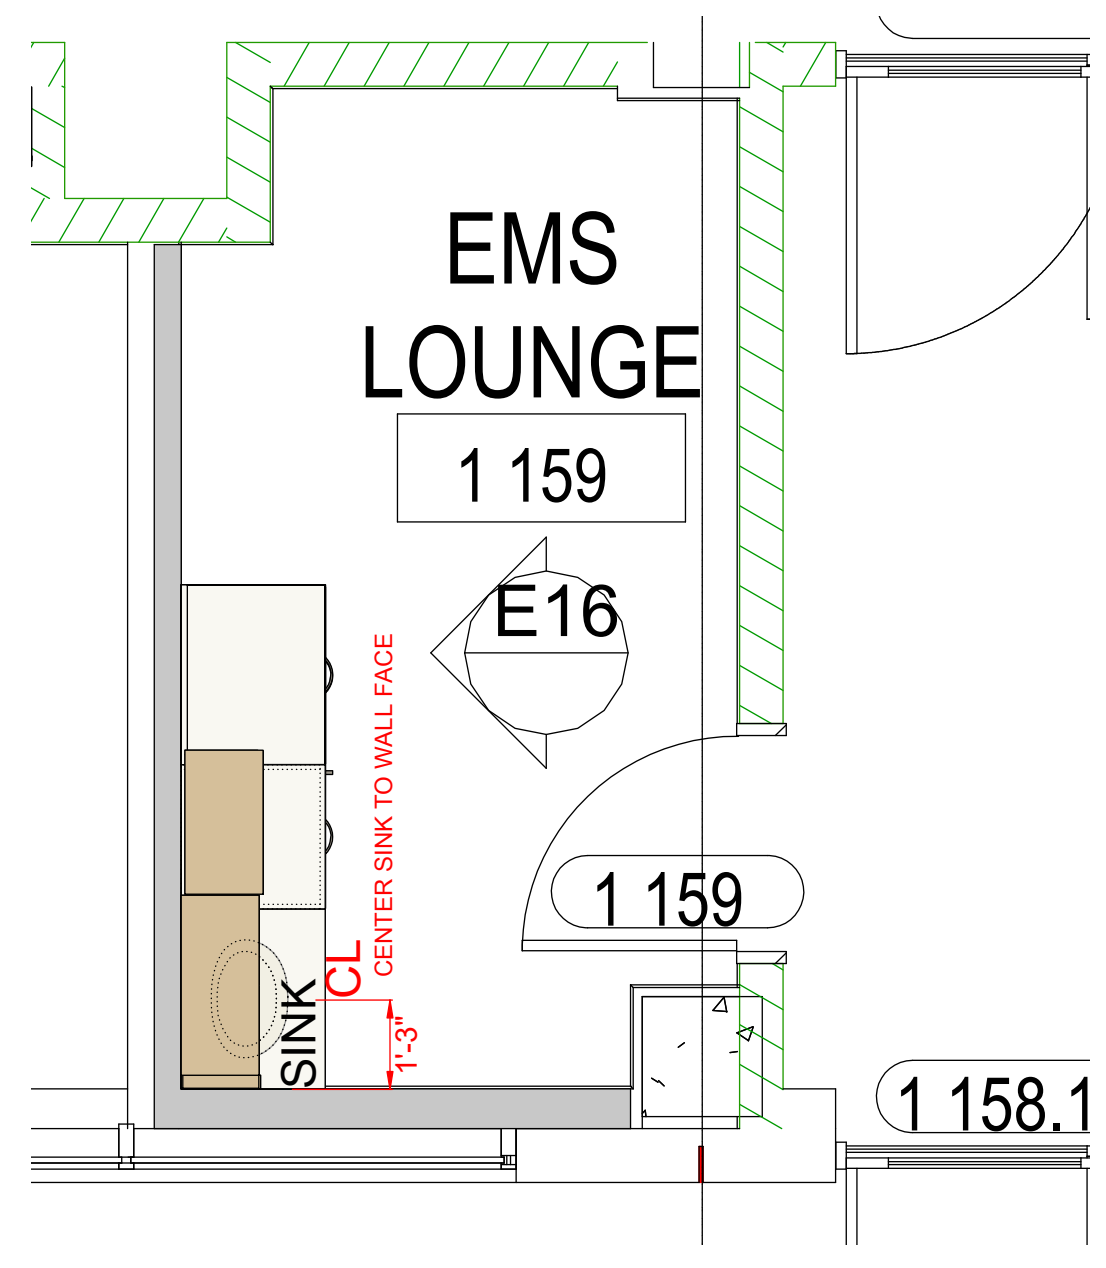

16 EMS PLAN VIEW
SCALE: 3/8"=1"

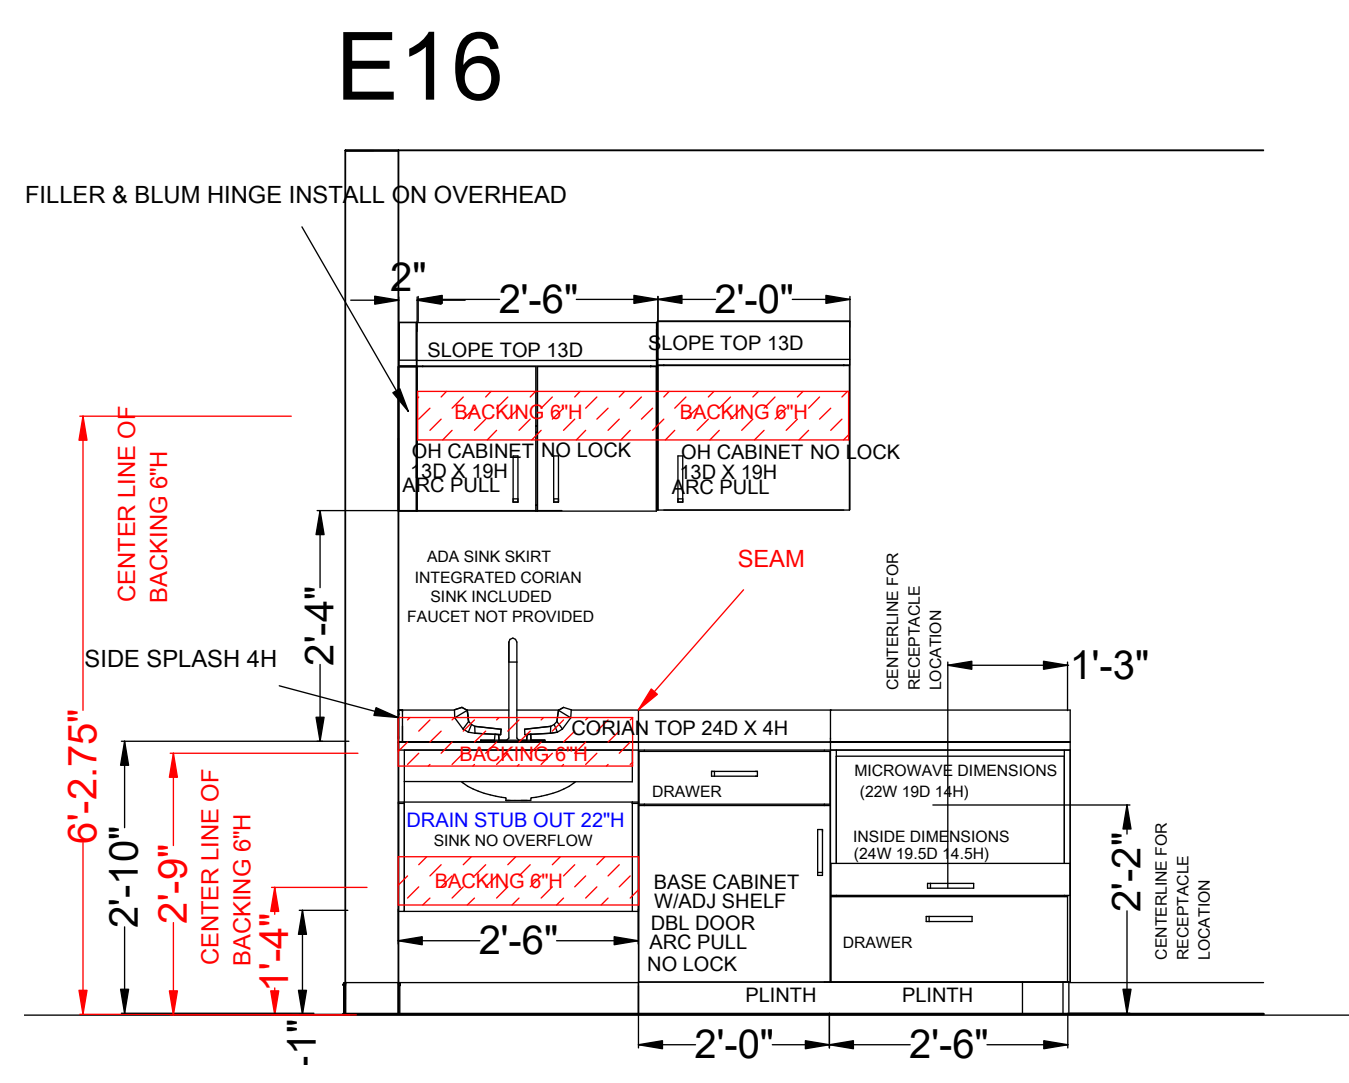


16 EMS ELEVATION VIEW
SCALE: 1/2"=1"

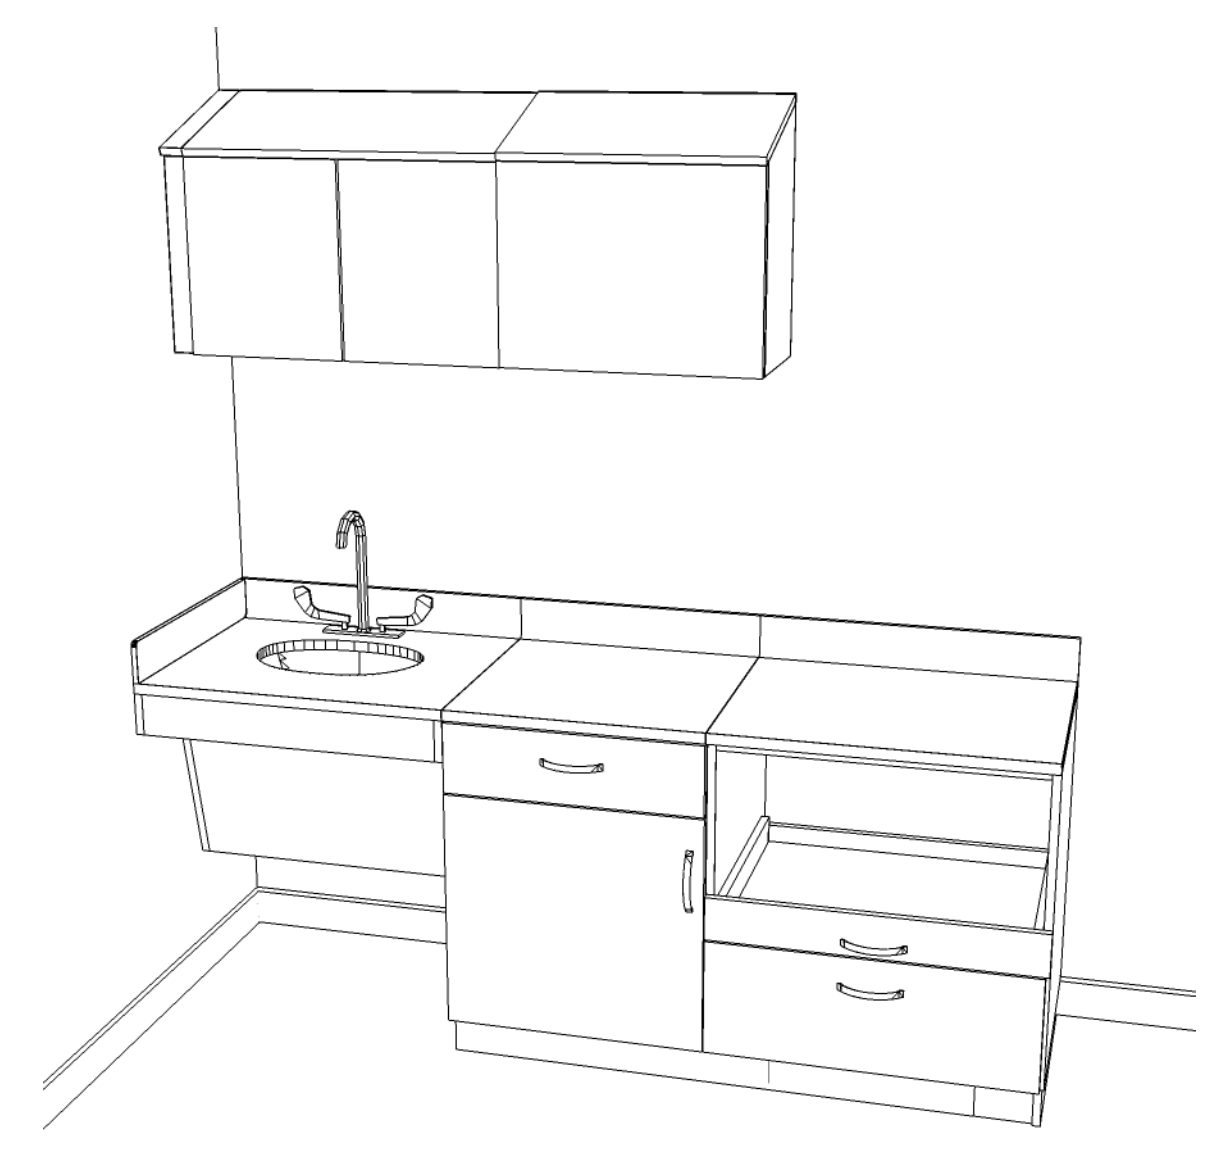


16 EMS ISOMETRIC VIEW
SCALE: NTS




16 EMS RENDERING
SCALE: NTS

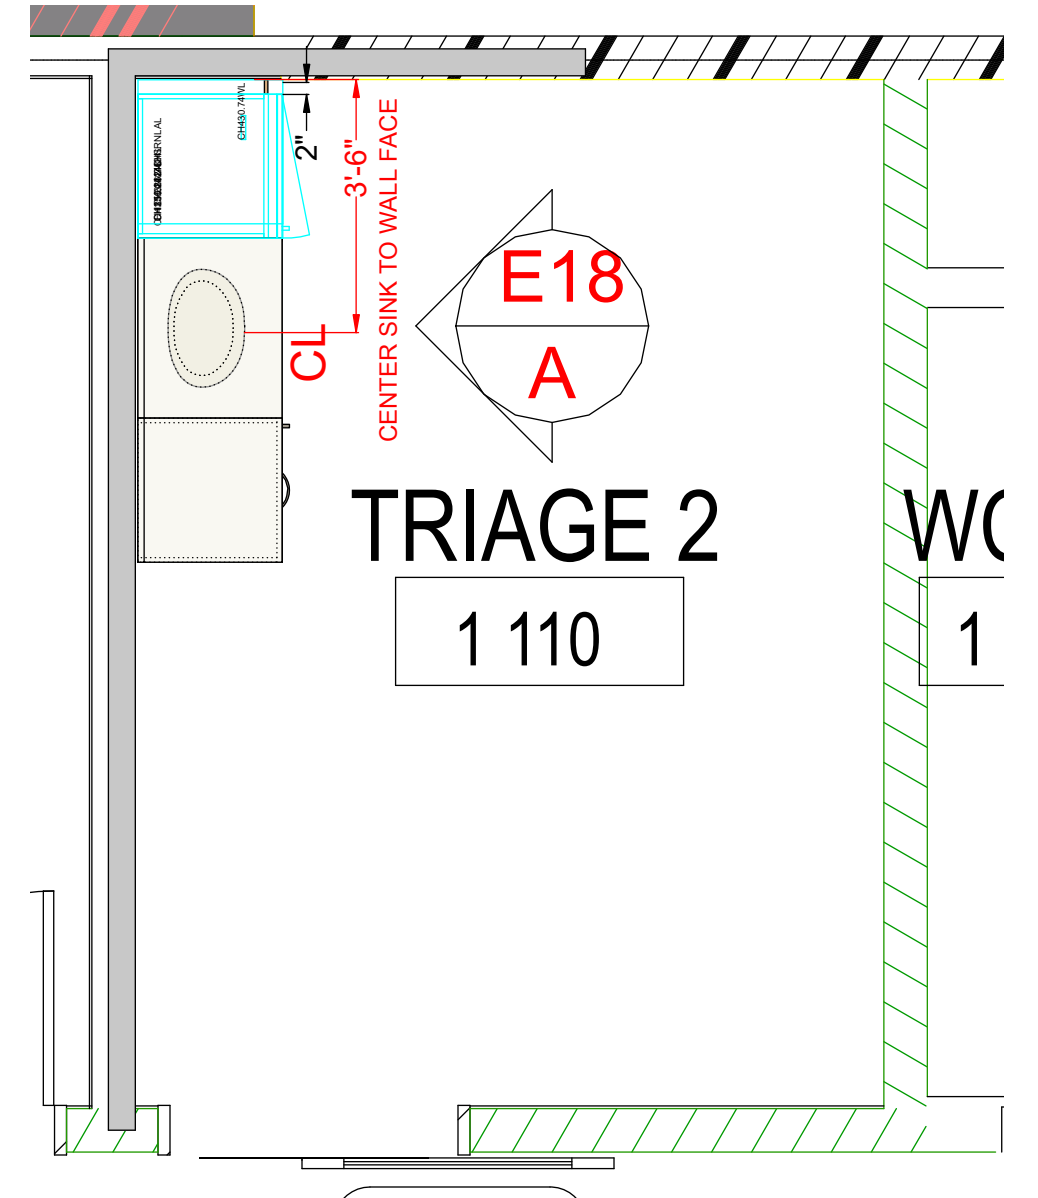

18 TRIAGE 2 PLAN VIEW
SCALE: 3/8"=1"

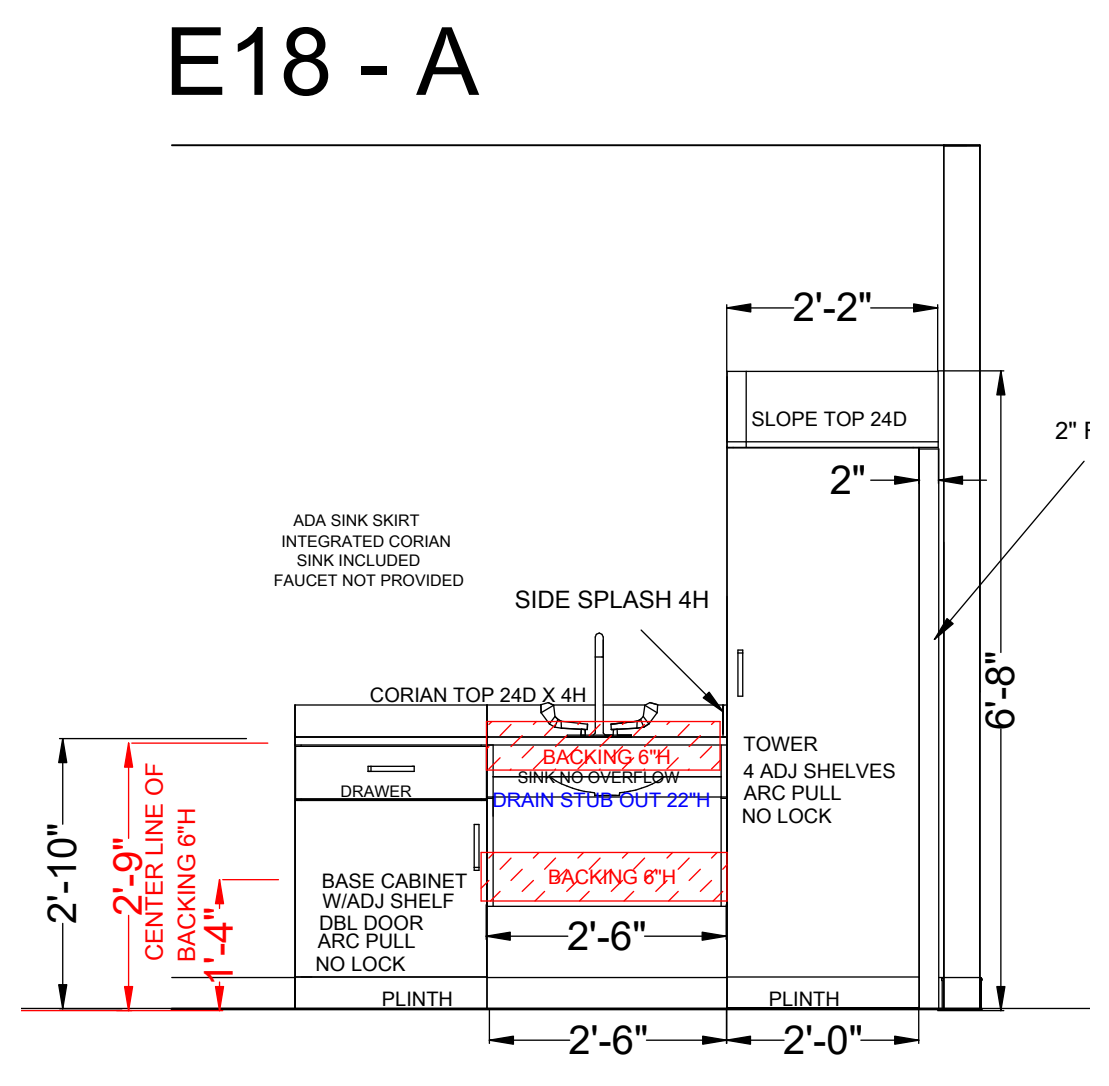


18 TRIAGE 2 ELEVATION VIEW
SCALE: 1/2"=1"

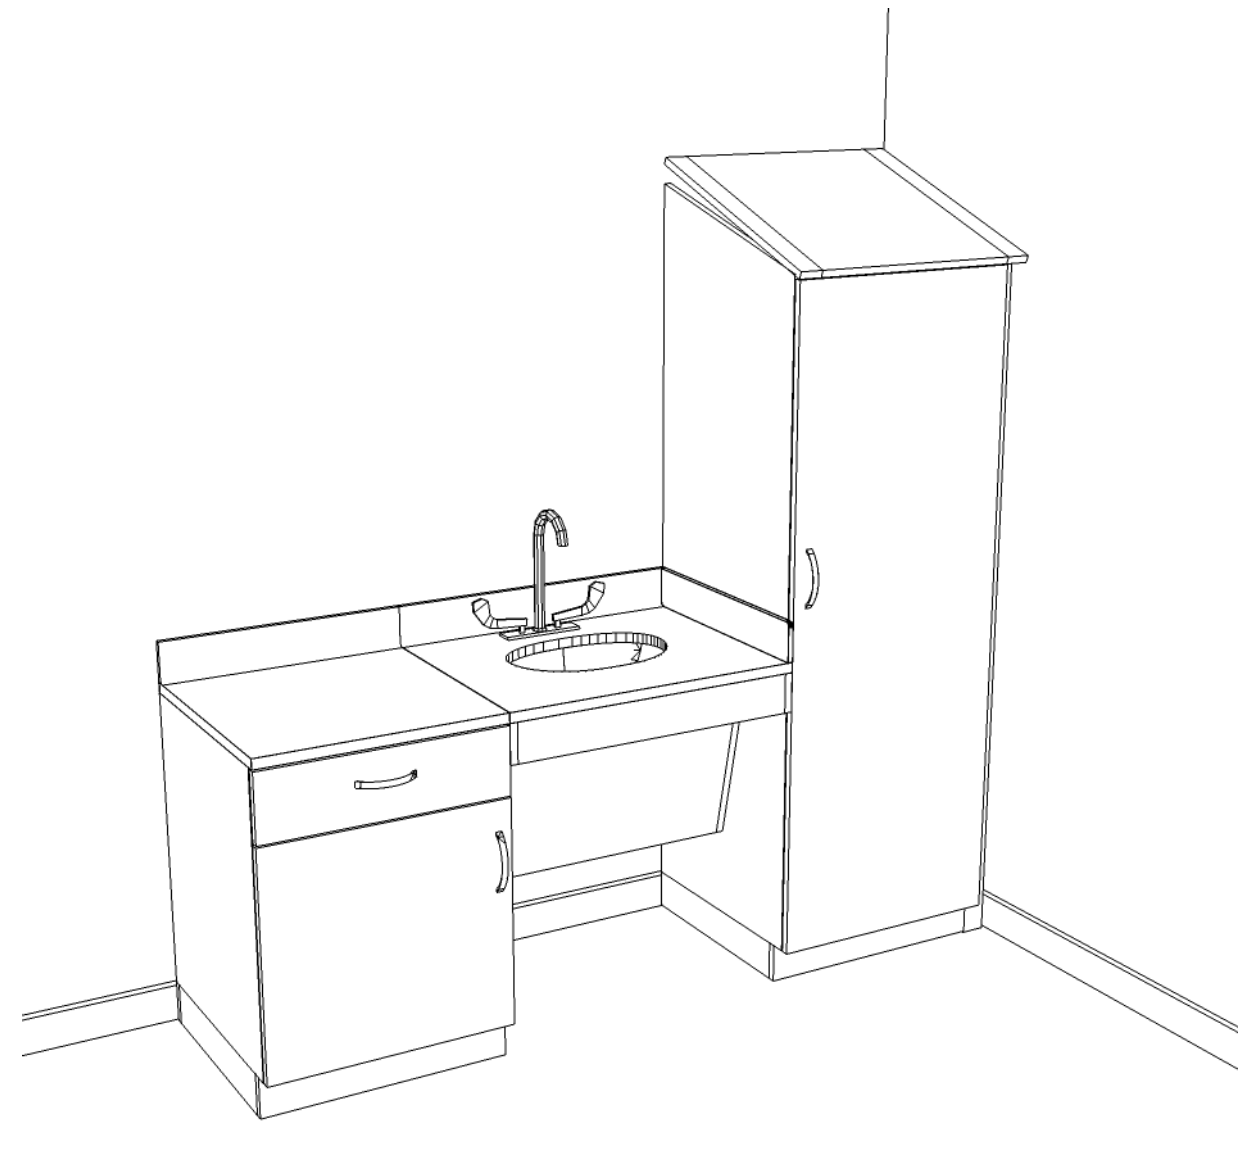


18 TRIAGE 2 ISOMETRIC VIEW
SCALE: NTS




18 TRIAGE 2 RENDERING
SCALE: NTS

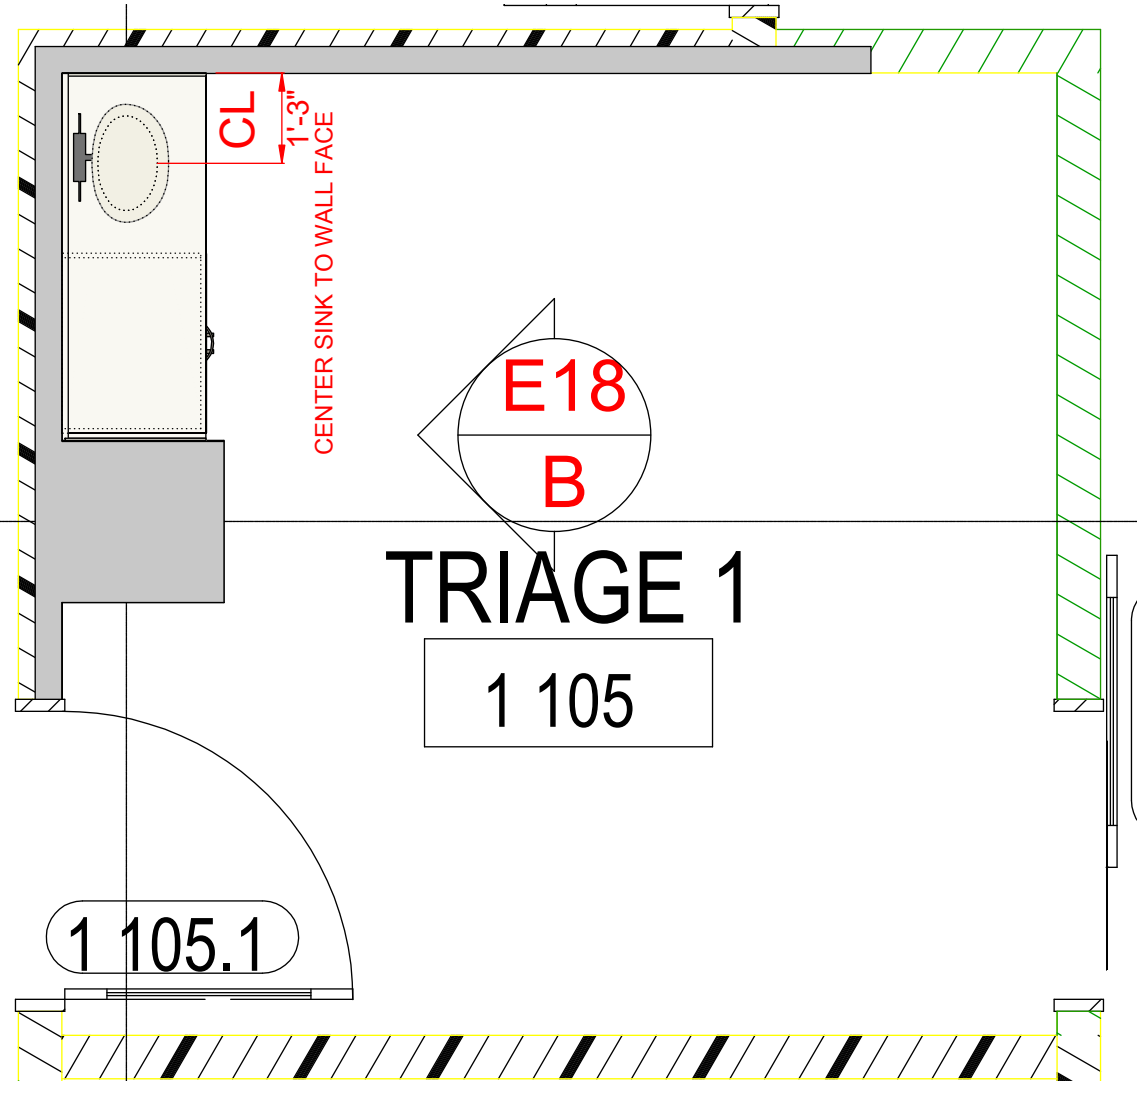

18 TRIAGE 1 PLAN VIEW
SCALE: 3/8"=1"

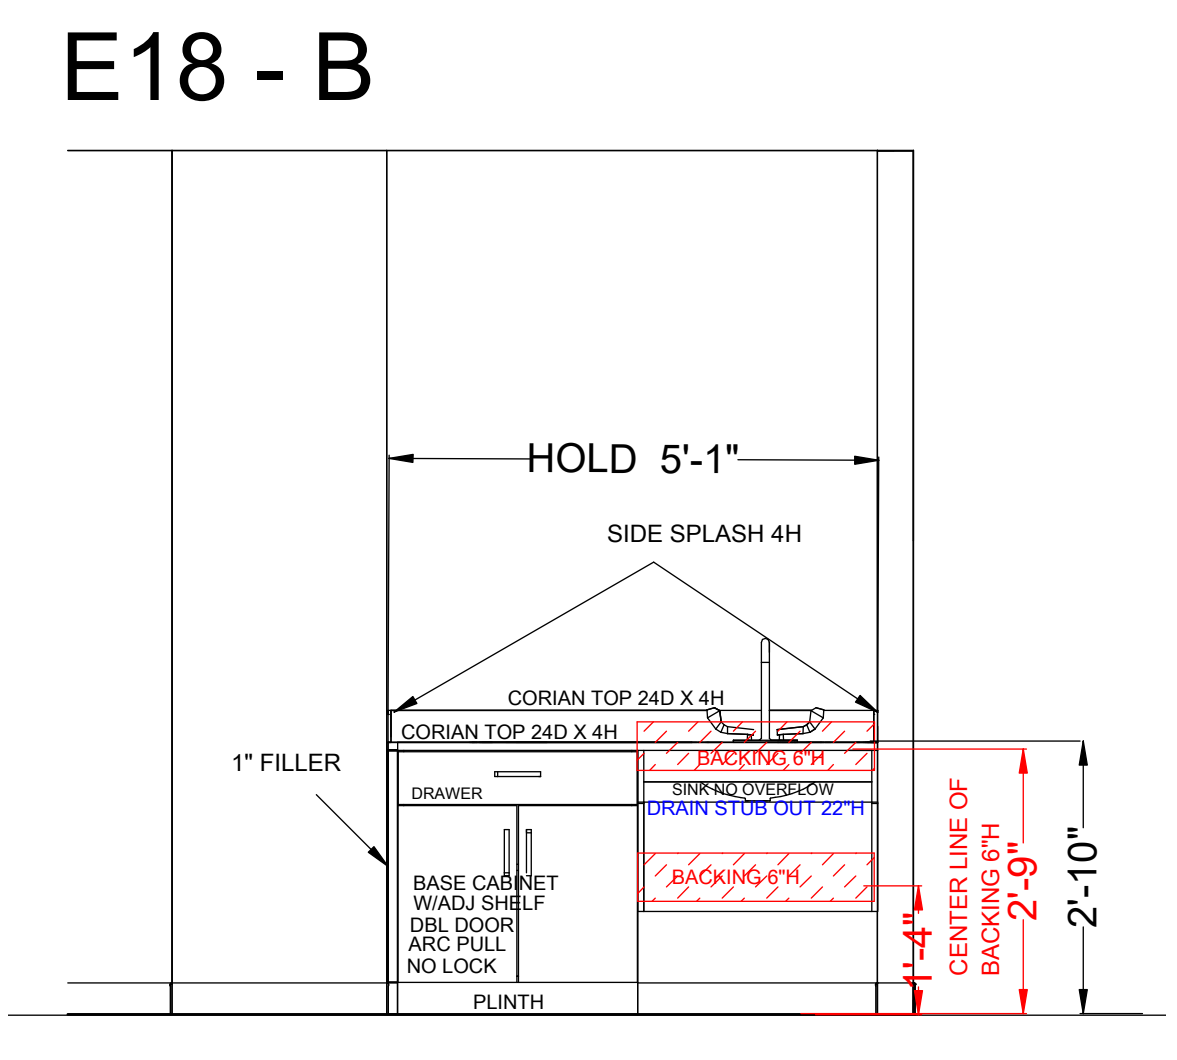

18 TRIAGE 1 ELEVATION VIEW
SCALE: 1/2"=1"

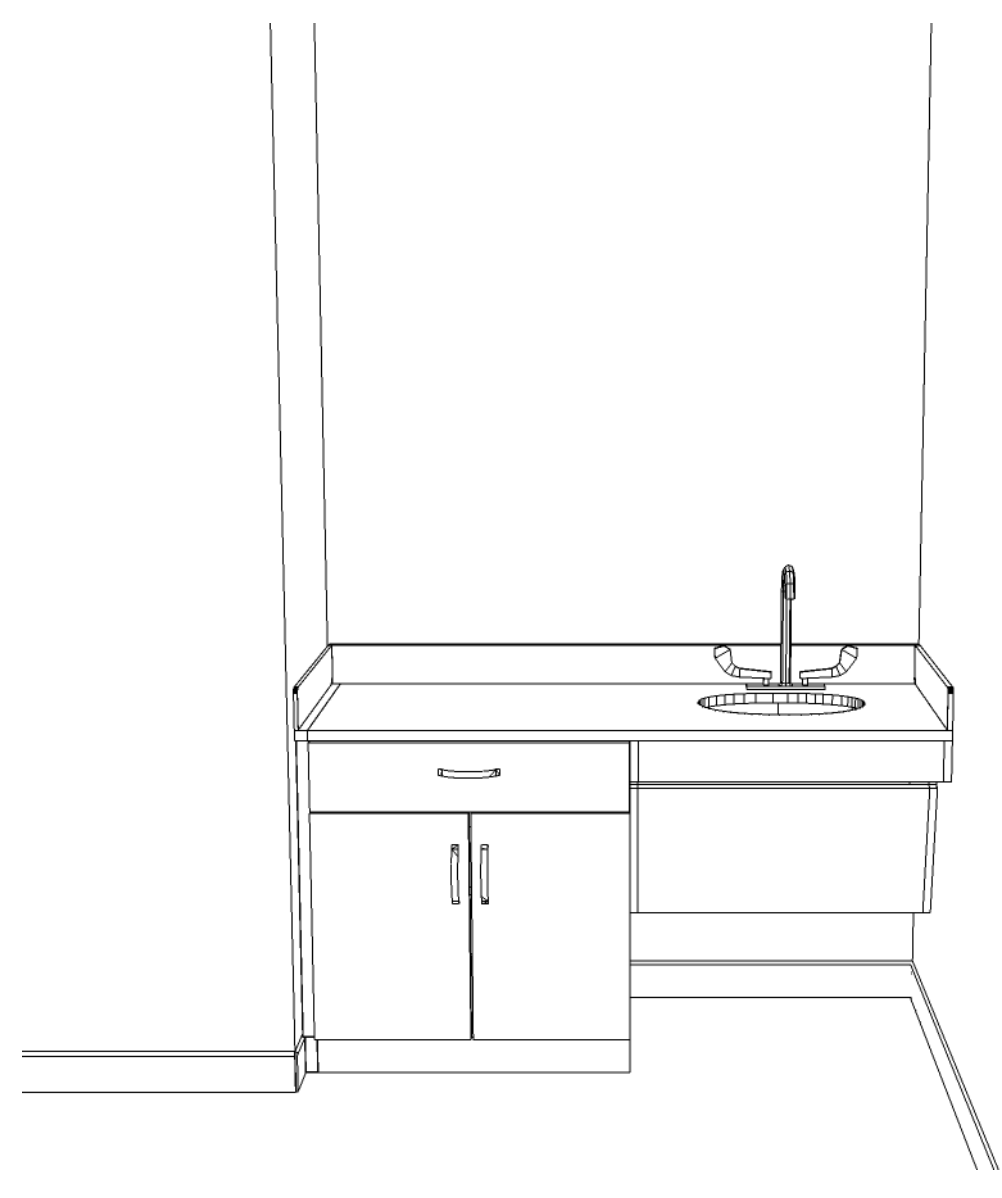

18 TRIAGE 1 ISOMETRIC VIEW
SCALE: NTS



18 TRIAGE 1 RENDERING VIEW
SCALE: NTS

Contractors/ Subcontractors to check and verify all dimensions on site prior to proceeding with the work.

This document and any associated materials are the sole property of Workscapes and are not for use other than to internally evaluate Workscapes' services. They are not to be disseminated, distributed, or otherwise conveyed to any third parties without the express written permission of Workscapes.


Project No.: 89853
Sheet Size: 24X36
Scale: SEE PLAN
Designer: K.COTTRELL
Location: TAMPA, FL
Date: 3/2/2026
Signed:

Revisions:


02-17-2026	R1	ADD FILLER
03-02-2026	R2	ADJ SCOPE
date		
date		
date		
date		
date		

This drawing is intended to indicate furniture location and configuration only and is not to be used permitting or construction.


For exact architectural configurations, refer to architectural contract documents prepared by others.

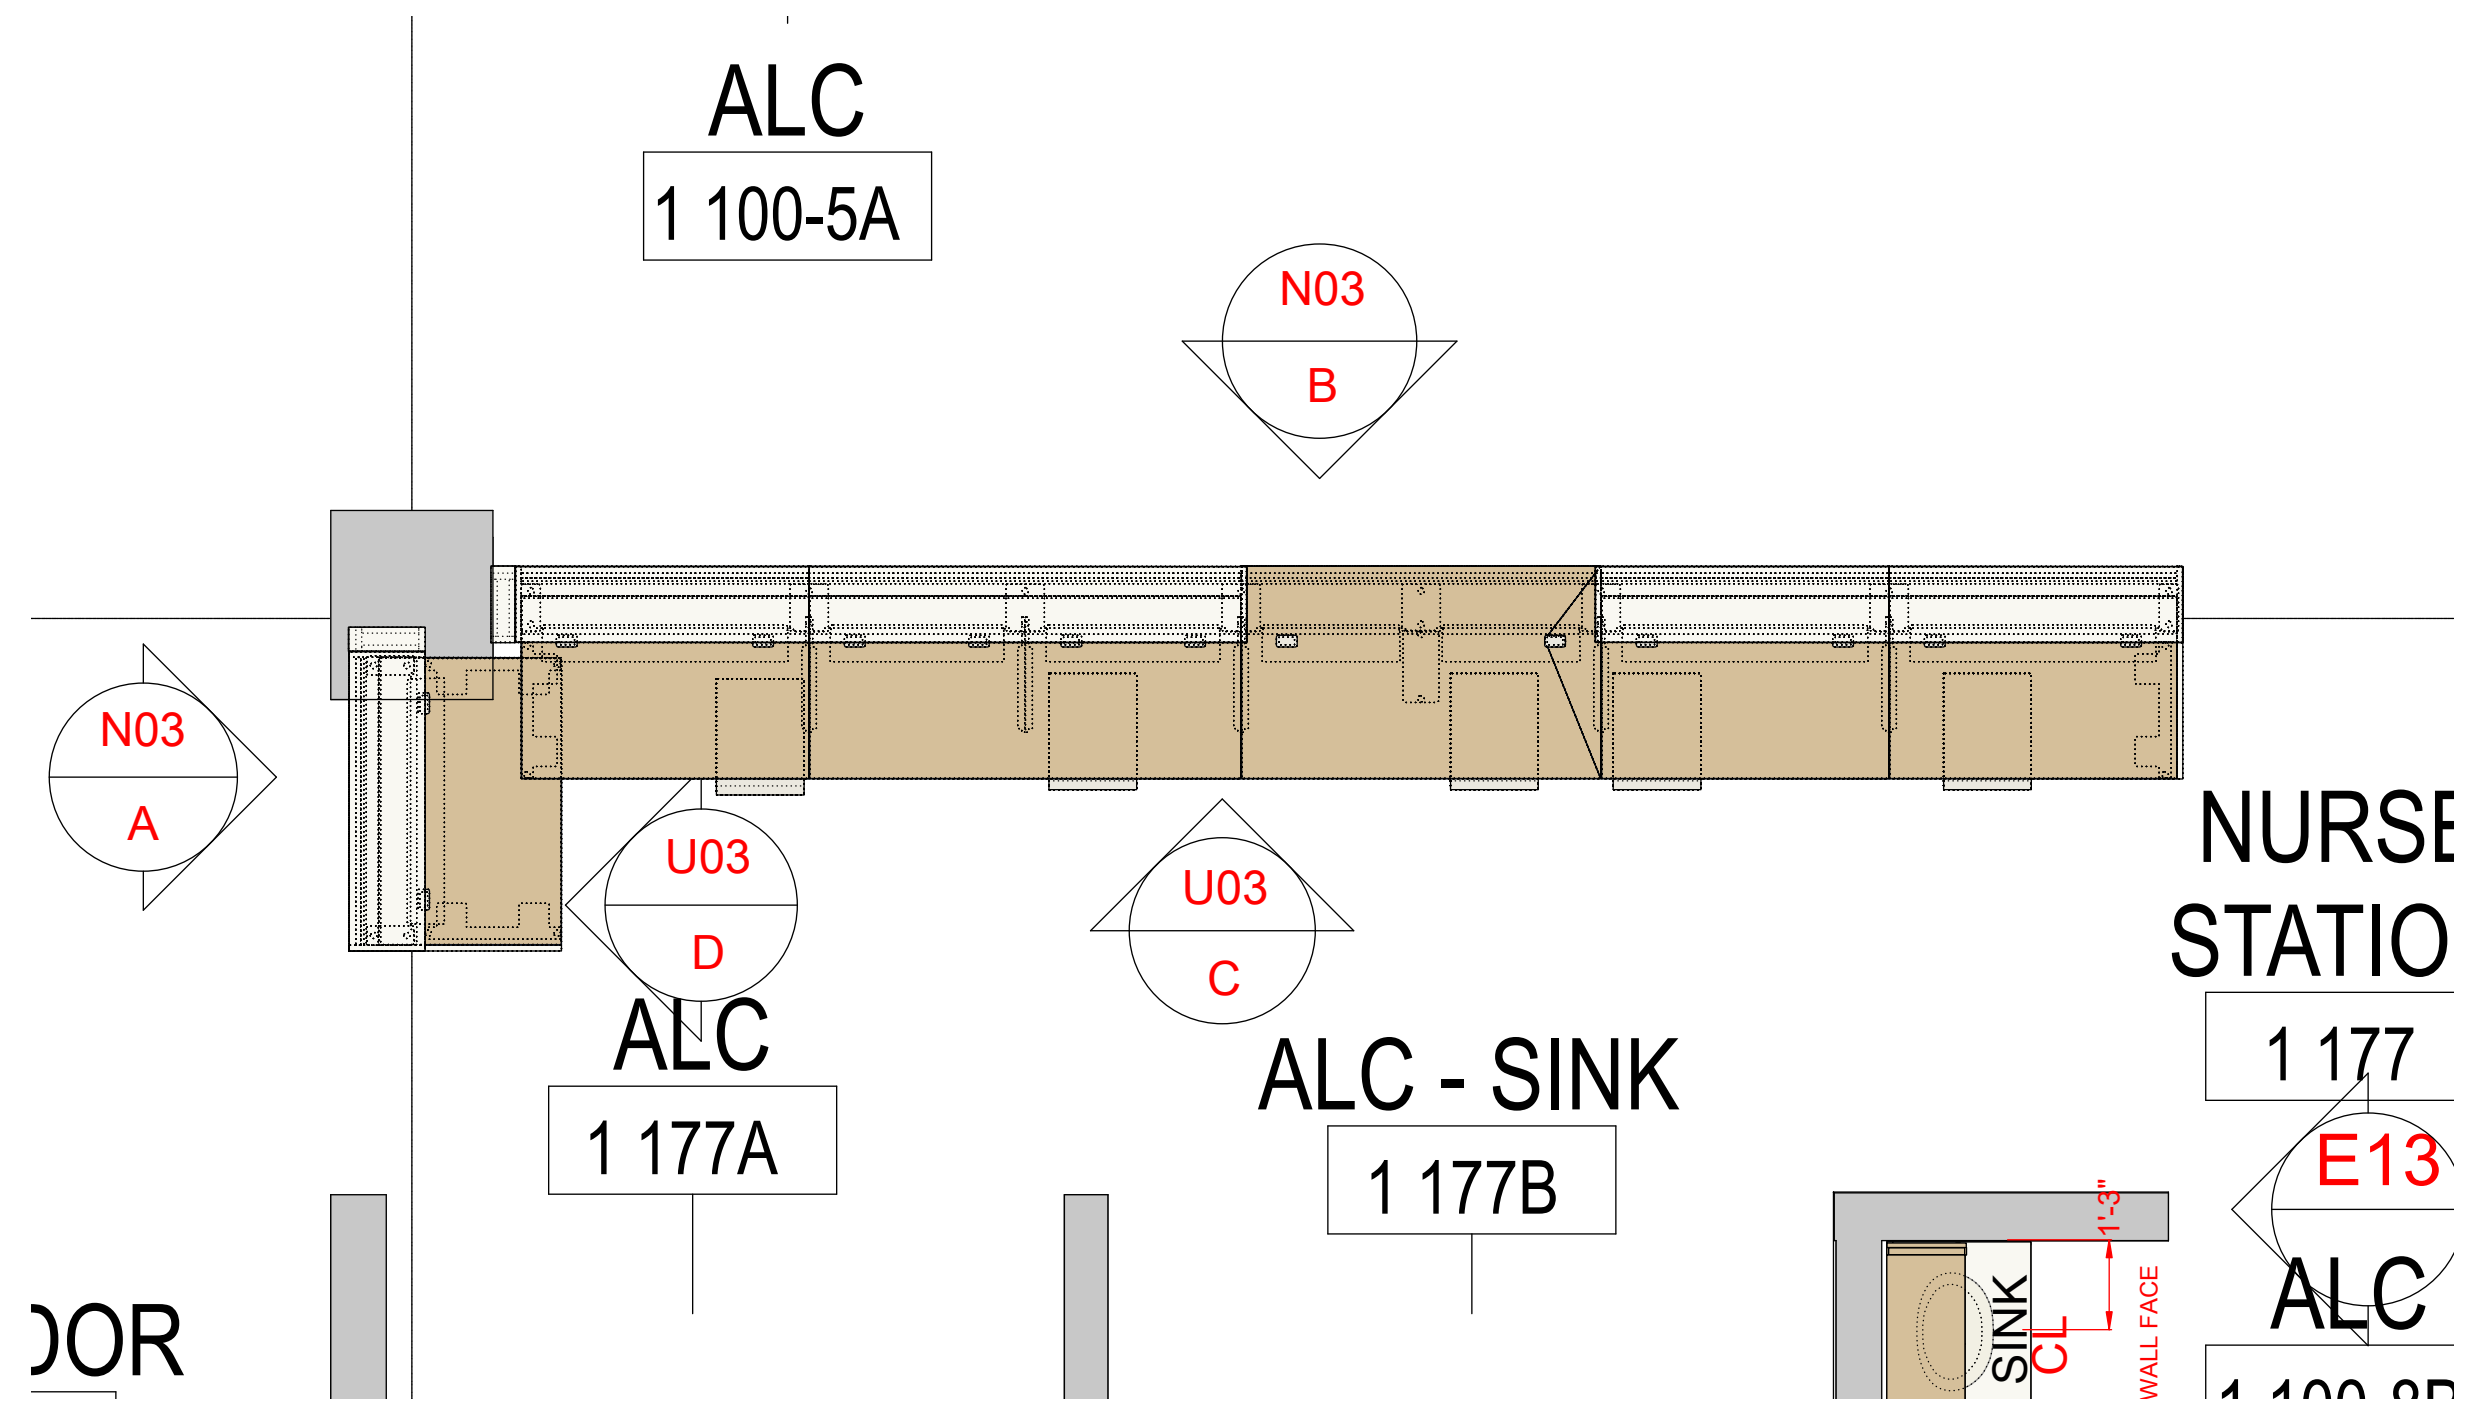


N3 NURSE STATION PLAN VIEW
SCALE: 3/8"=1"

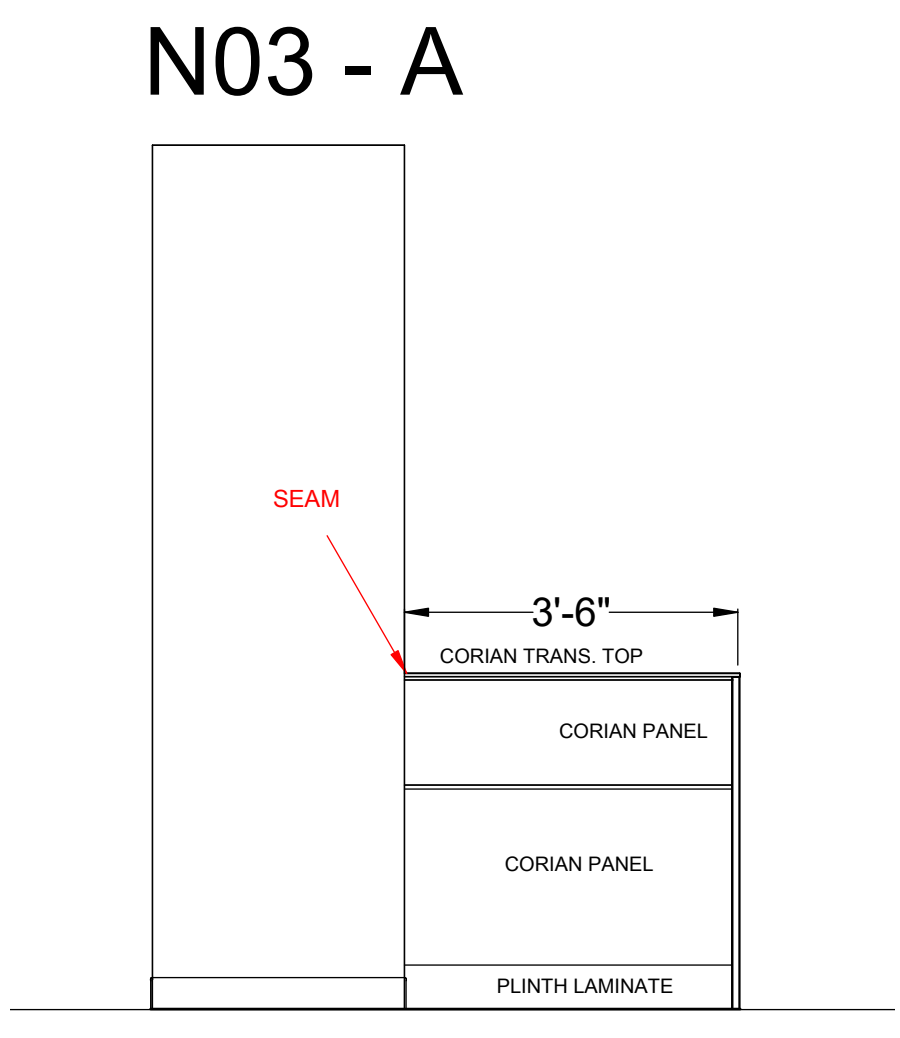


N3 NURSE STATION ELEVATION VIEW
SCALE: 1/2"=1"

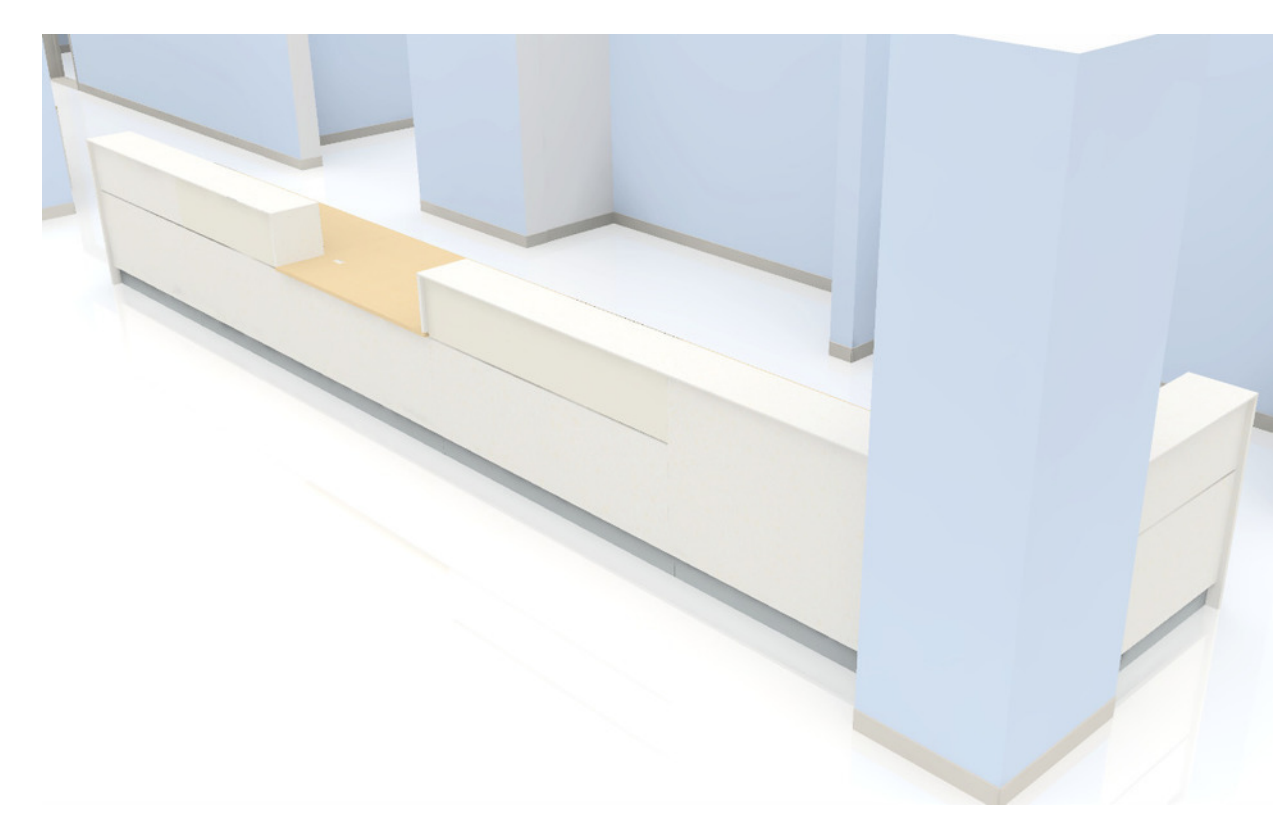


N3 NURSE STATION RENDERING
SCALE: NTS

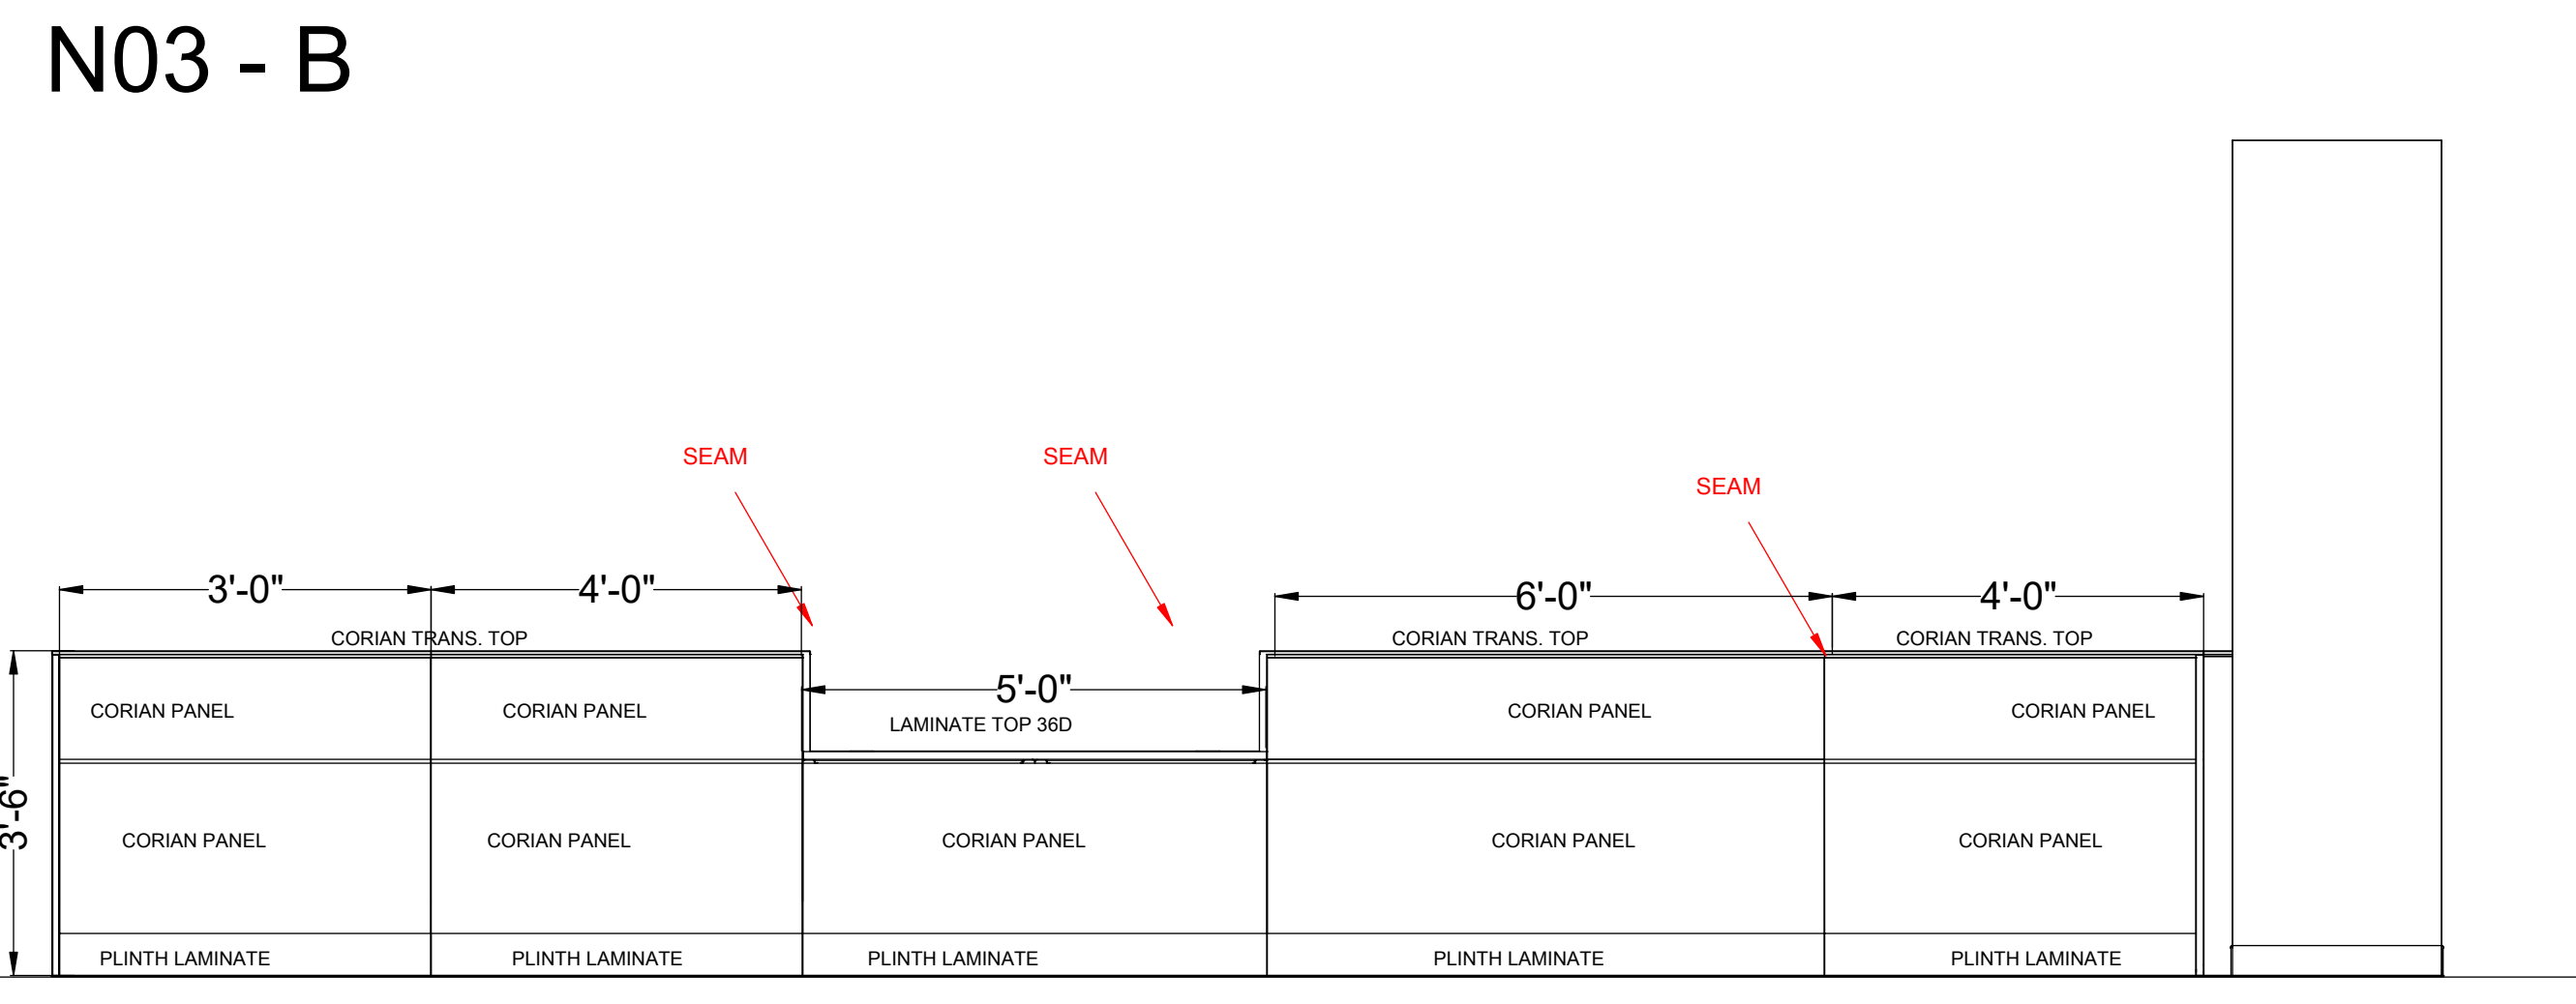

N3 NURSE STATION ELEVATION VIEW
SCALE: 1/2"=1"

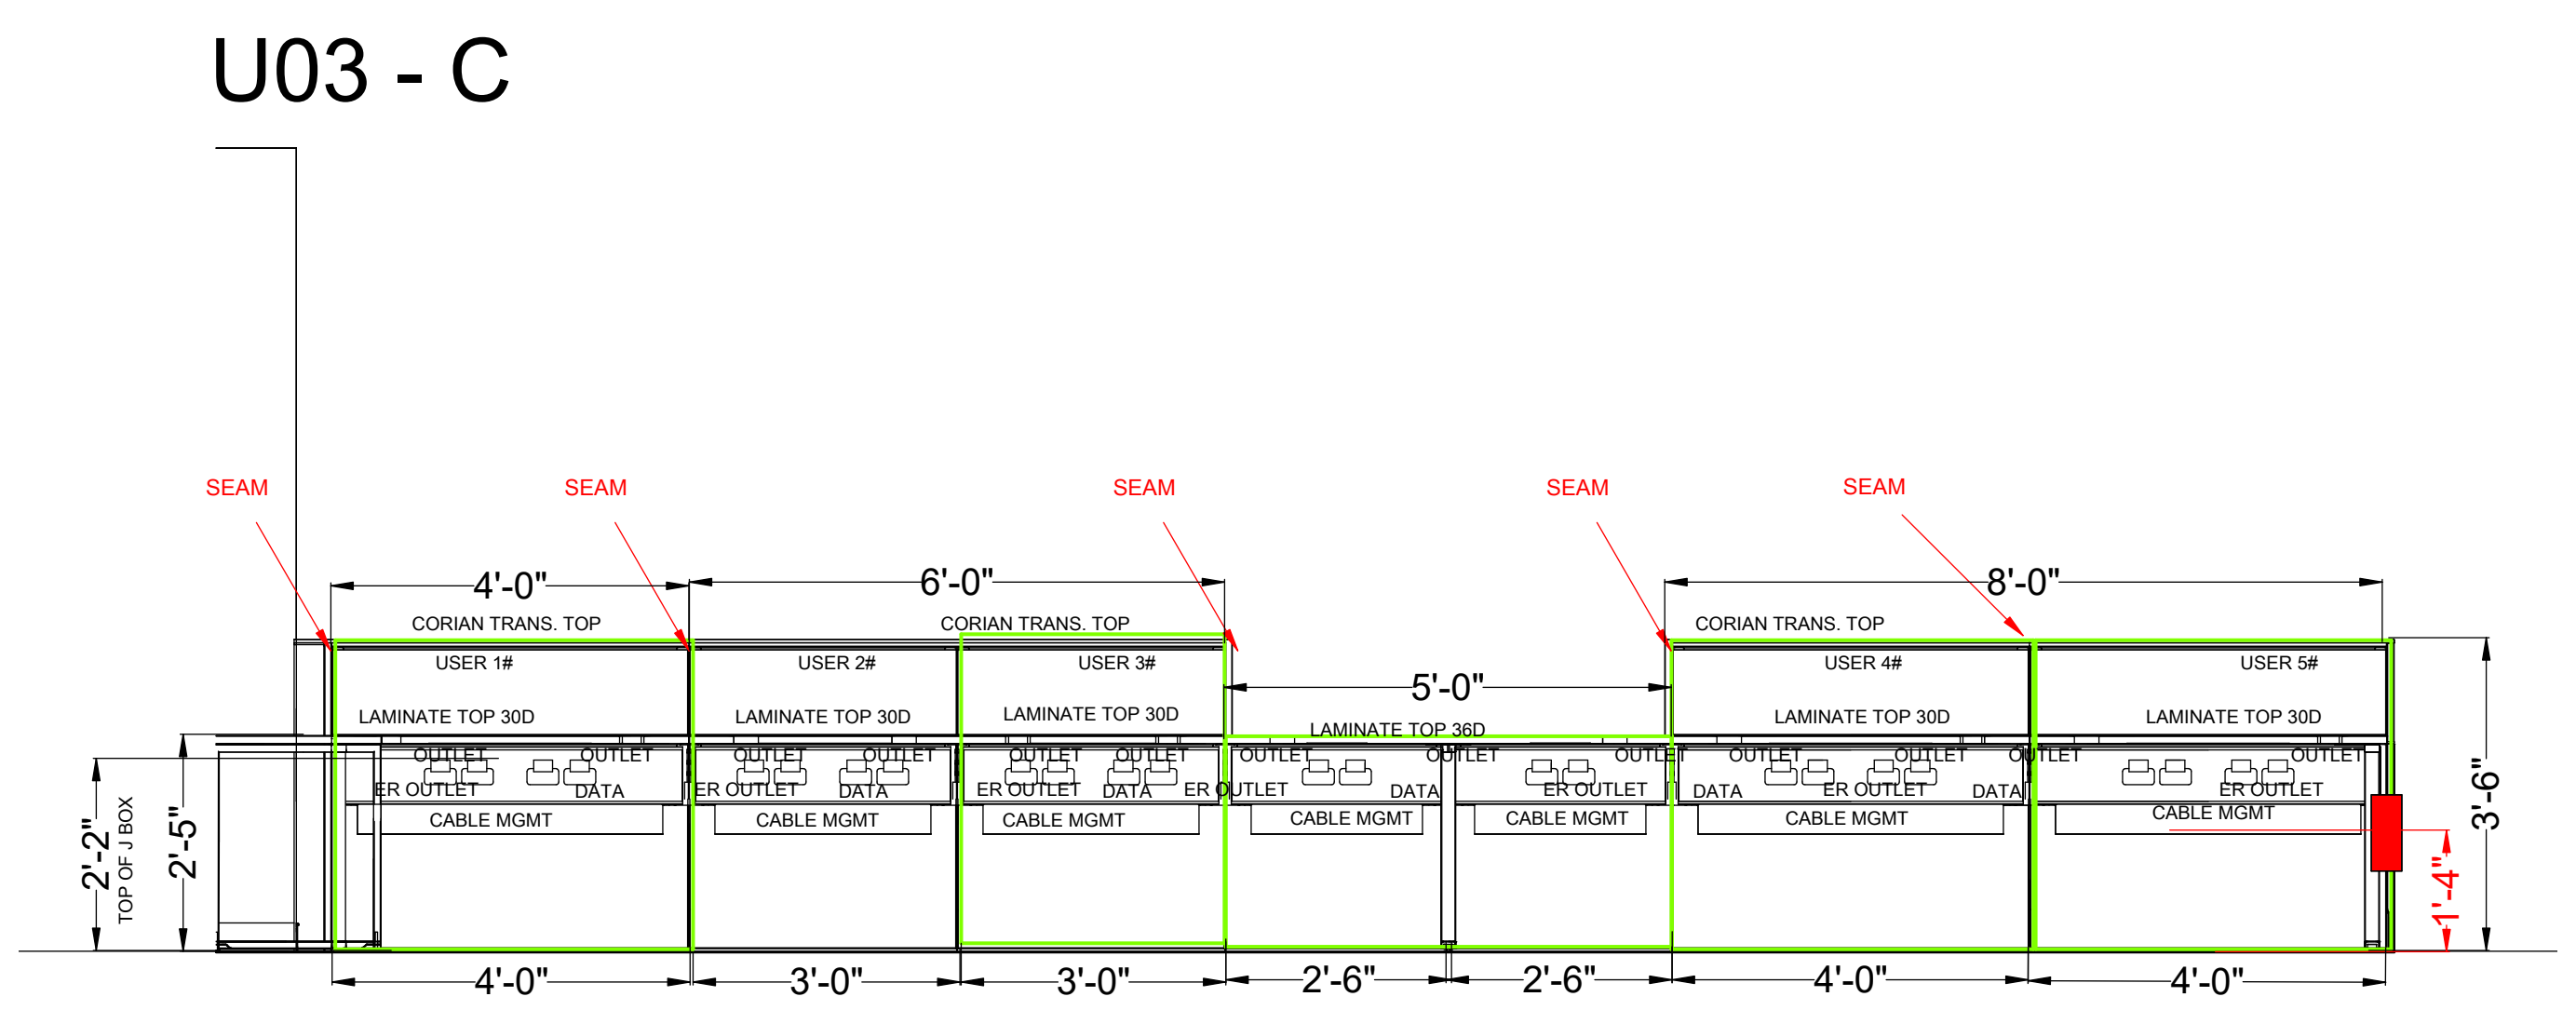


U3 NURSE STATION ELEVATION VIEW
SCALE: 1/2"=1"

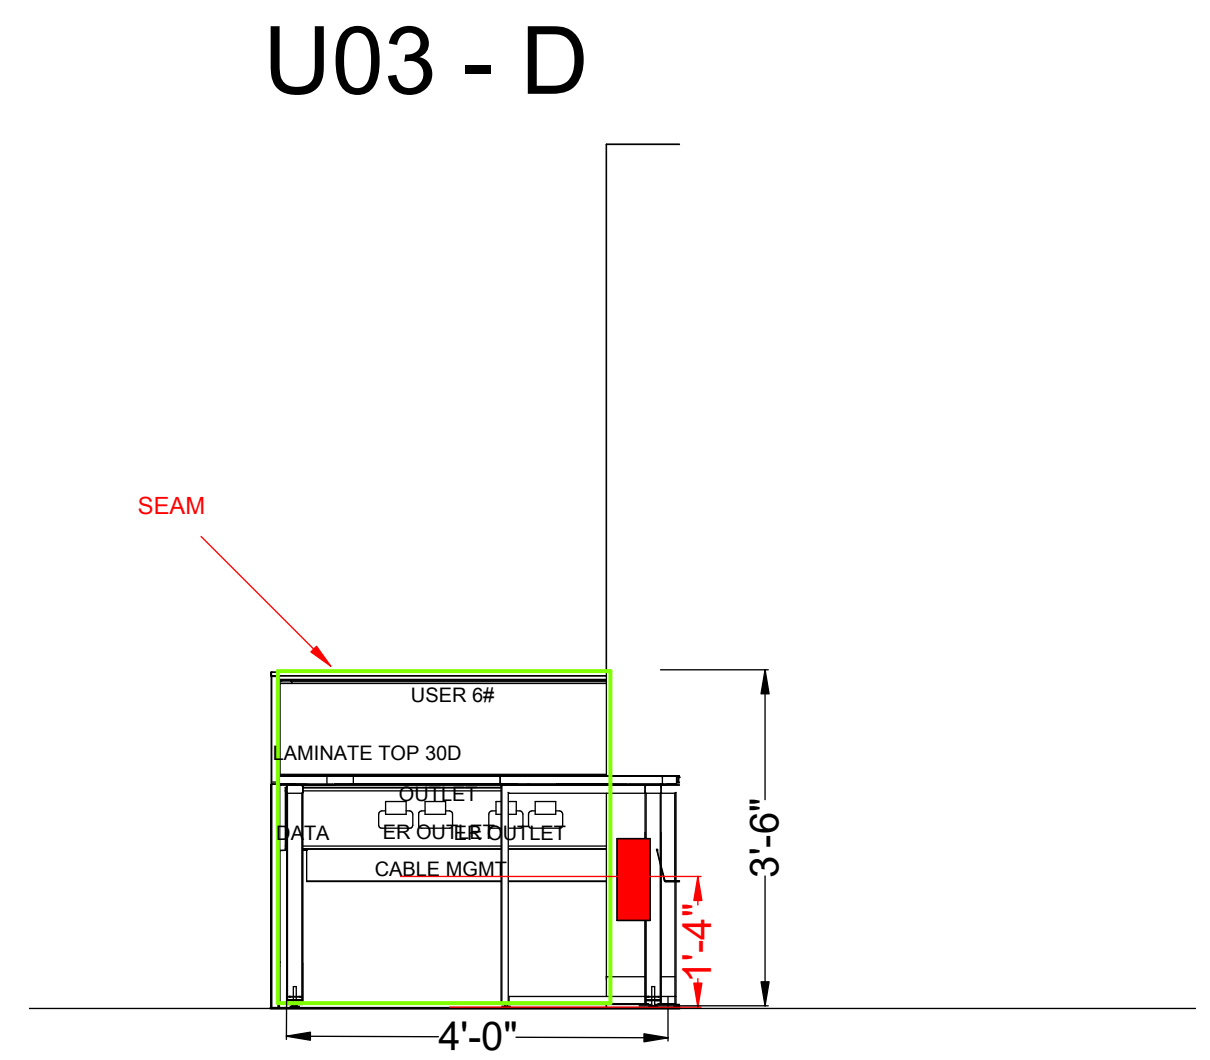

U3 NURSE STATION ELEVATION VIEW
SCALE: 1/2"=1"


CORRIDOR

1 100-5

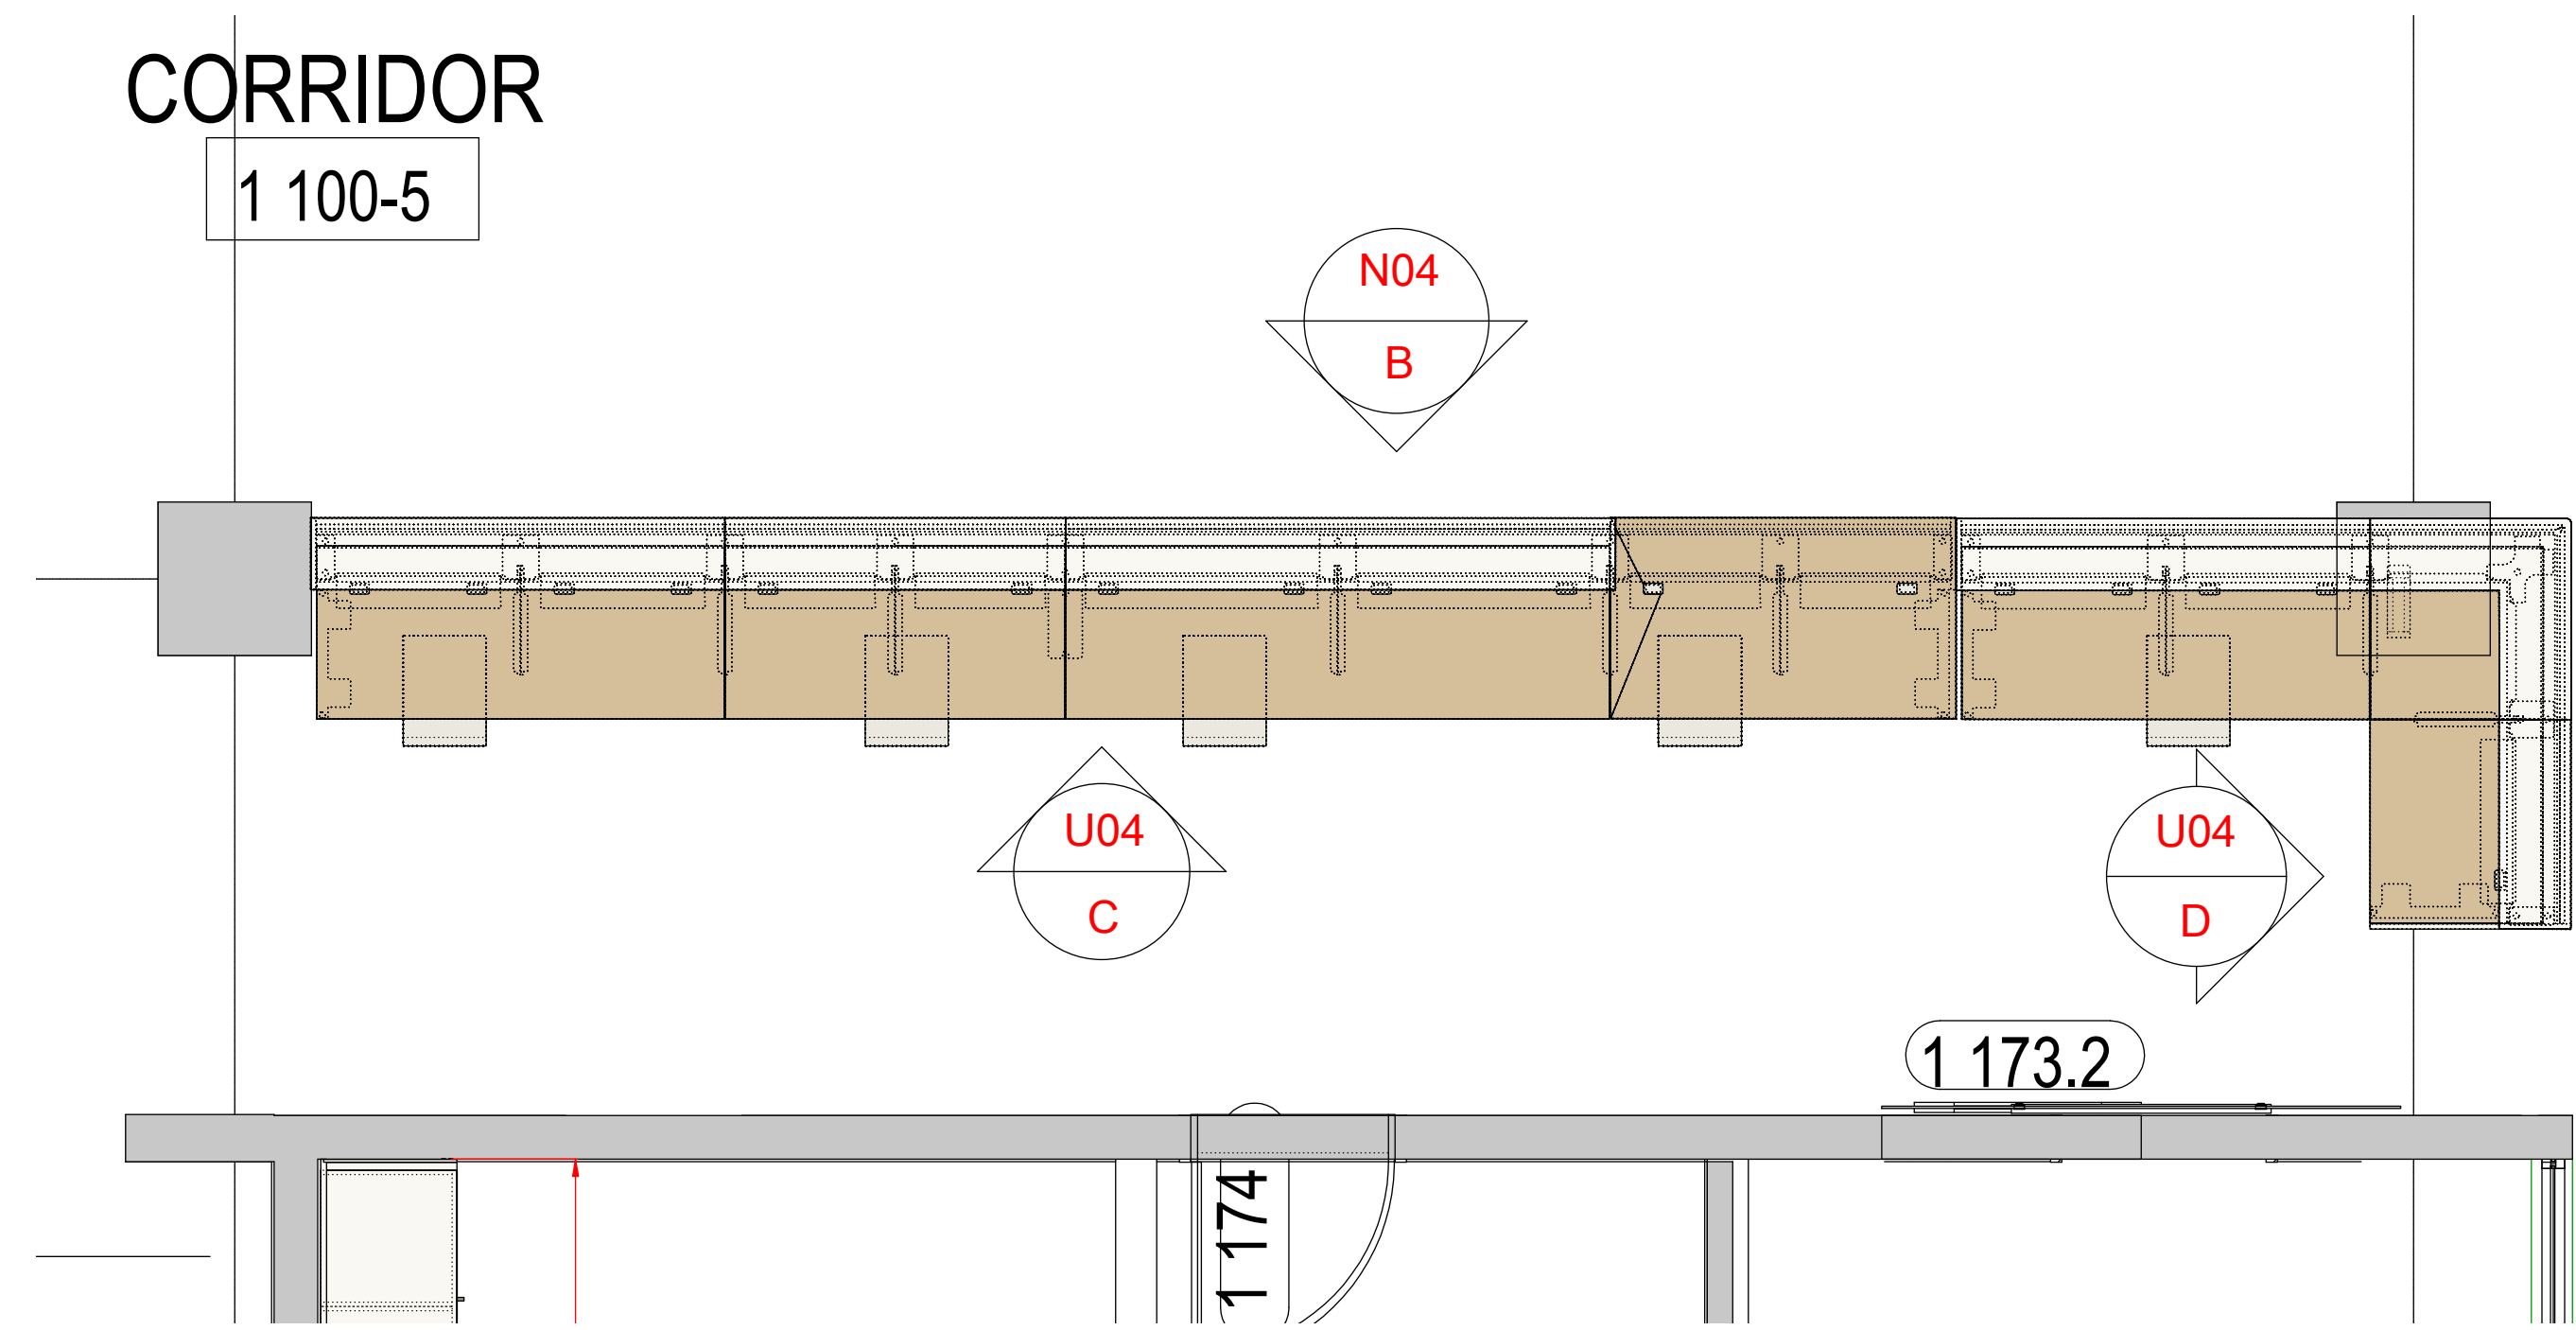


N4 NURSE STATION PLAN VIEW
SCALE: 3/8"=1"

N04 - A

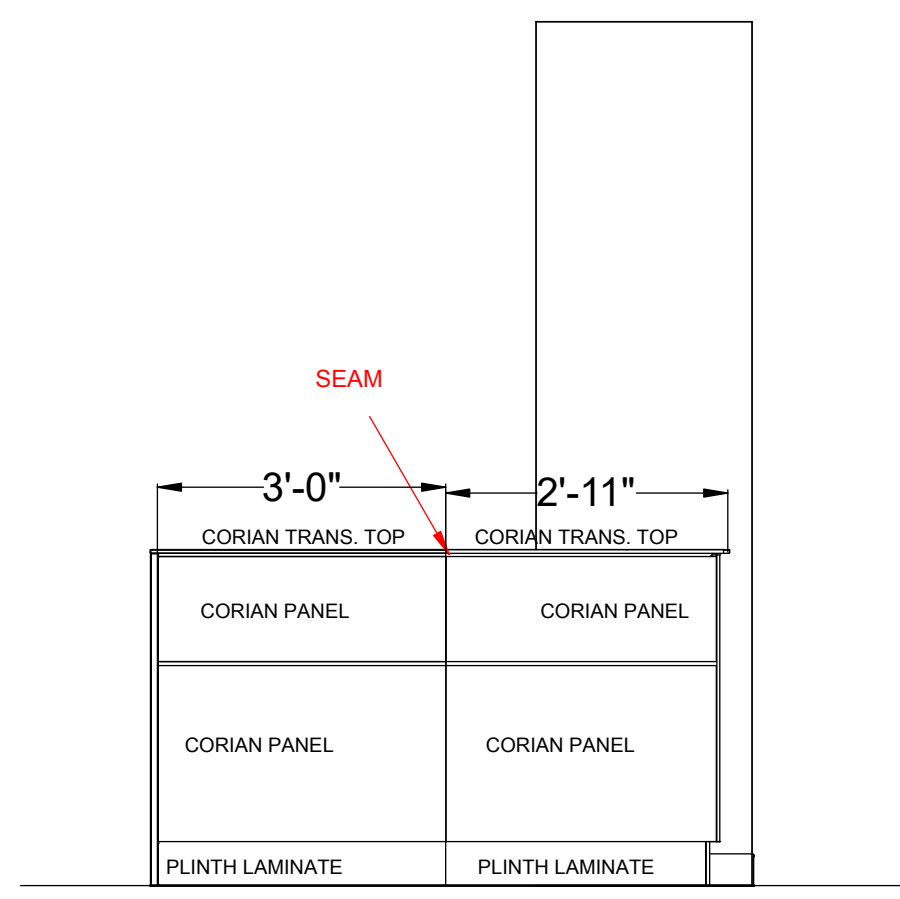


N2 NURSE STATION ELEVATION VIEW
SCALE: 1/2"=1"

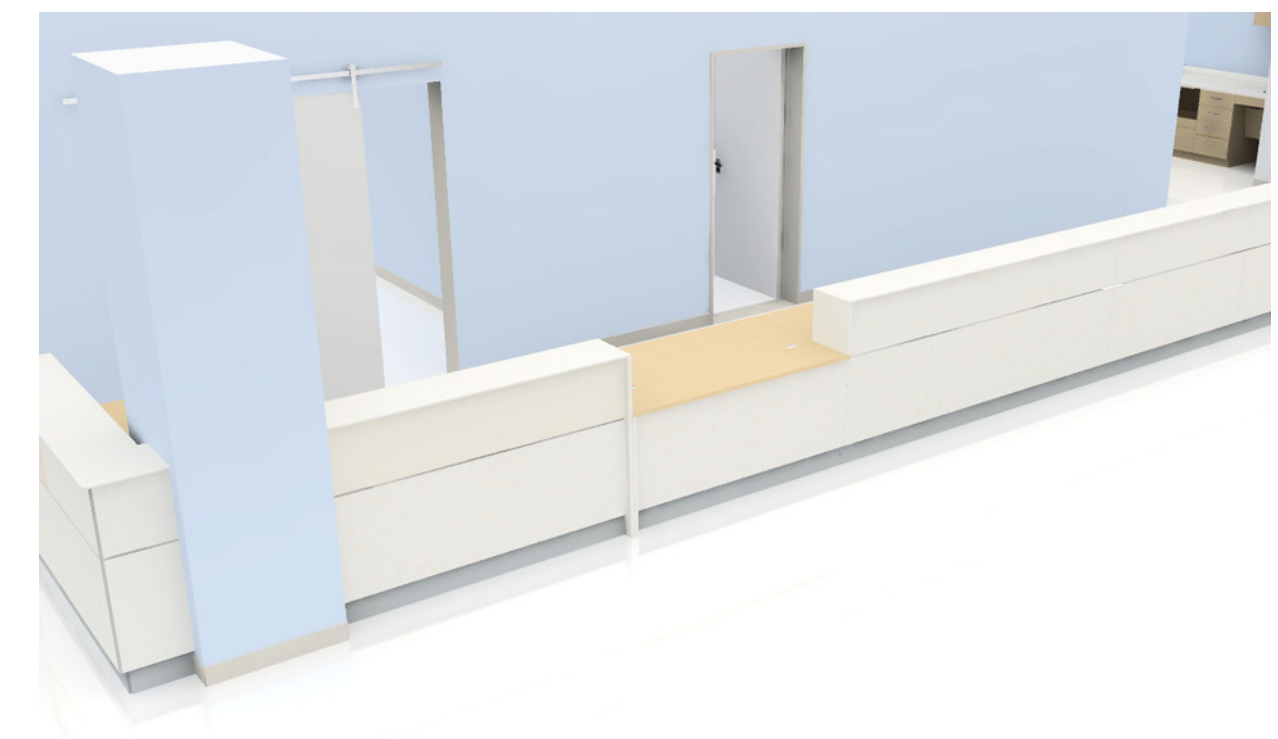


N4 NURSE STATION RENDERING
SCALE: NTS

N04 - B

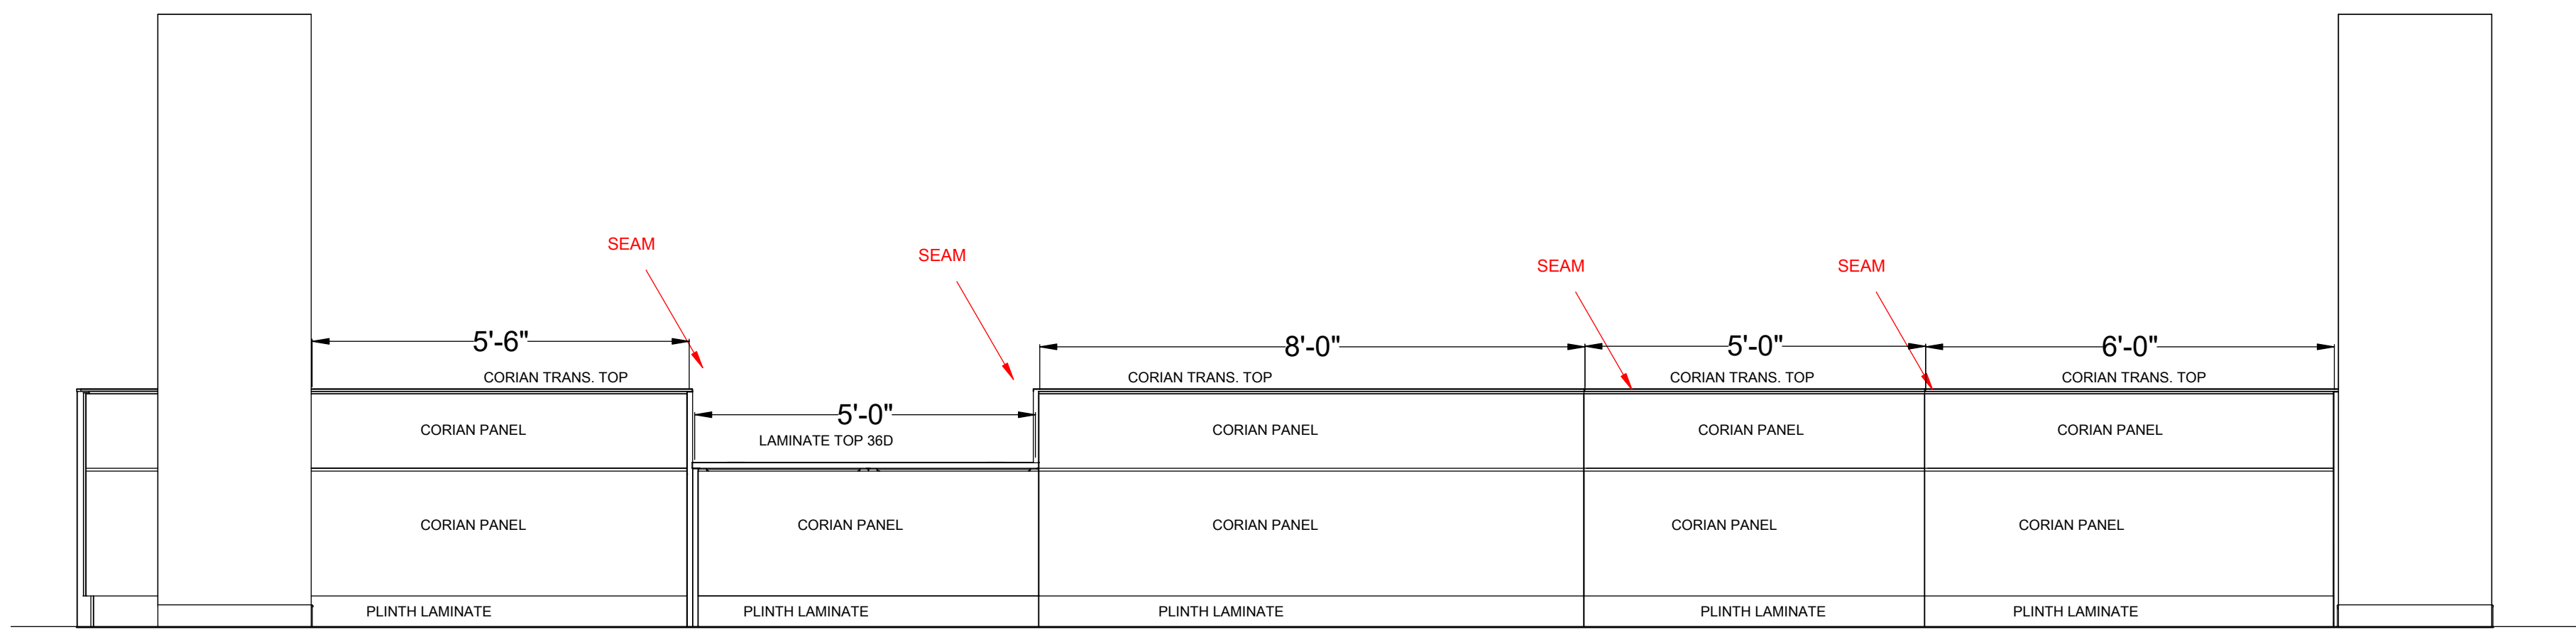


N4 NURSE STATION ELEVATION VIEW
SCALE: 1/2"=1"

U04 - C

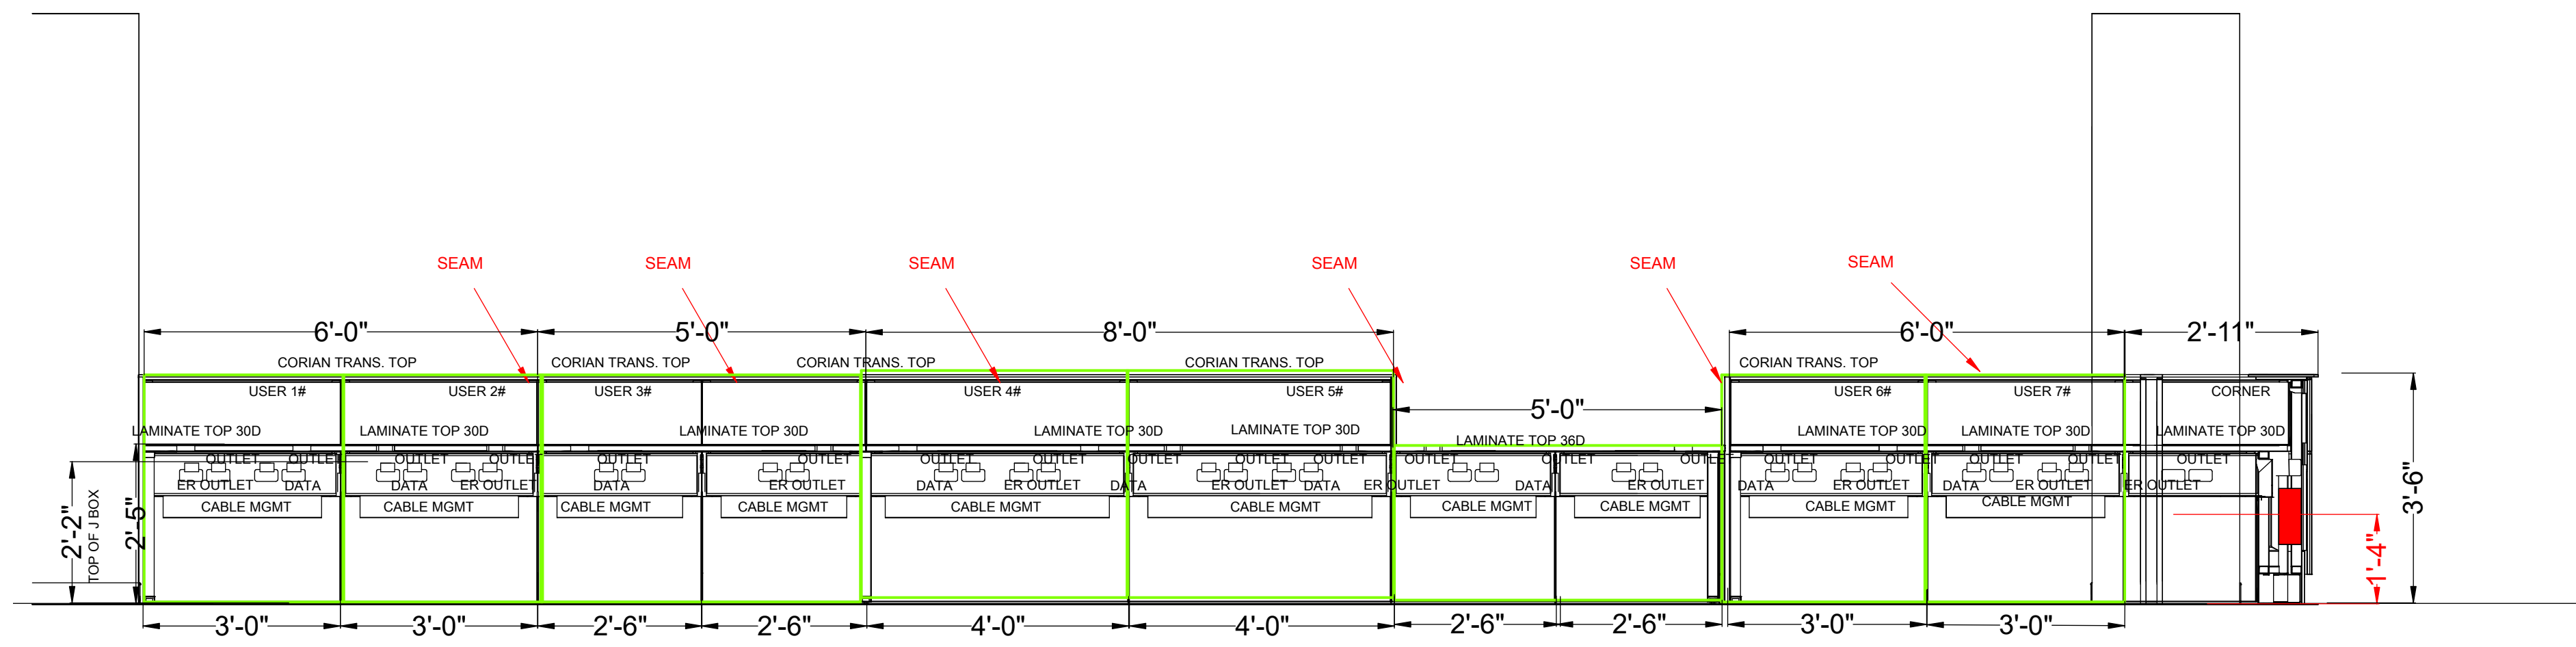

U4 NURSE STATION ELEVATION VIEW
SCALE: 1/2"=1"

U04 - D

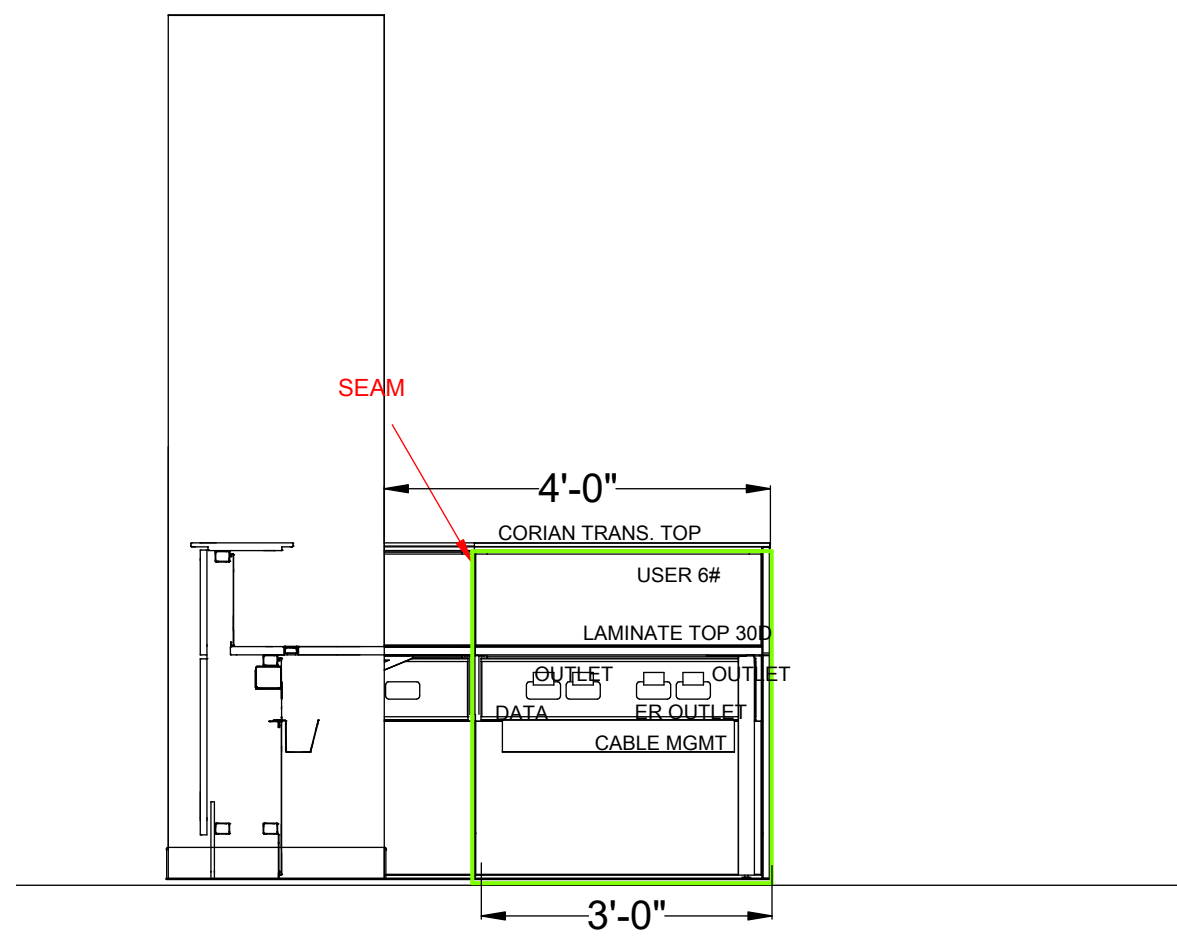

U4 NURSE STATION ELEVATION VIEW
SCALE: 1/2"=1"



workscapes
Tampa
501 E Kennedy Blvd
Suite 100
Tampa, FL 33602
813.620.0048
IC # 80001503

Facility Name: Orlando Health Melbourne Hospital
Project Name: Freestanding ER - Viera
OPC Project #: 23/23960034-19987

Melbourne Viera FSED
ORLANDO HEALTH
EXAM CASEWORK AND LAB
Lake Andrew Dr & Willet Place, Melbourne, FL 32940

Contractors/ Subcontractors to check and verify all dimensions on site prior to proceeding with the work.

This document and any associated materials are the sole property of Workscapes and are not for use other than to internally evaluate Workscapes' services. They are not to be disseminated, distributed, or otherwise conveyed to any third parties without the express written permission of Workscapes.


Project No.: 89853
Sheet Size: 24X36
Scale: SEE PLAN
Designer: K.COTTRELL
Location: TAMPA, FL
Date: 3/2/2026
Signed:

Revisions:
02-17-2026_R1.ADD.FILLER
03-02-2026_R2.ADJ.SCOPE
date.....
date.....
date.....
date.....
date.....


This drawing is intended to indicate furniture location and configuration only and is not to be used permitting or construction.

For exact architectural configurations, refer to architectural contract documents prepared by others.

Sheet:

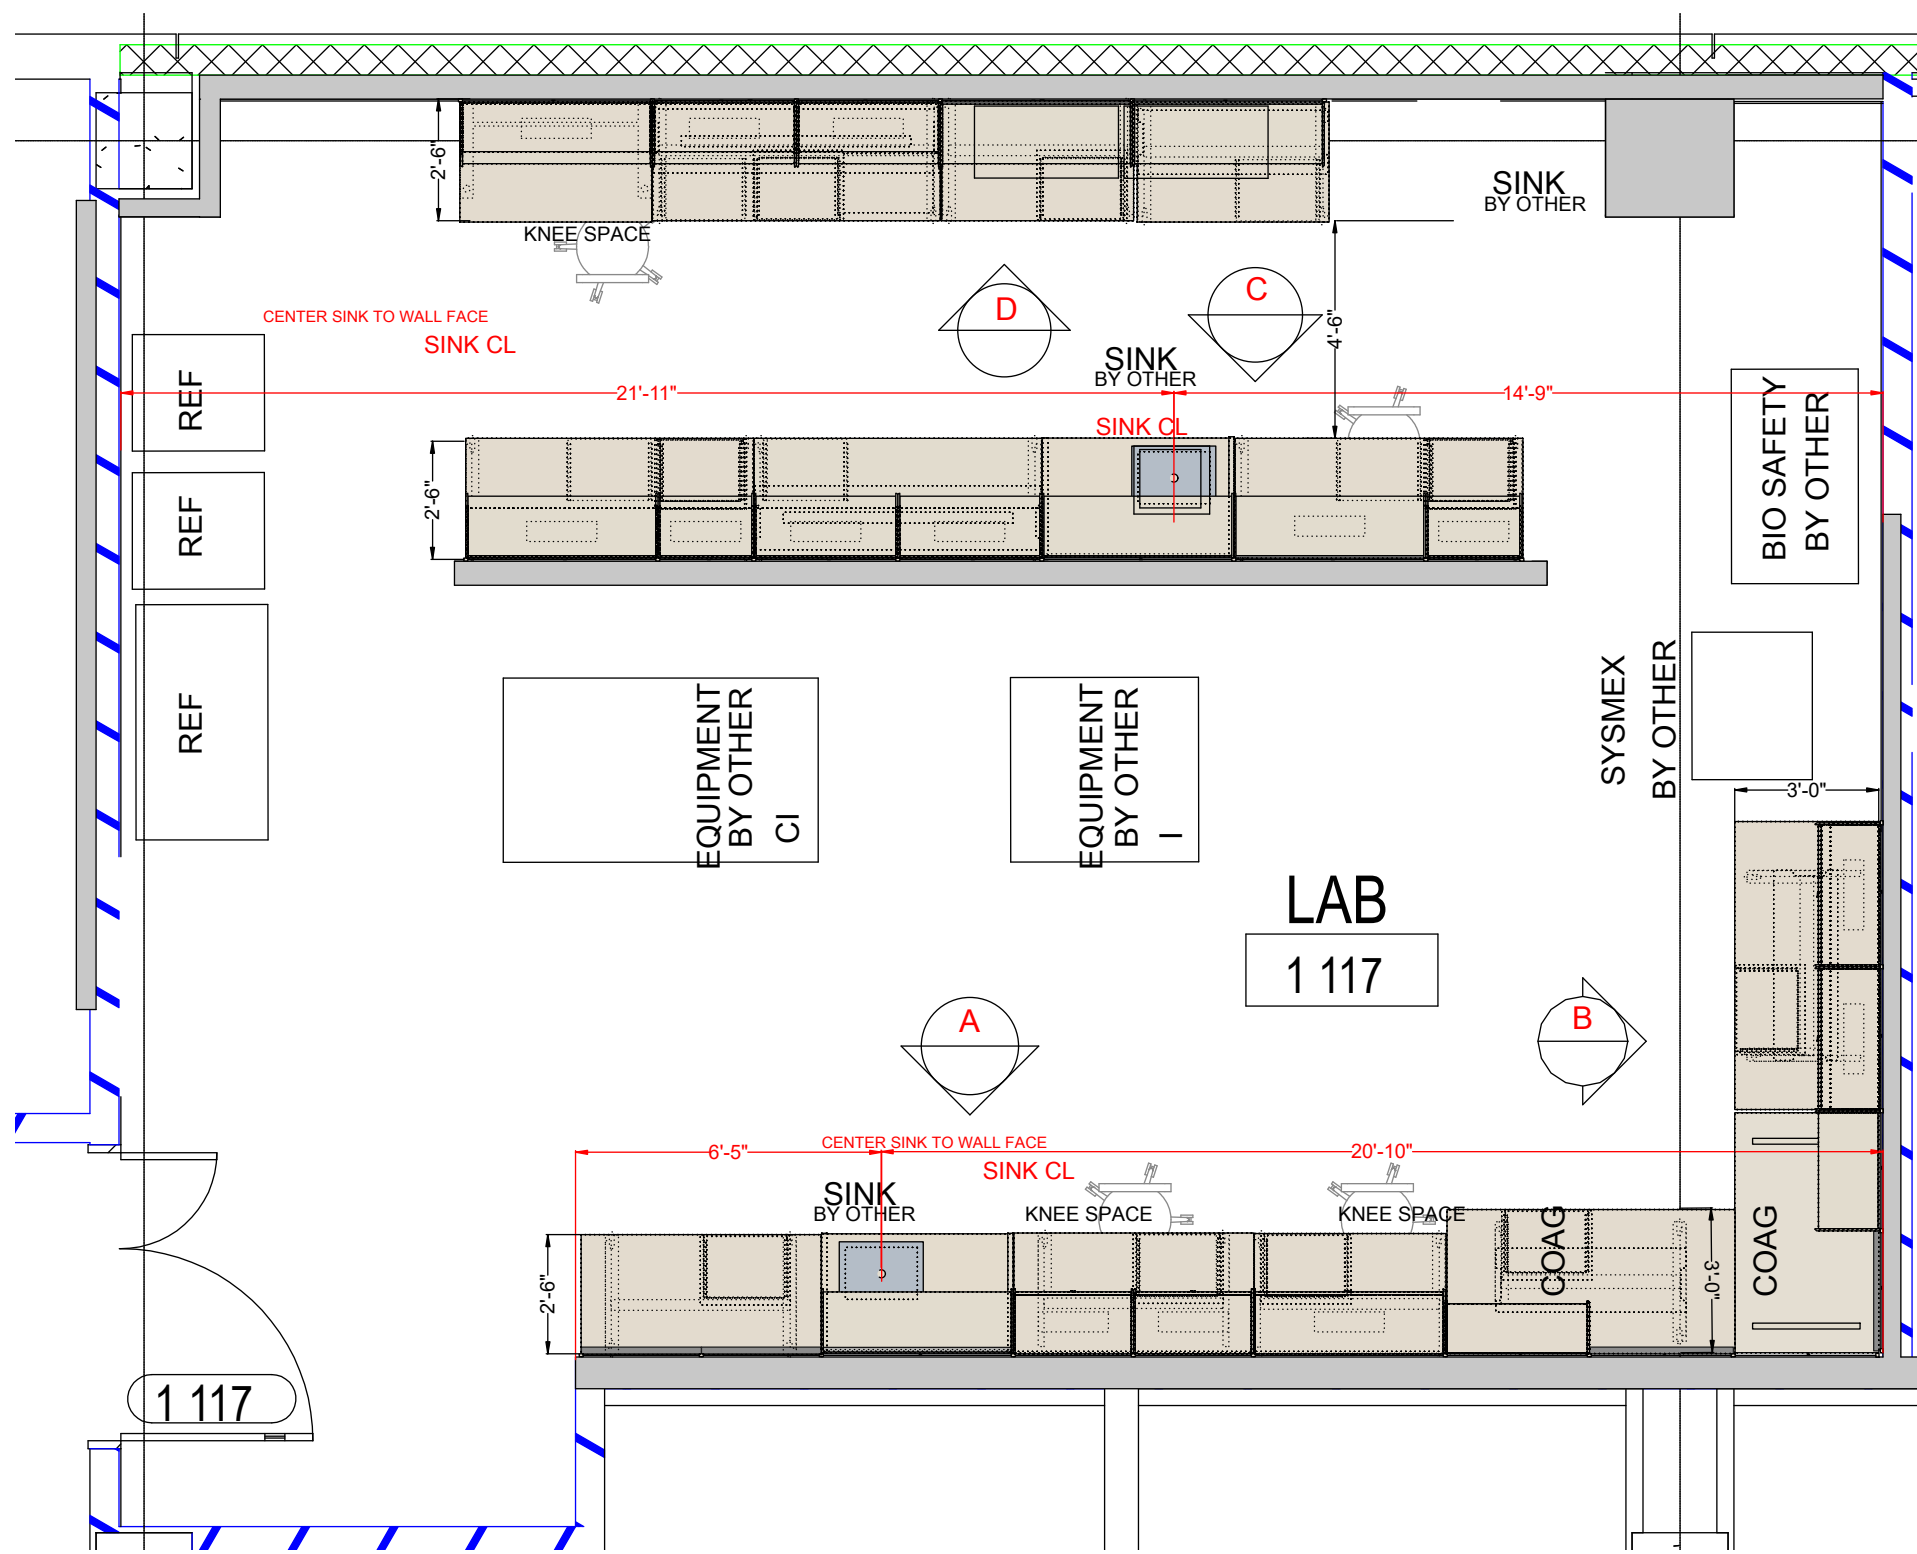

L LAB PLAN VIEW
SCALE: 1/4"=1'

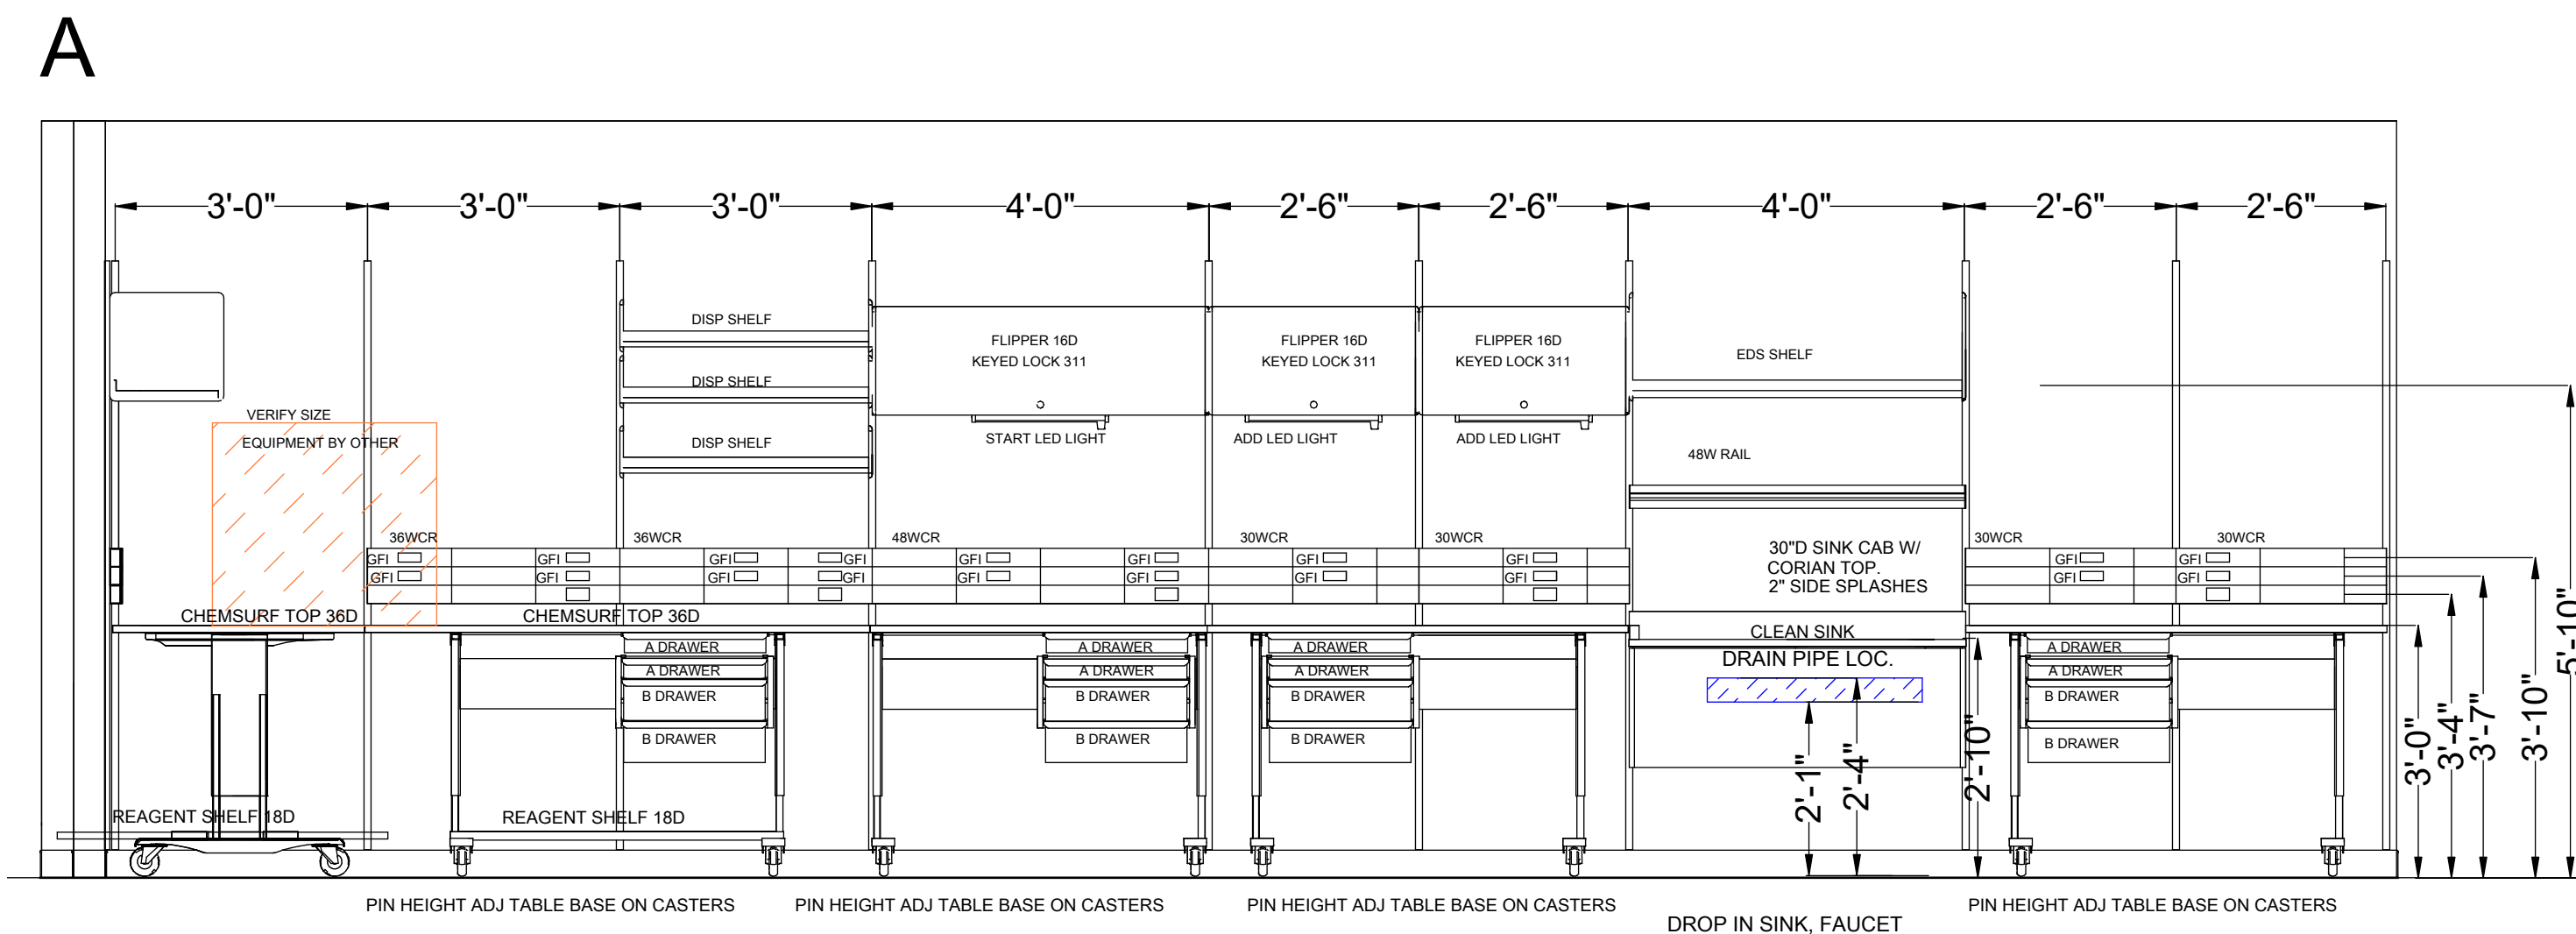

A LAB ELEVATION VIEW
SCALE: 1/2"=1'


REFERENCE THE ELECTRICAL DRAWINGS FOR ALL CIRCUITING

POWER ENTRY FROM WALL

SEE DETAILS SHEET FOR INFED HEIGHTS

WIRE CHASE RAIL - 3 CHANNELS
1. REGULAR POWER
2. EMERGENCY POWER
3. LOW VOLTAGE/DATA


TOP OF WIRE CHASE RAIL - 47\"

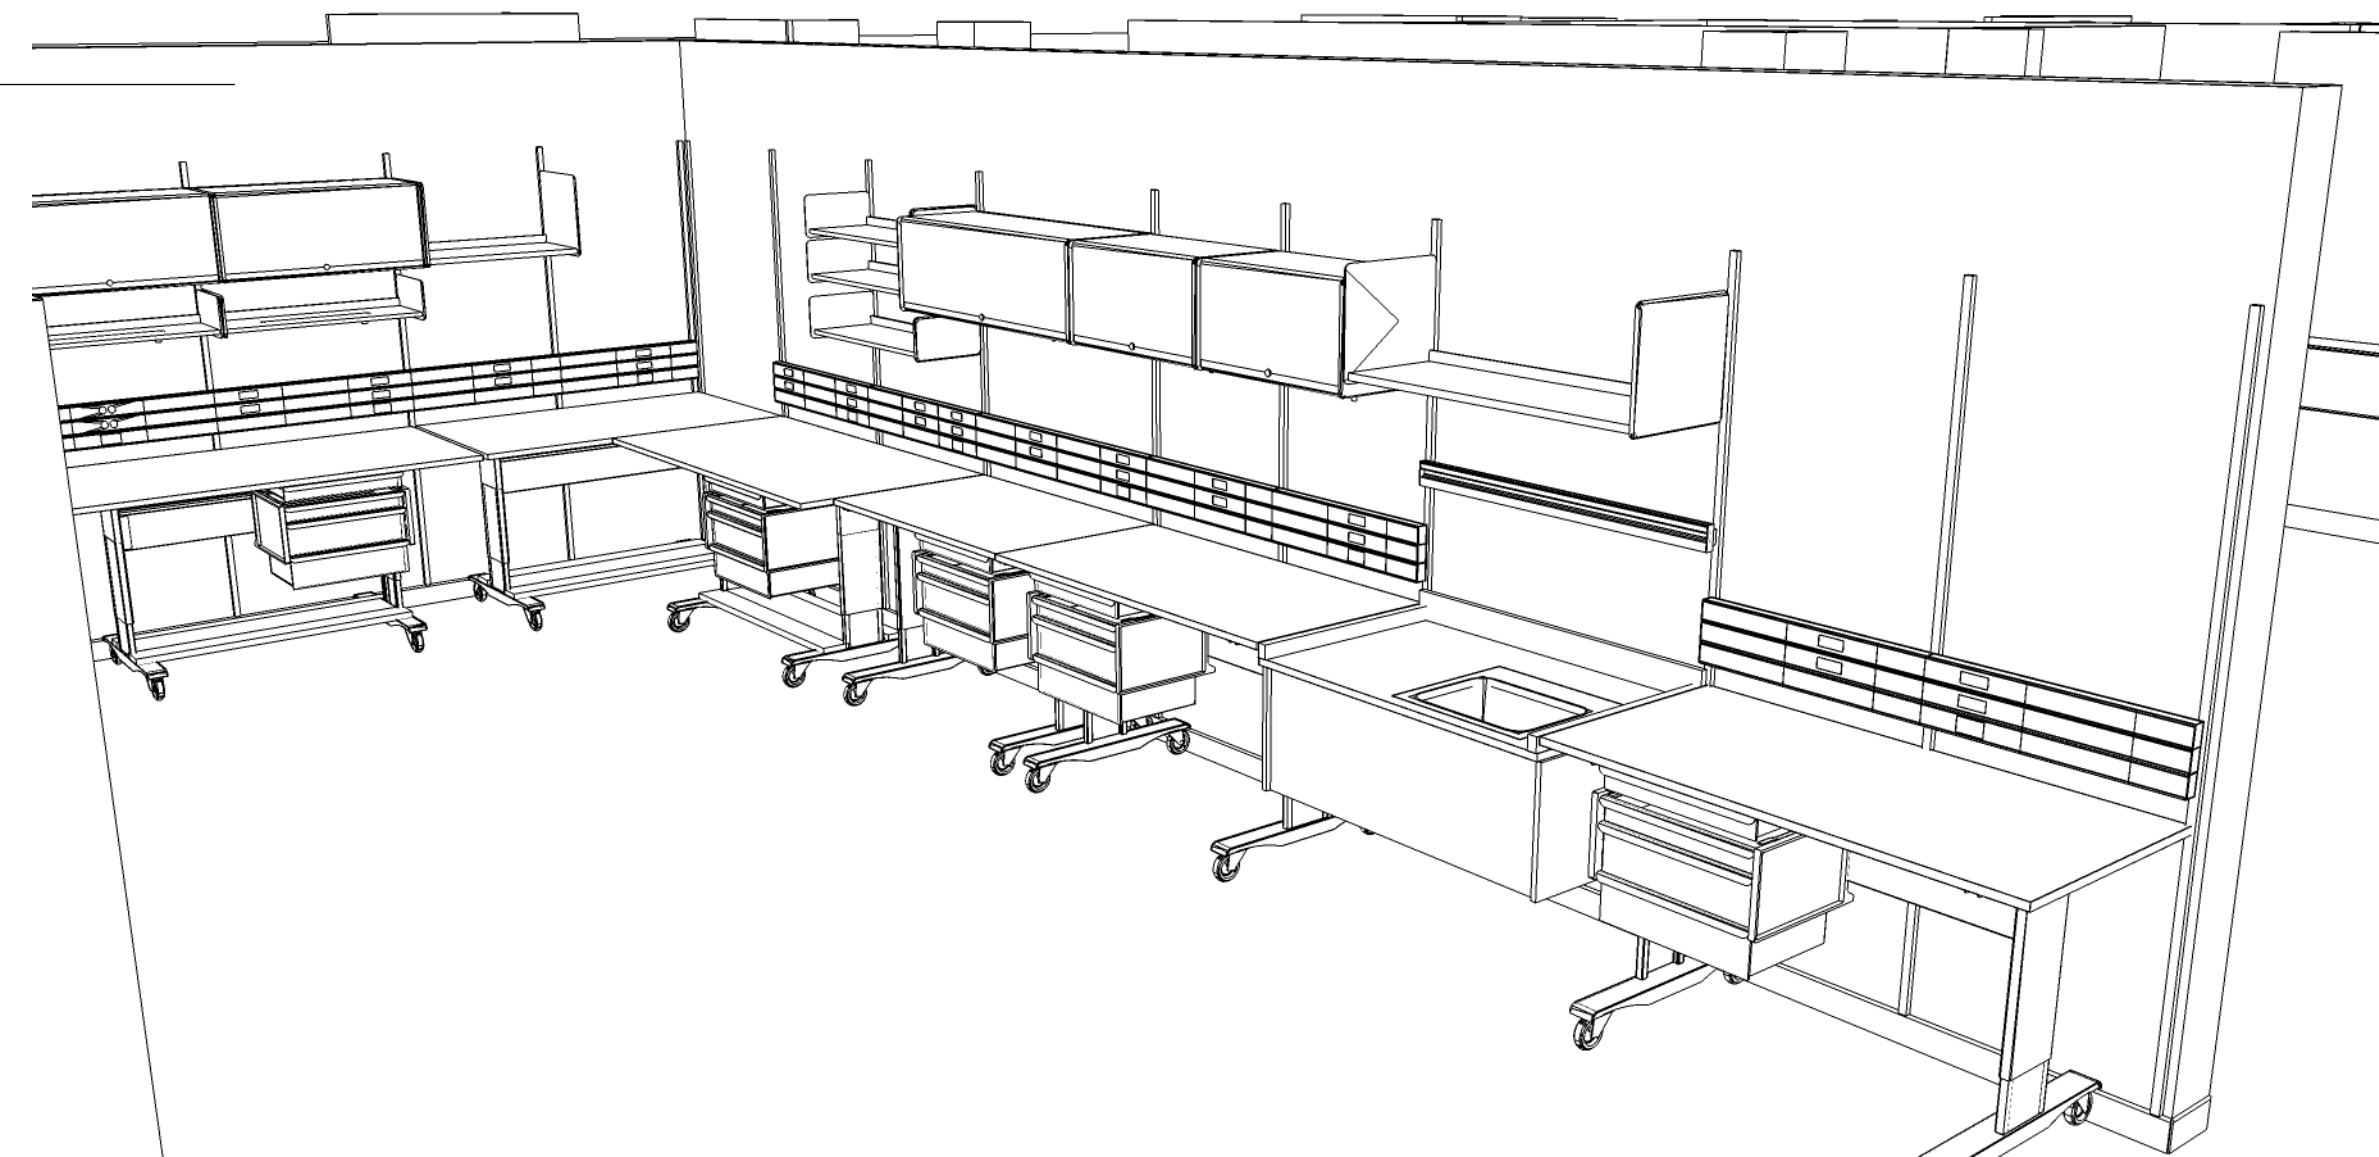


A LAB ISOMETRIC VIEW
SCALE: NTS



A LAB RENDERING
SCALE: NTS

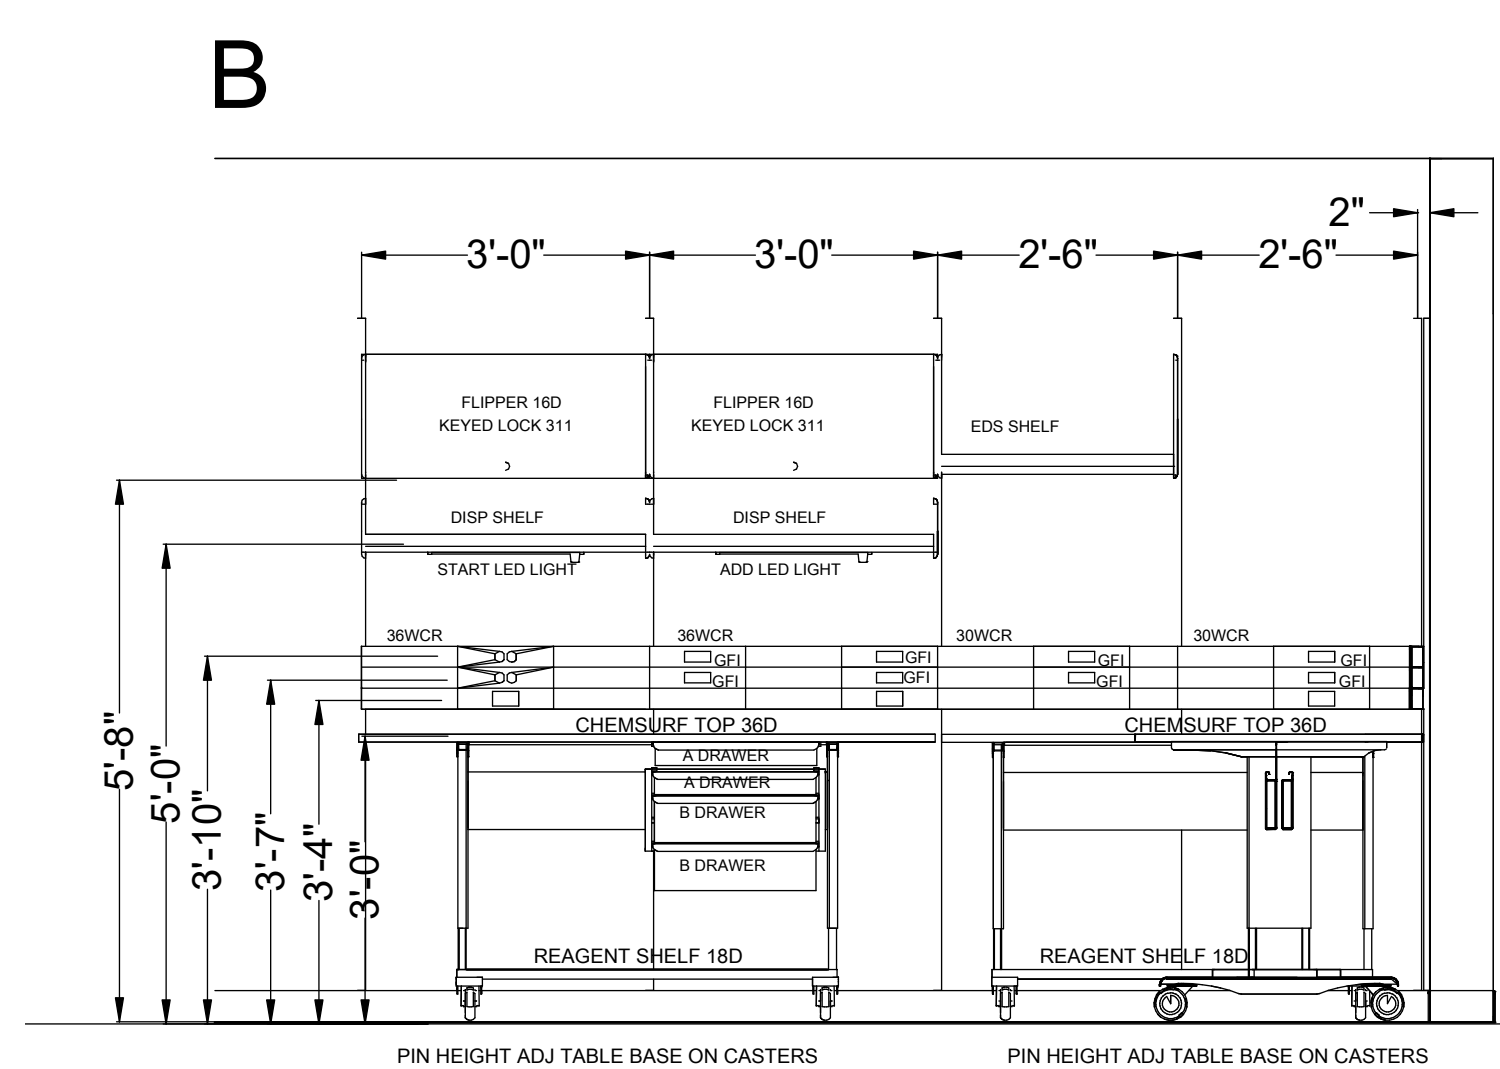

B LAB ELEVATION VIEW
SCALE: 1/2"=1'

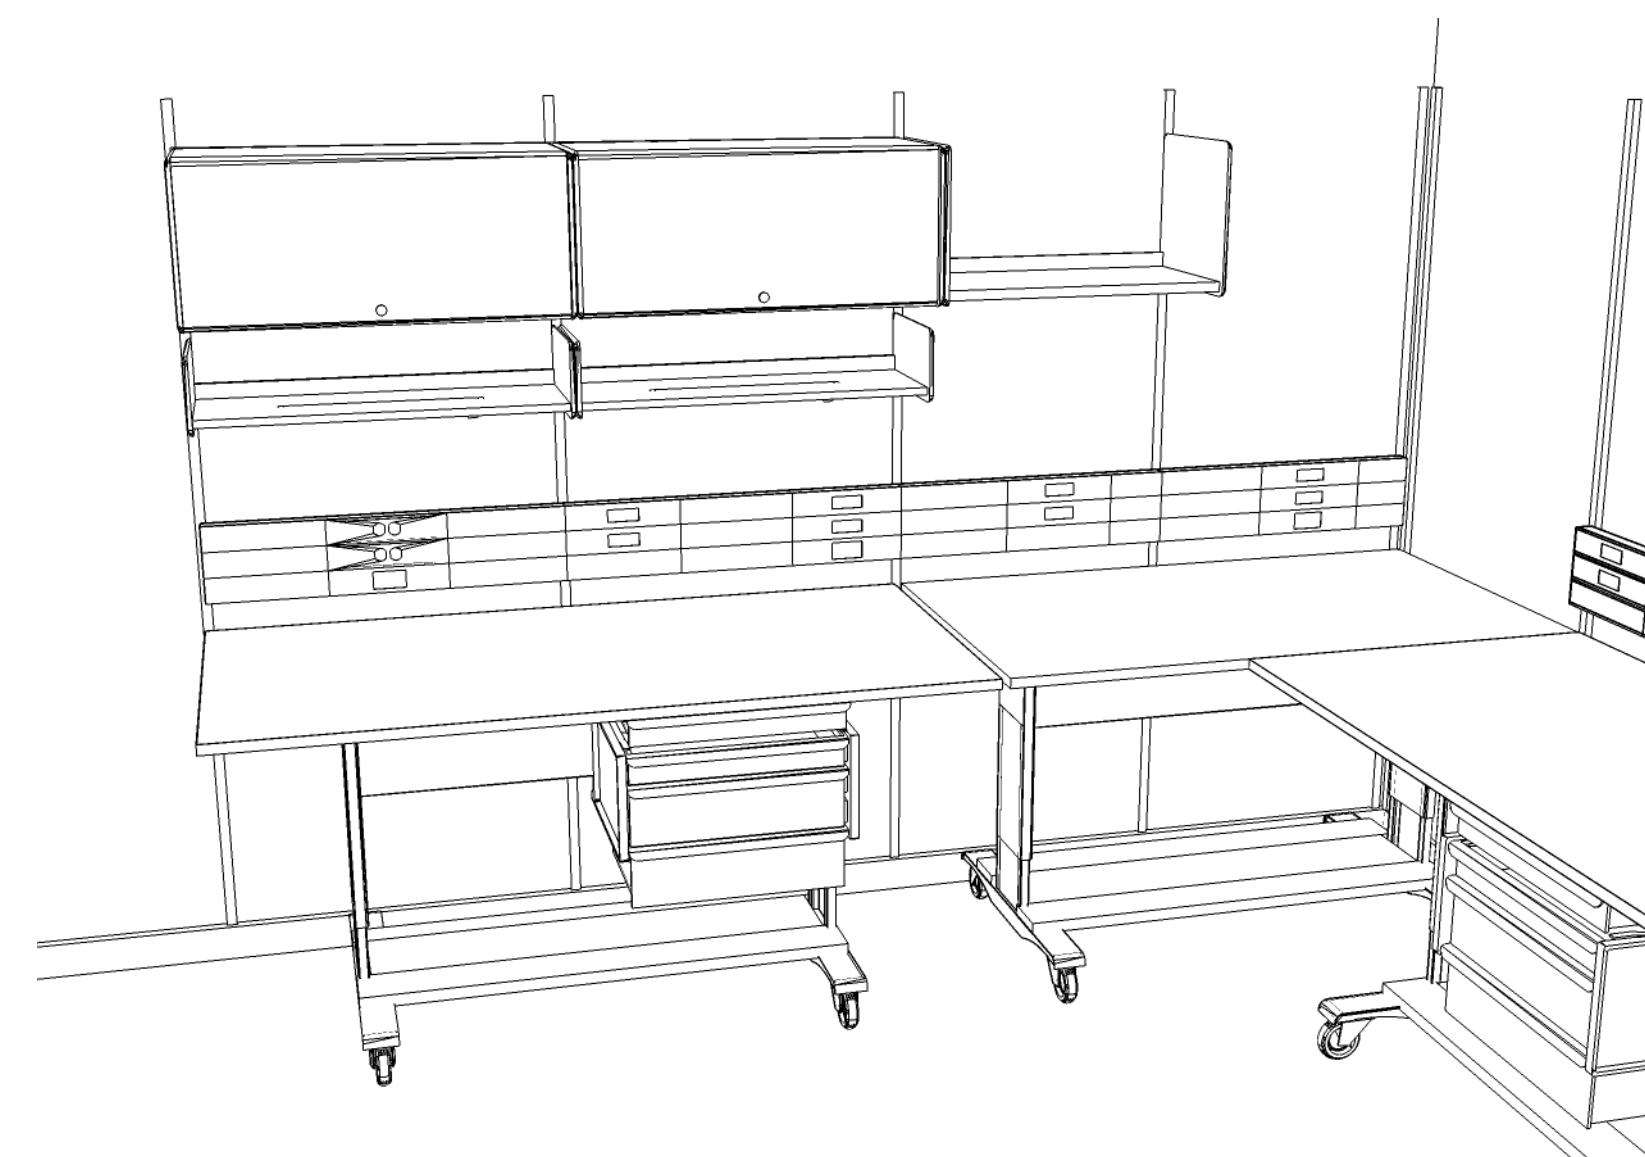

B LAB ISOMETRIC VIEW
SCALE: NTS



B LAB RENDERING
SCALE: NTS

Contractors/ Subcontractors to check and verify all dimensions on site prior to proceeding with the work.

This document and any associated materials are the sole property of Worksapces and are not for use other than to internally evaluate Worksapces' services. They are not to be disseminated, distributed, or otherwise conveyed to any third parties without the express written permission of Worksapces.

Project No.: 89853

Sheet Size: 24X36

Scale: SEE PLAN

Designer: K.COTTRELL

Location: TAMPA, FL

Date: 3/2/2026

Signed:


Revisions:

02-17-2026	R1	ADD FILLER
03-02-2026	R2	ADJ SCOPE
date		
date		
date		
date		
date		


This drawing is intended to indicate furniture location and configuration only and is not to be used permitting or construction.

For exact architectural configurations, refer to architectural contract documents prepared by others.

Sheet:

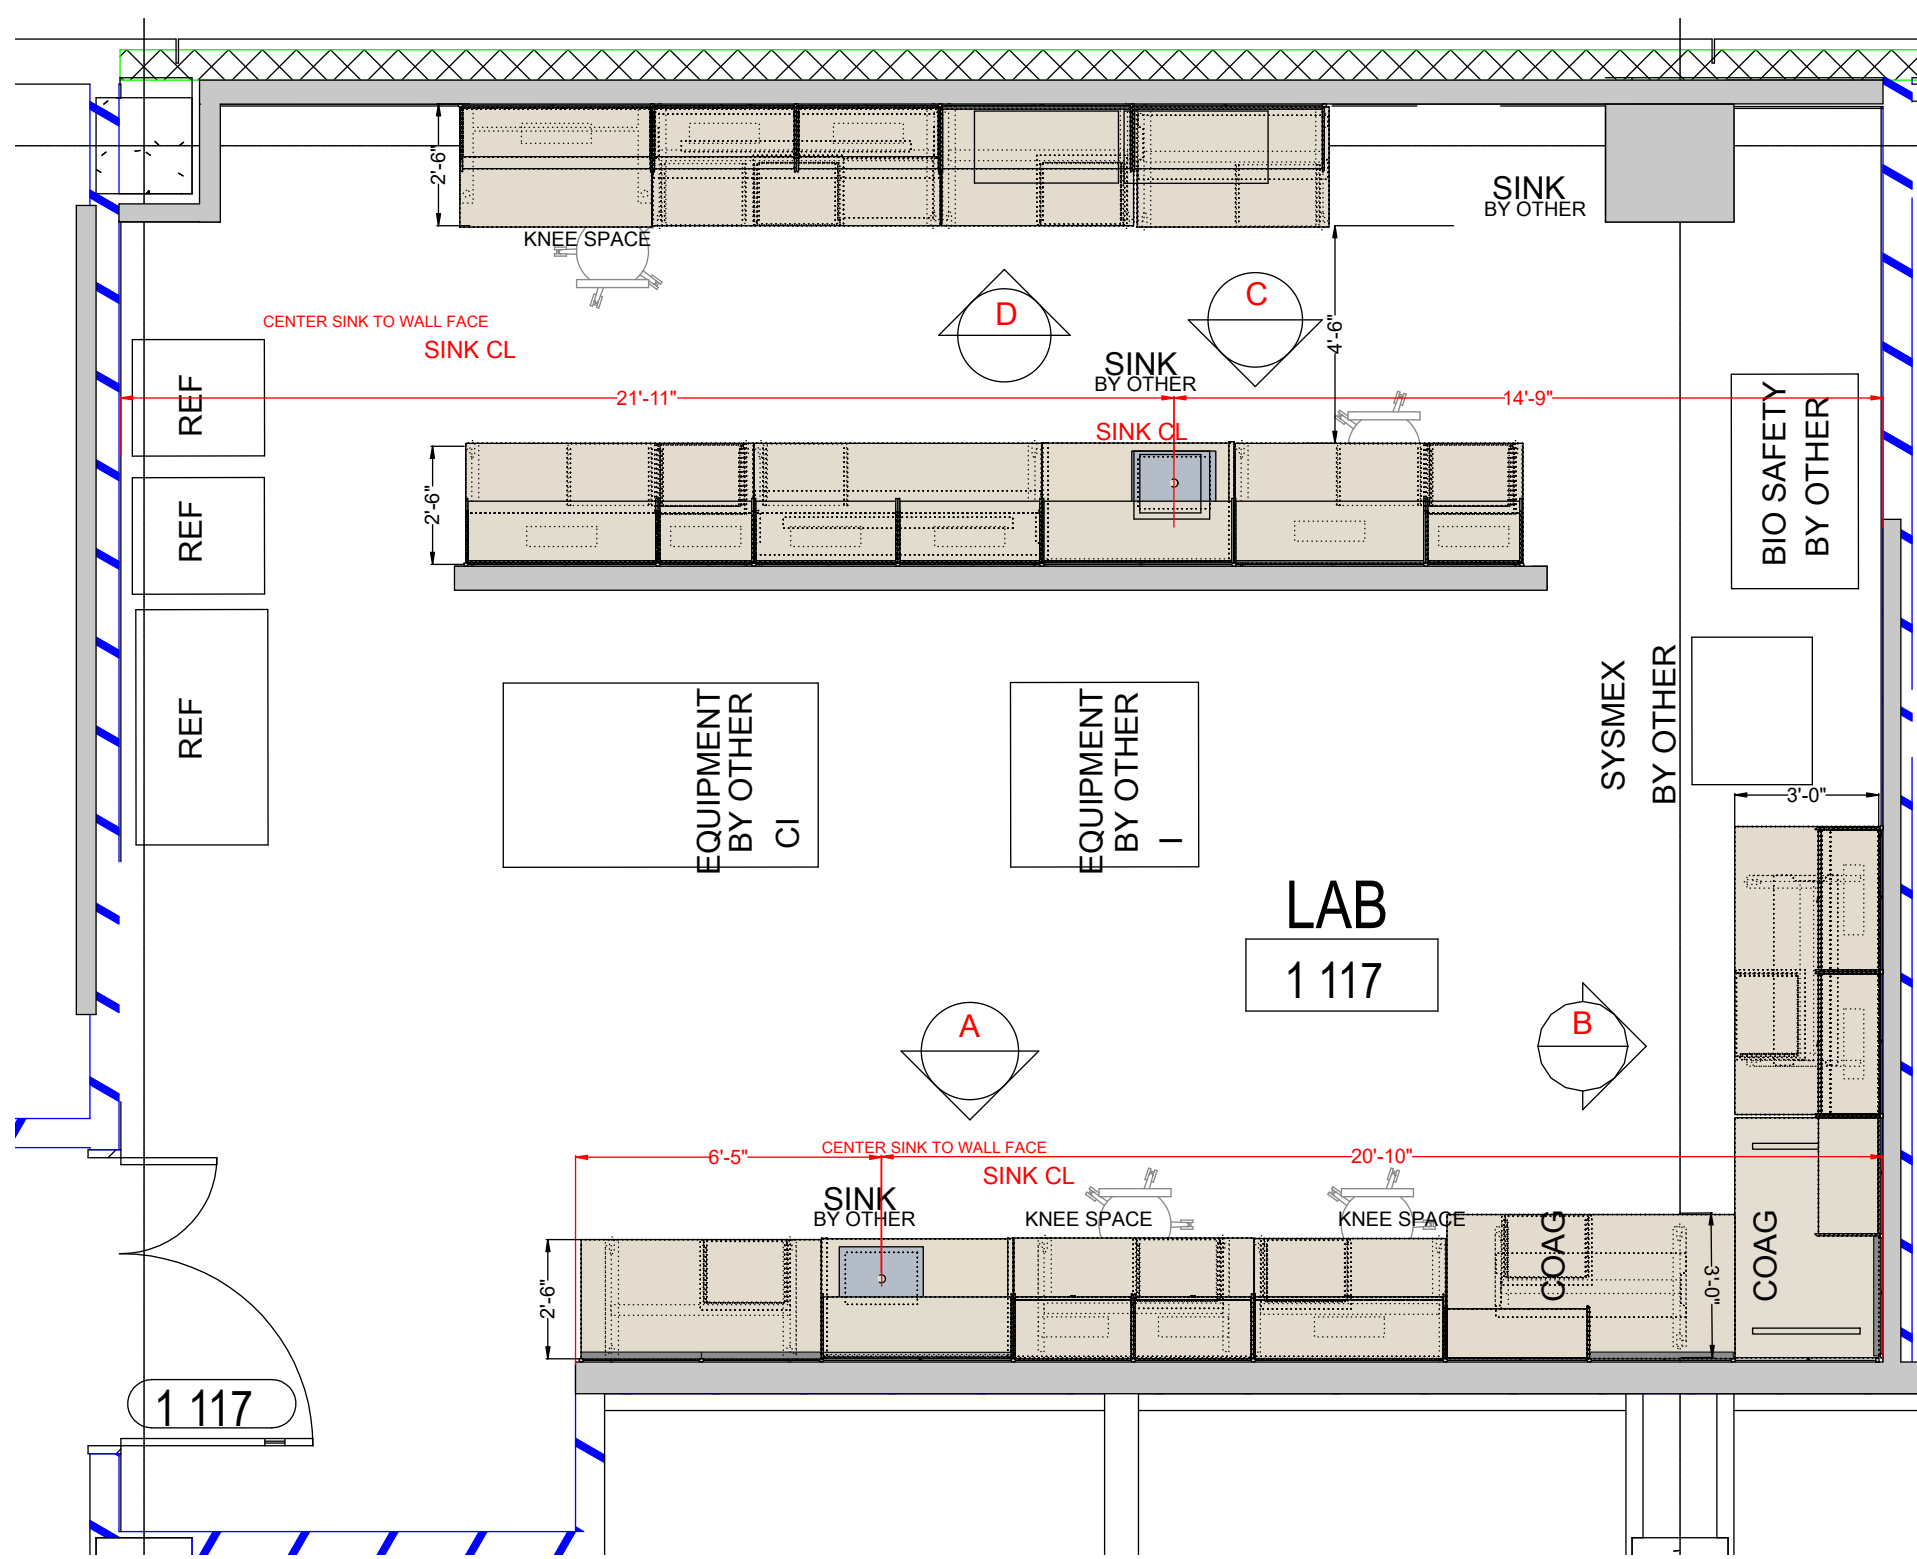

L LAB PLAN VIEW
SCALE: 1/4"=1'

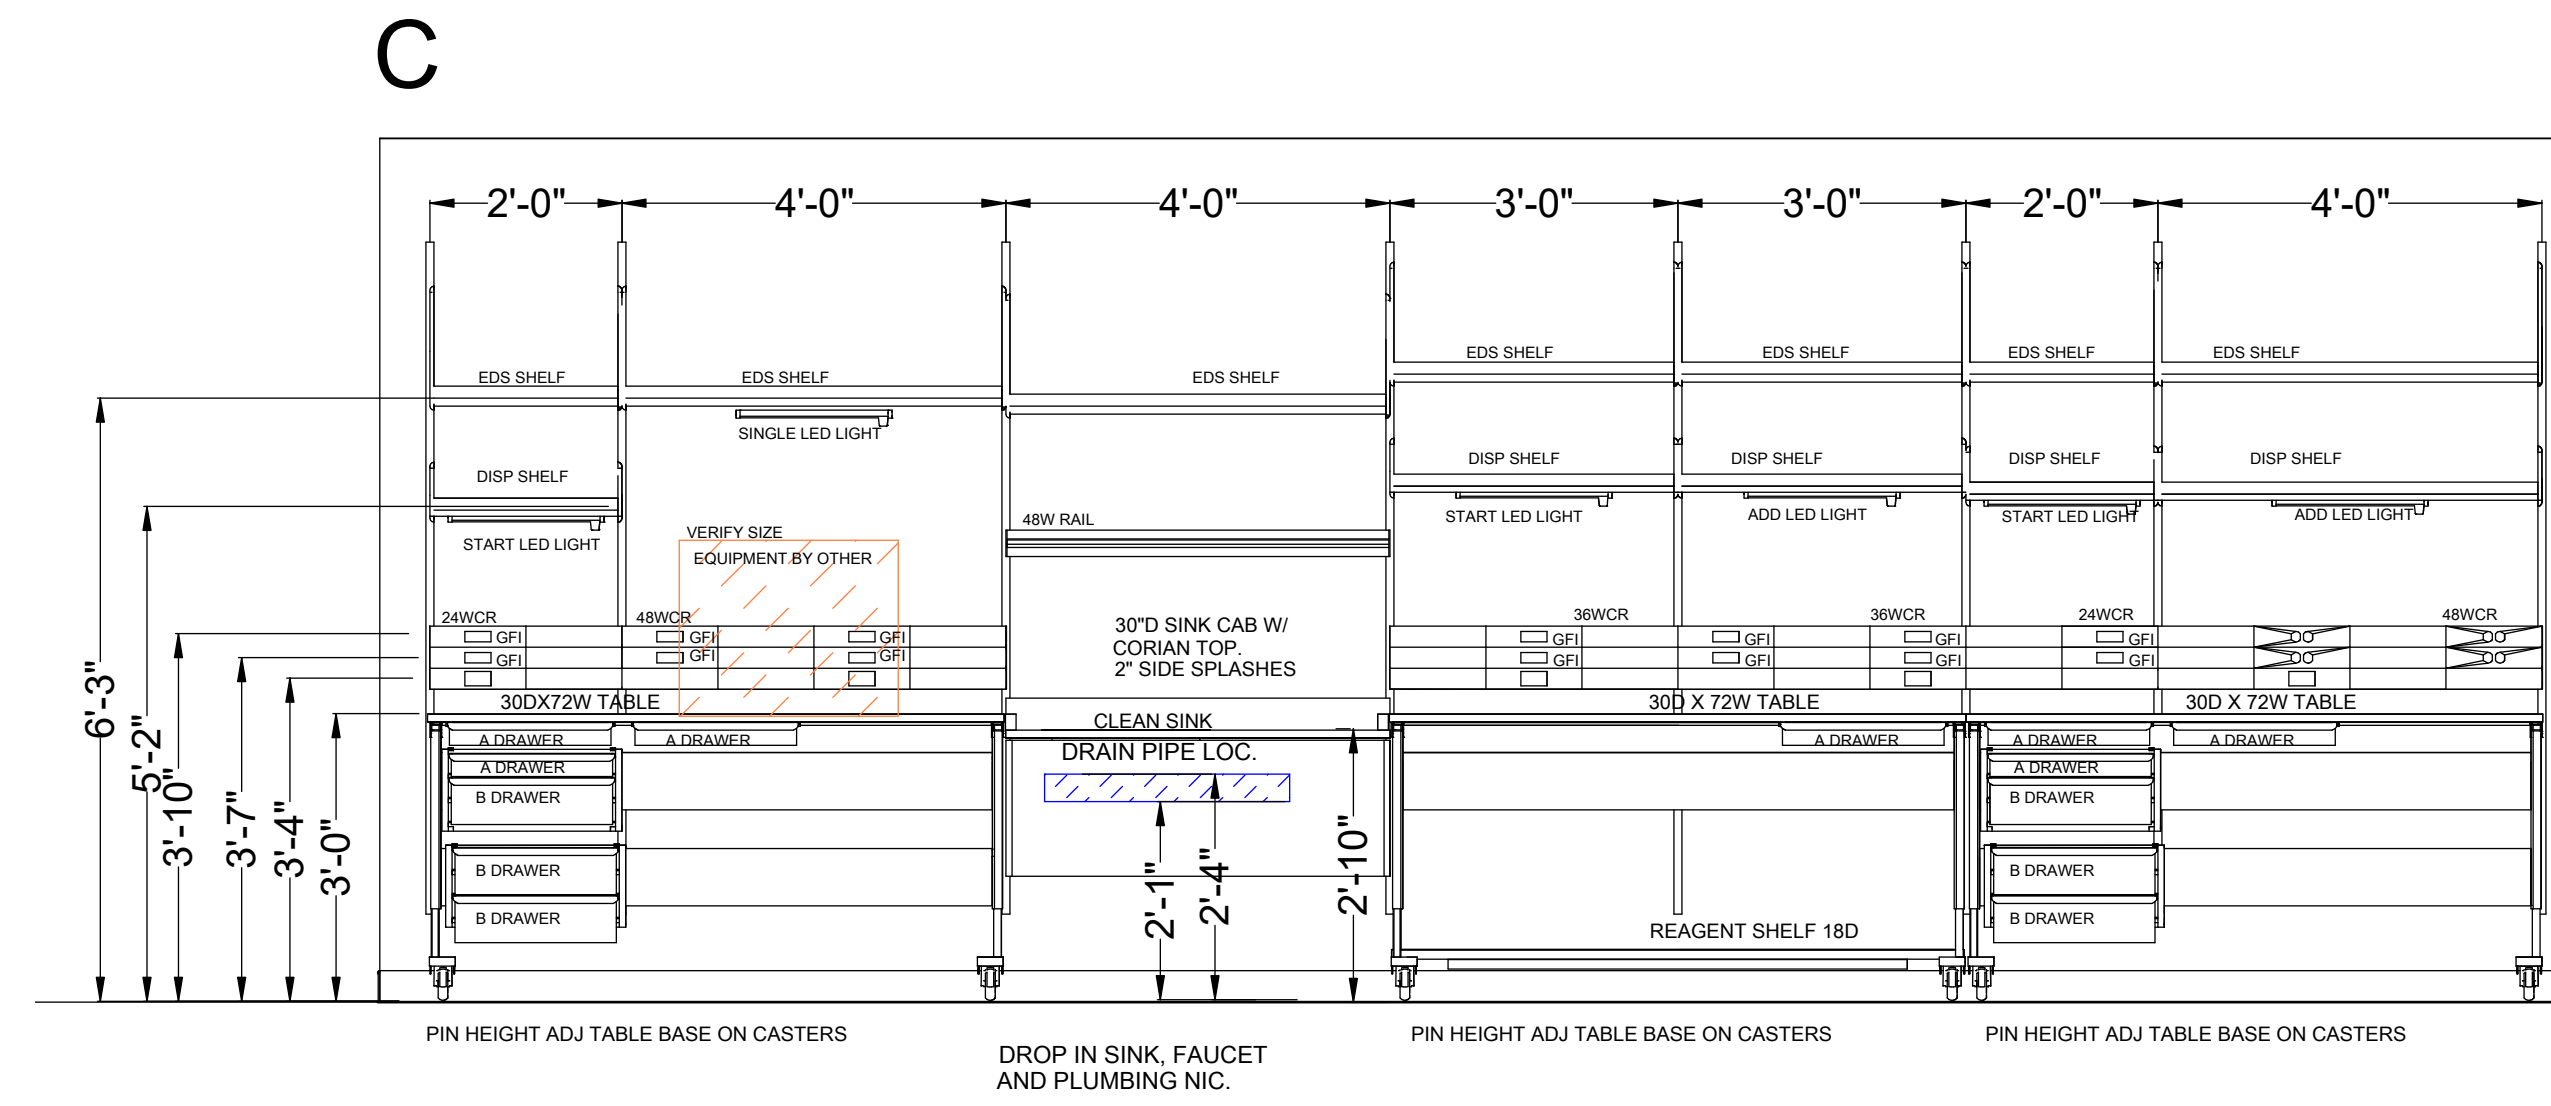

C LAB ELEVATION VIEW
SCALE: 1/2"=1'

REFERENCE THE ELECTRICAL DRAWINGS FOR ALL CIRCUITING


POWER ENTRY FROM WALL

SEE DETAILS SHEET FOR INFEEED HEIGHTS

WIRE CHASE RAIL - 3 CHANNELS

- 1. REGULAR POWER**
- 2. EMERGENCY POWER**
- 3. LOW VOLTAGE/DATA**

TOP OF WIRE CHASE RAIL - 47"H

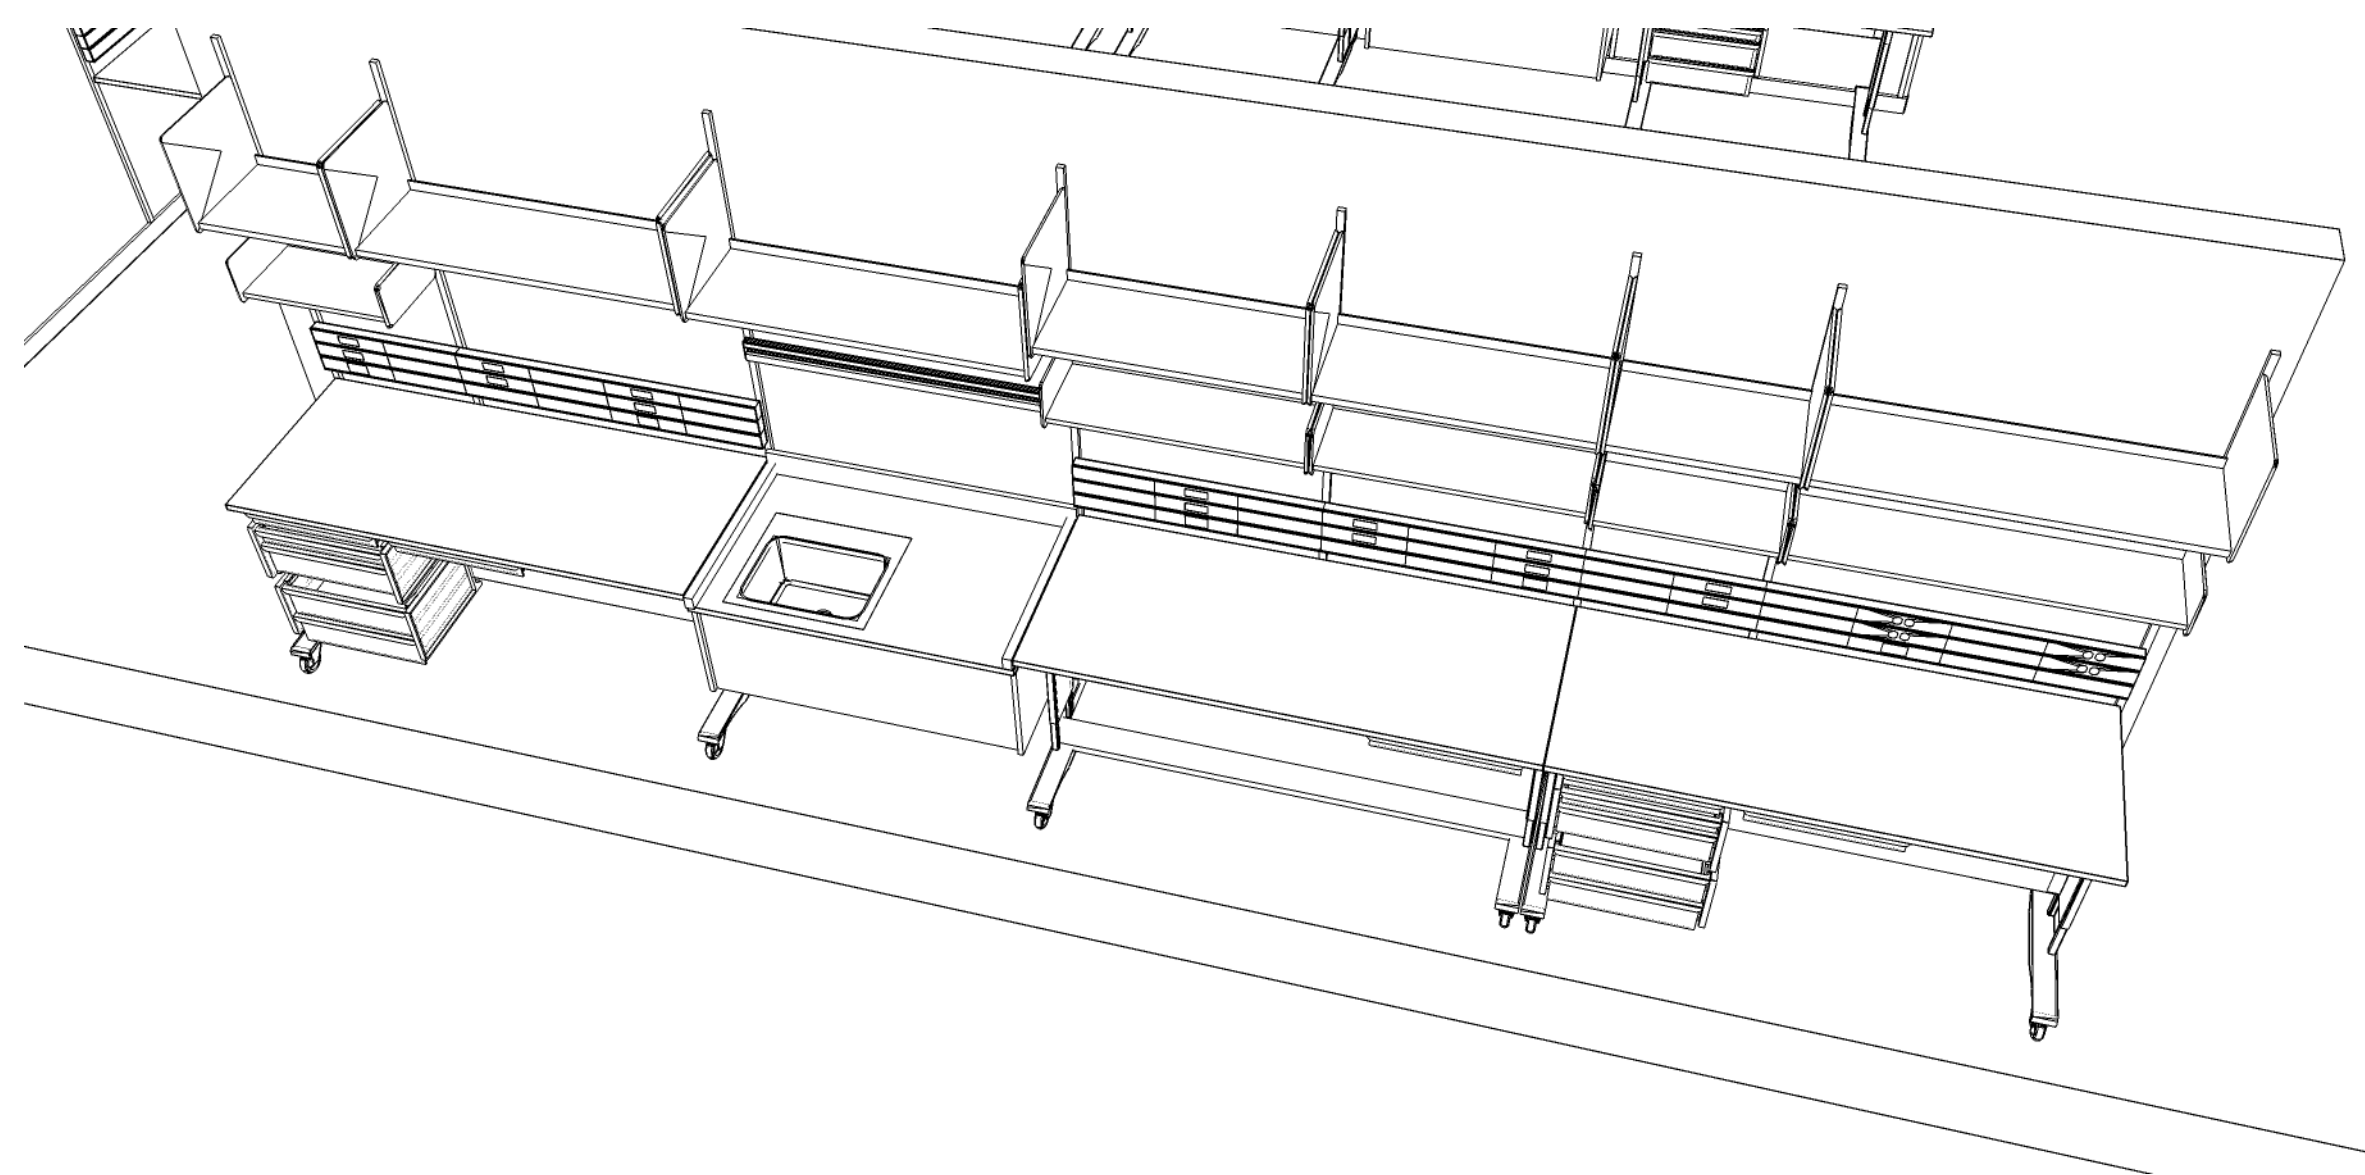

C LAB ISOMETRIC VIEW
SCALE: NTS



C LAB RENDERING
SCALE: NTS

Contractors/ Subcontractors to check and verify all dimensions on site prior to proceeding with the work.

This document and any associated materials are the sole property of Workscapes and are not for use other than to internally evaluate Workscapes' services. They are not to be disseminated, distributed, or otherwise conveyed to any third parties without the express written permission of Workscapes.


Project No.:	89853
Sheet Size:	24X36
Scale:	SEE PLAN
Designer:	K.COTTRELL
Location:	TAMPA, FL
Date:	3/2/2026
Signed:	

Revisions:


02-17-2026	R1	ADD FILLER
03-02-2026	R2	ADJ SCOPE
date		
date		
date		
date		
date		

This drawing is intended to indicate furniture location and configuration only and is not to be used permitting or construction.


For exact architectural configurations, refer to architectural contract documents prepared by others.

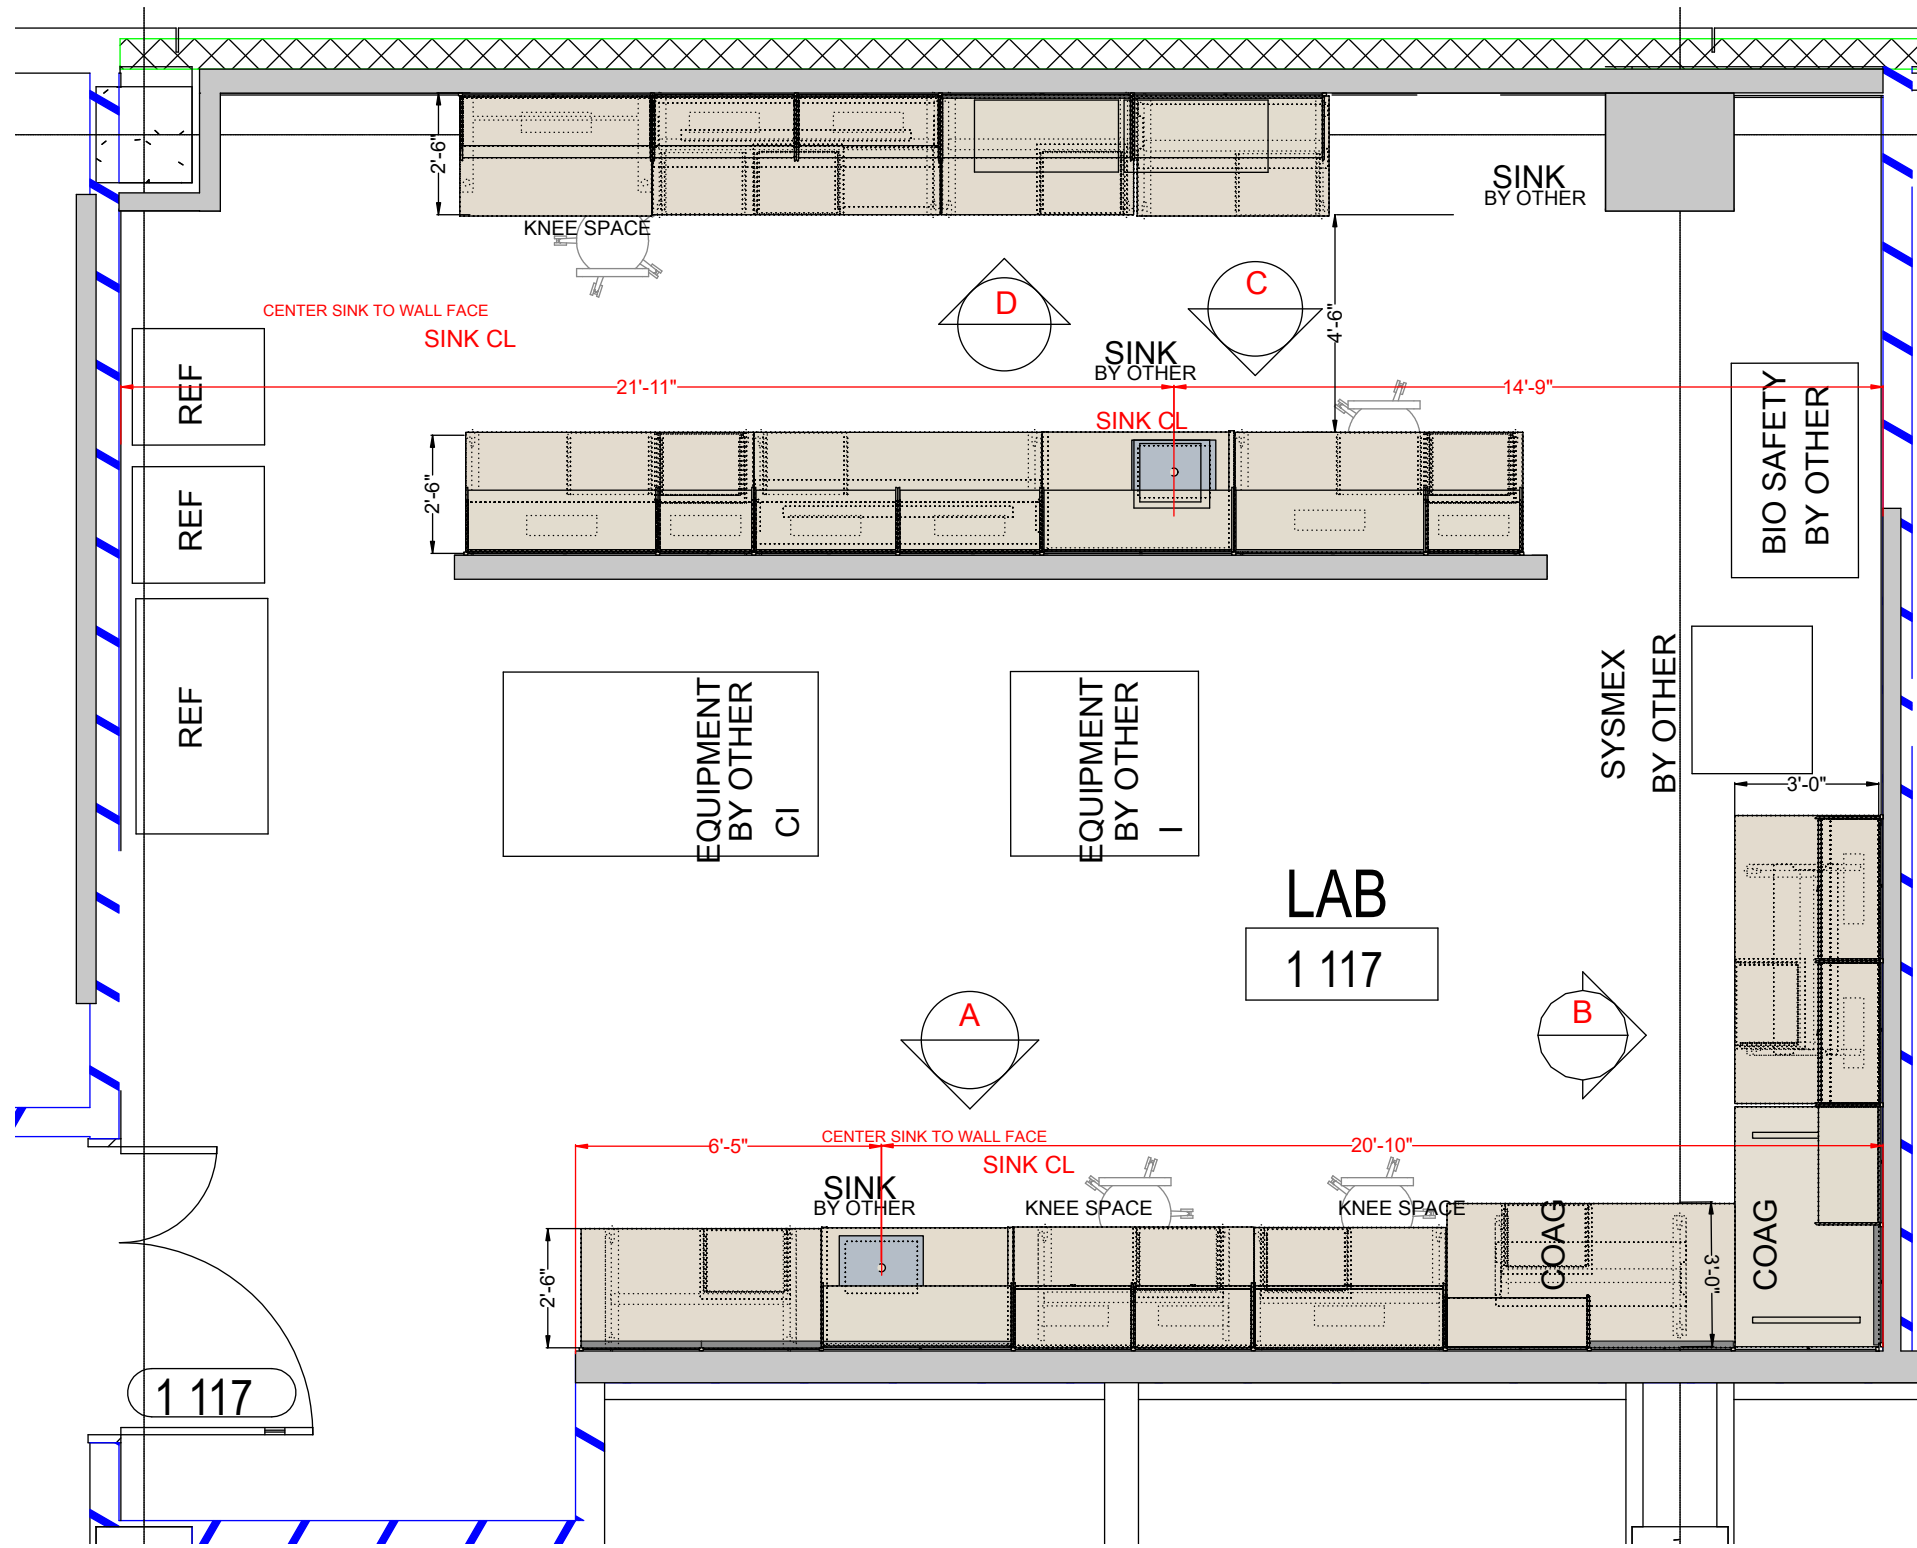


L LAB PLAN VIEW
SCALE: 1/4"=1"

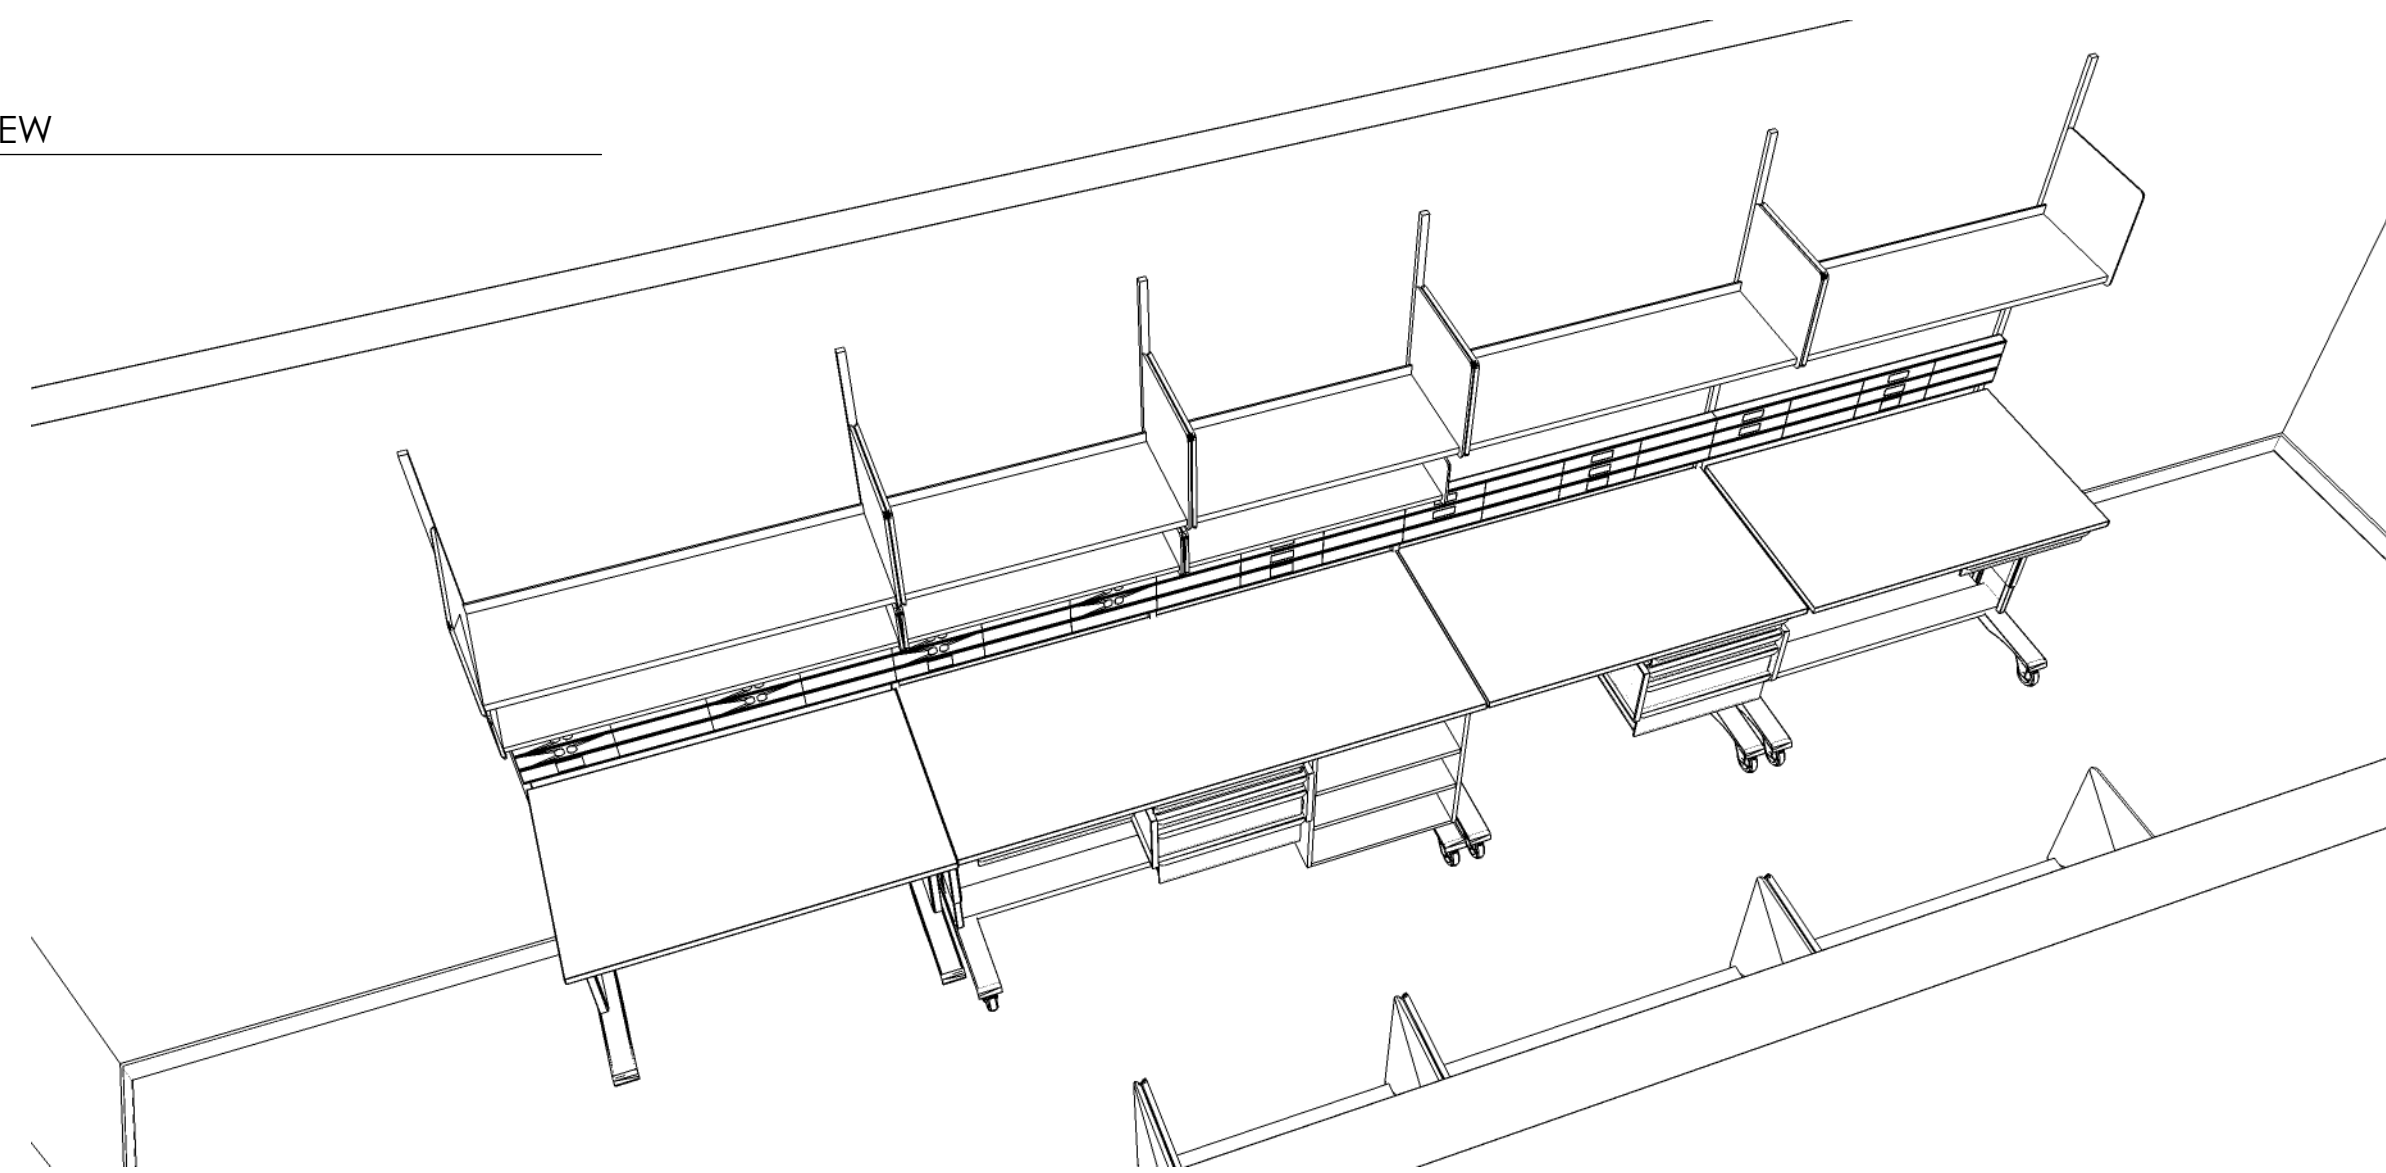


D LAB ISOMETRIC VIEW
SCALE: NTS

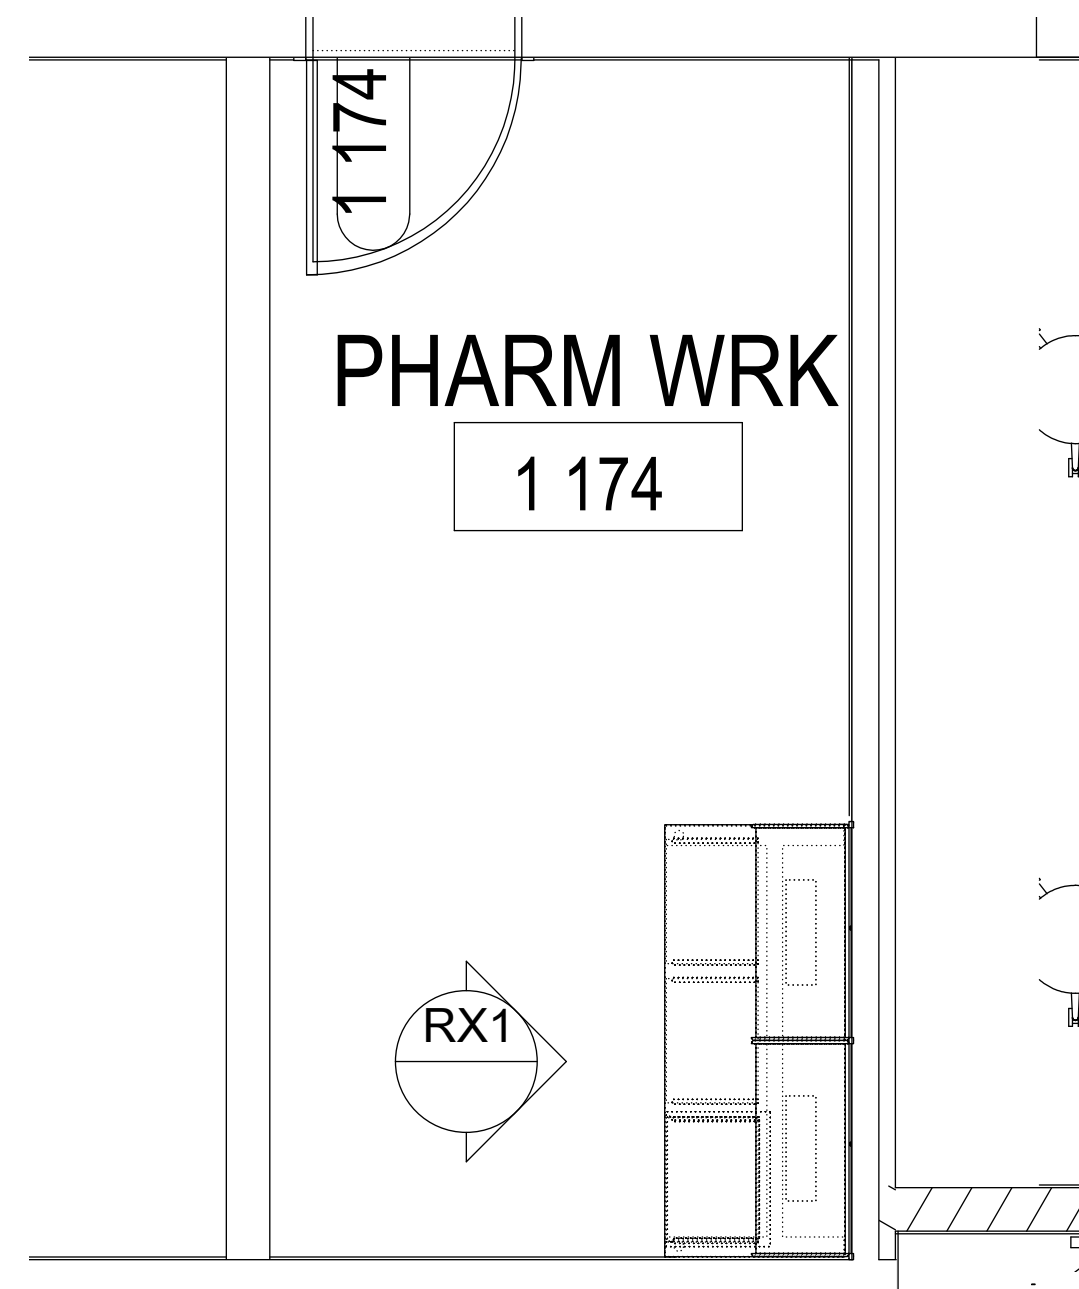


RX PHARMACY PLAN VIEW
SCALE: 3/8"=1"

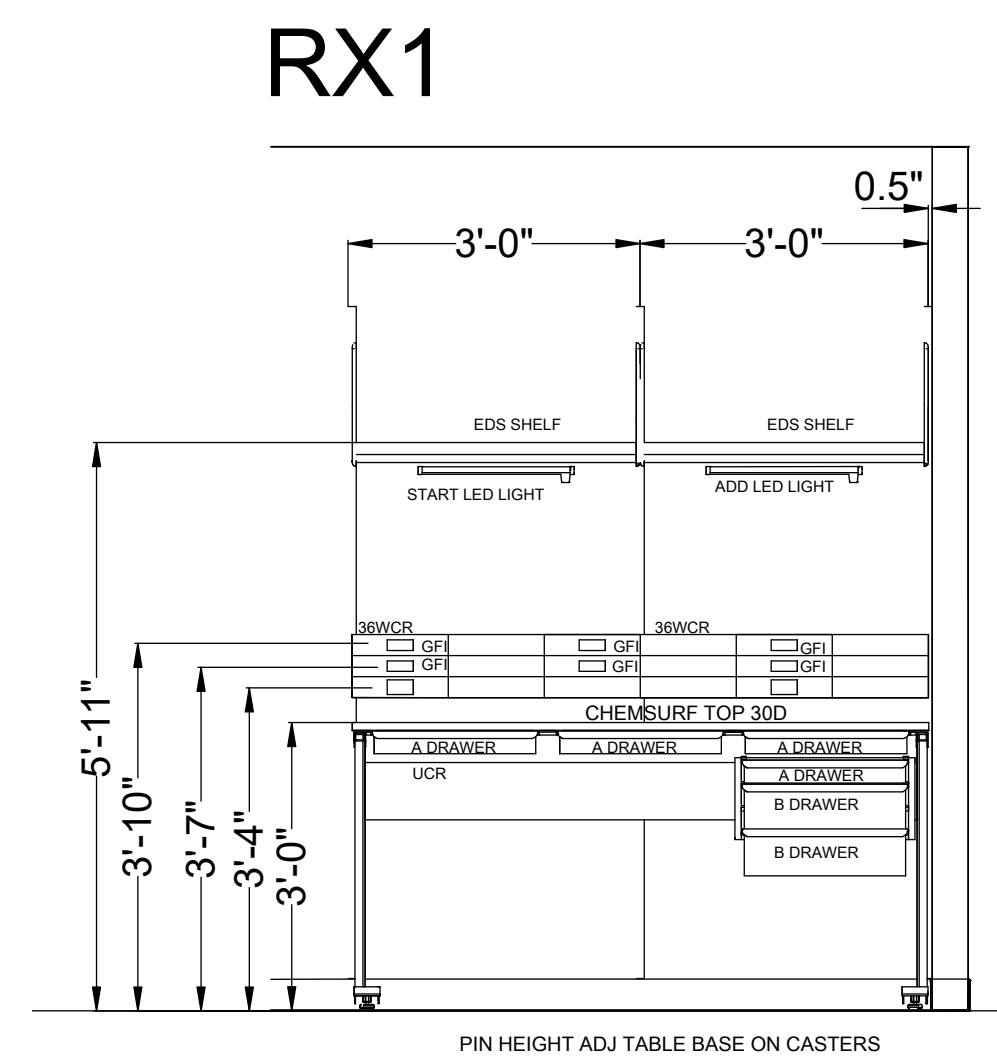

RX PHARMACY ELEVATION VIEW
SCALE: 1/2"=1"

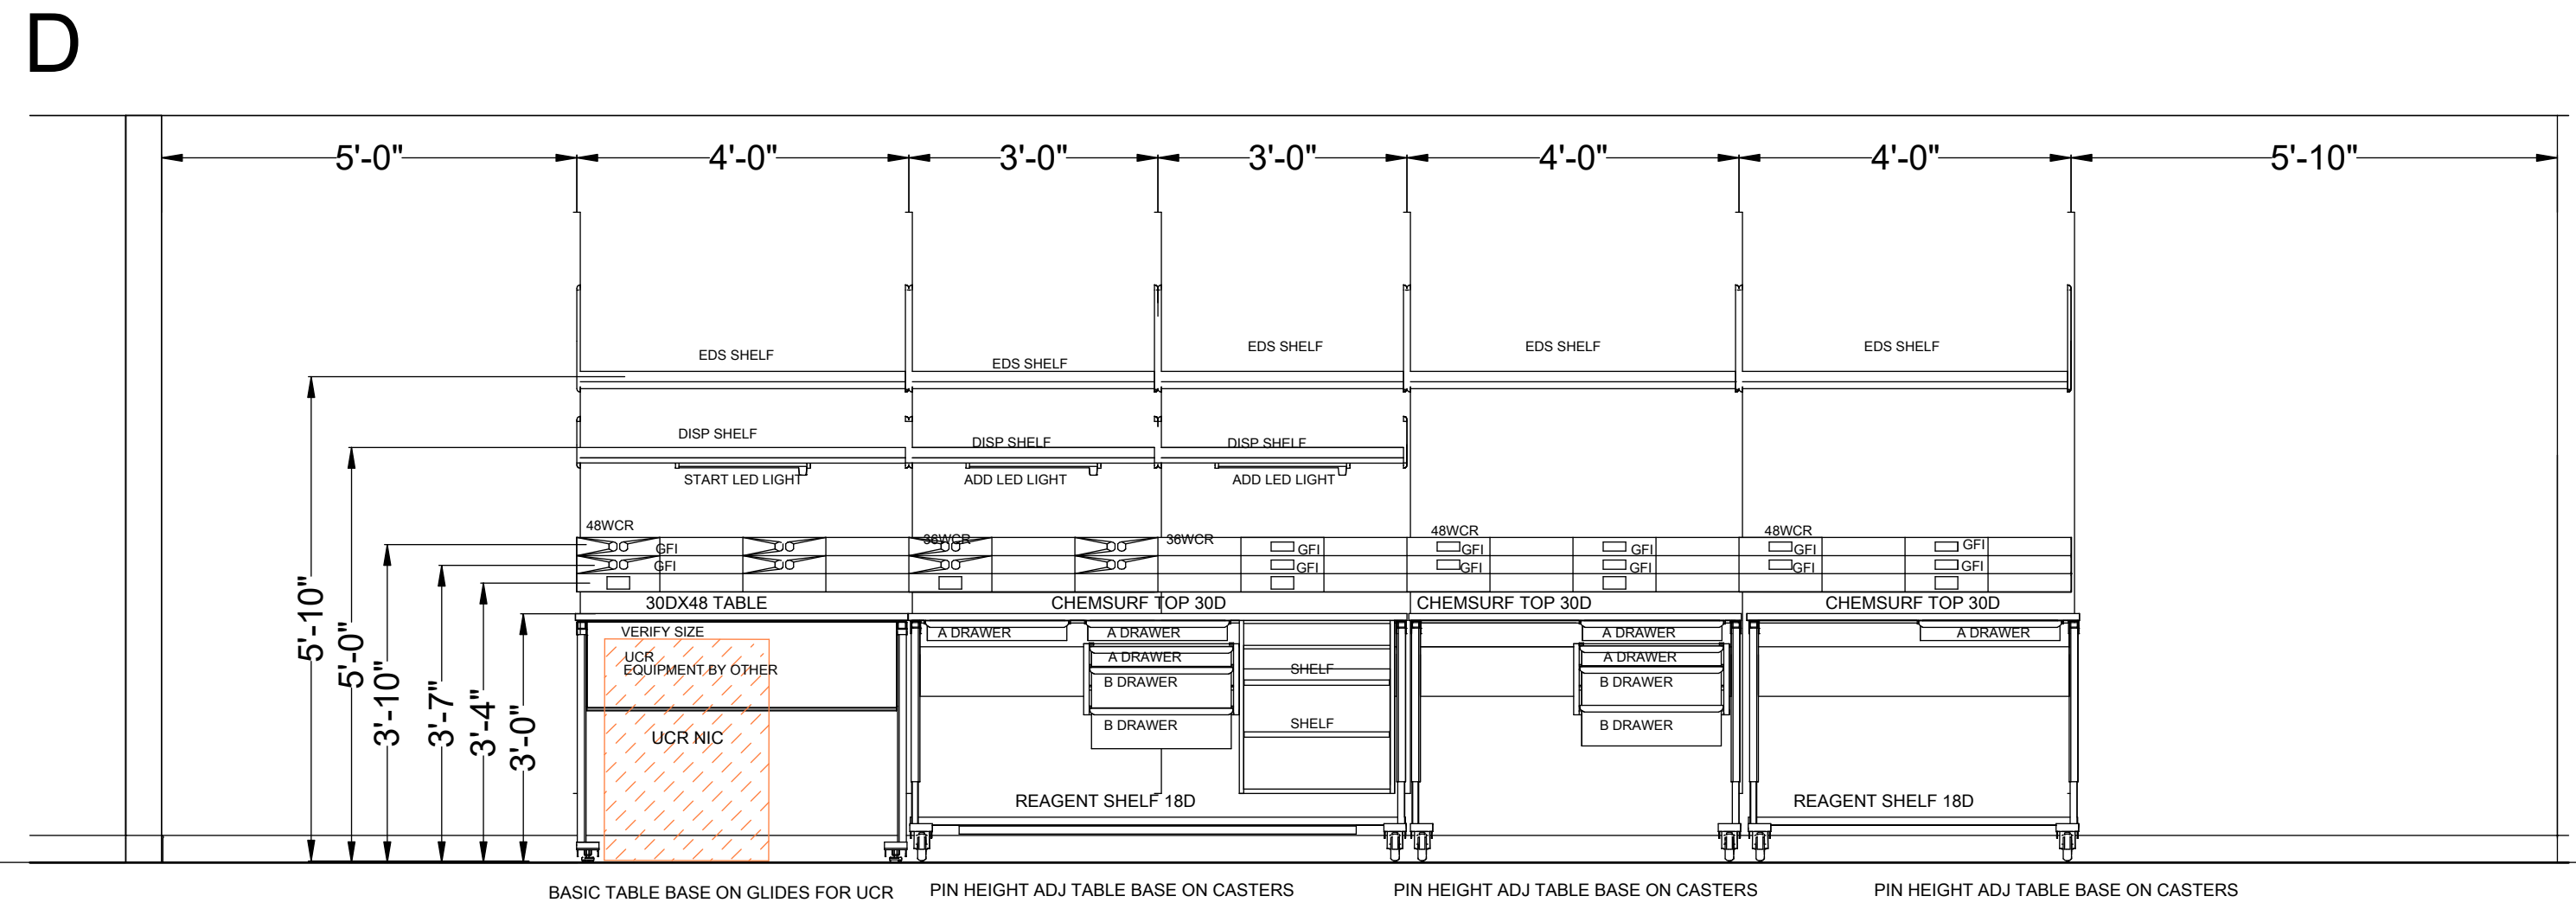

D LAB ELEVATION VIEW
SCALE: 1/2"=1"

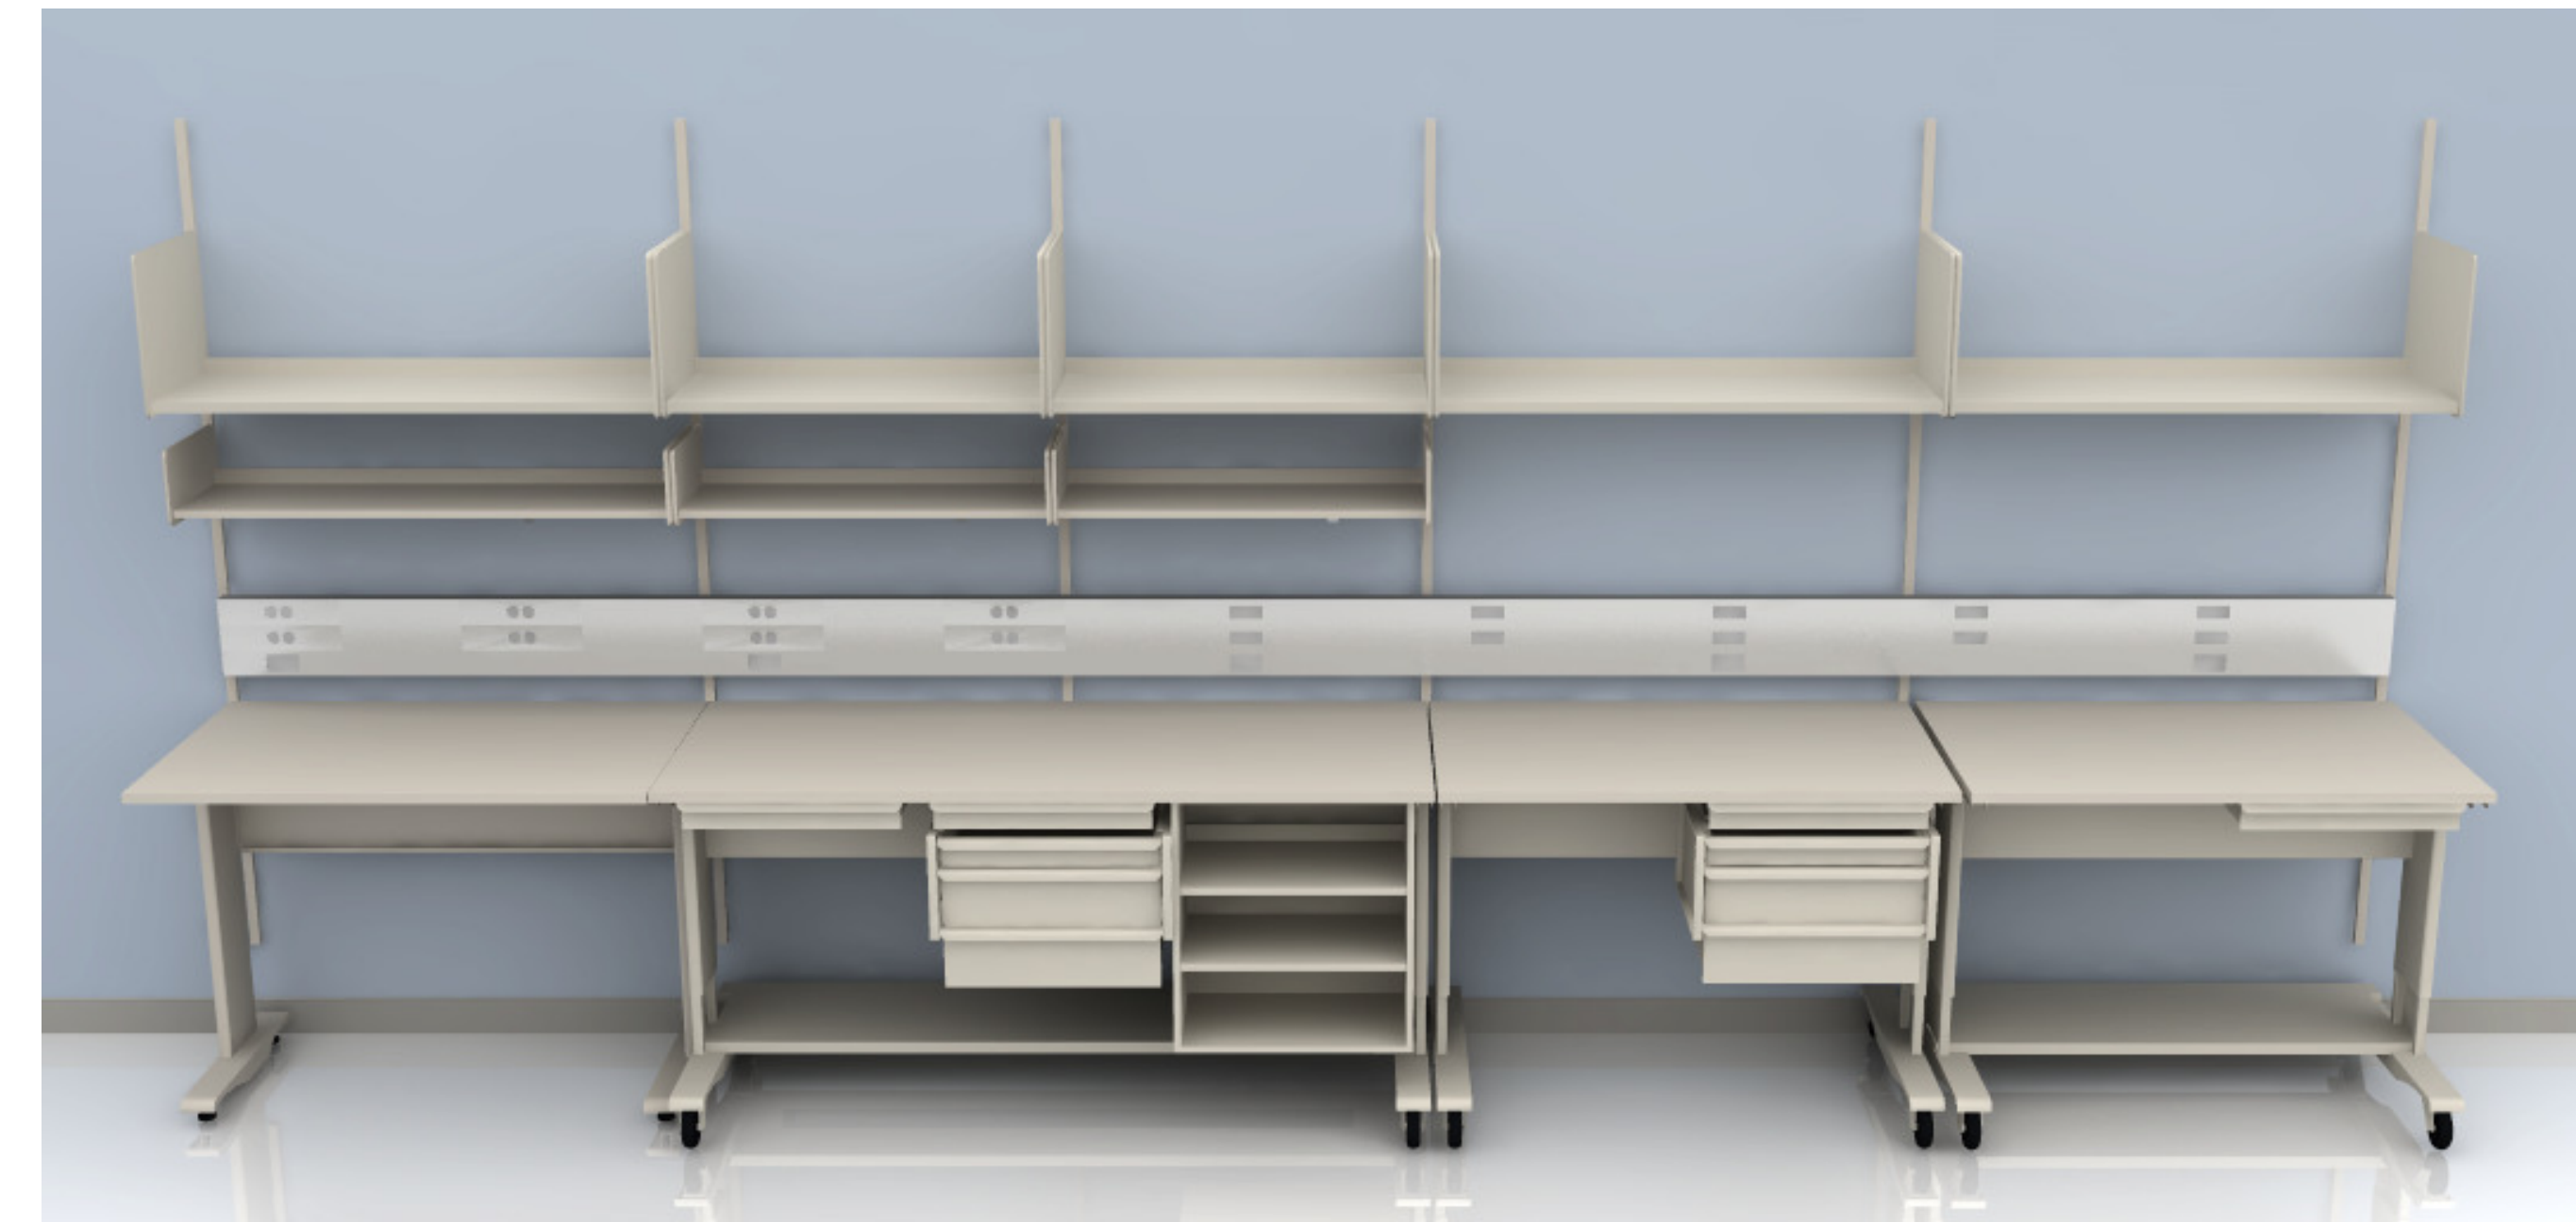

D LAB RENDERING
SCALE: NTS



RX PHARMACY ISOMETRIC VIEW
SCALE: NTS



RX PHARMACY RENDERING
SCALE: NTS

REFERENCE THE ELECTRICAL DRAWINGS FOR ALL CIRCUITING

POWER ENTRY FROM WALL

SEE DETAILS SHEET FOR INFED HEIGHTS

WIRE CHASE RAIL - 3 CHANNELS

- 1. REGULAR POWER**
- 2. EMERGENCY POWER**
- 3. LOW VOLTAGE/DATA**

TOP OF WIRE CHASE RAIL - 47" H



worksapcs Tampa
501 E Kennedy Blvd
Suite 100
Tampa, FL 33602
813.620.0048
IC # 80001503

Facility Name: Orlando Health Melbourne Hospital
Project Name: Freestanding ER - Viera
OPC Project #: 23/23960034-19987

Melbourne Viera FSED
ORLANDO HEALTH EXAM CASEWORK AND LAB
Lake Andrew Dr & Willif Place, Melbourne, FL 32940

Contractors/ Subcontractors to check and verify all dimensions on site prior to proceeding with the work.

This document and any associated materials are the sole property of Worksapcs and are not for use other than to internally evaluate Worksapcs' services. They are not to be disseminated, distributed, or otherwise conveyed to any third parties without the express written permission of Worksapcs.

Project No.: 89853
Sheet Size: 24X36
Scale: SEE PLAN
Designer: K.COTTRELL
Location: TAMPA, FL
Date: 3/2/2026
Signed:

Revisions:


02-17-2026_R1	ADD FILLER
03-02-2026_R2	ADJ SCOPE
date
date
date
date
date

This drawing is intended to indicate furniture location and configuration only and is not to be used permitting or construction.


For exact architectural configurations, refer to architectural contract documents prepared by others.

Sheet:

CO STRUC LAB DETAILS

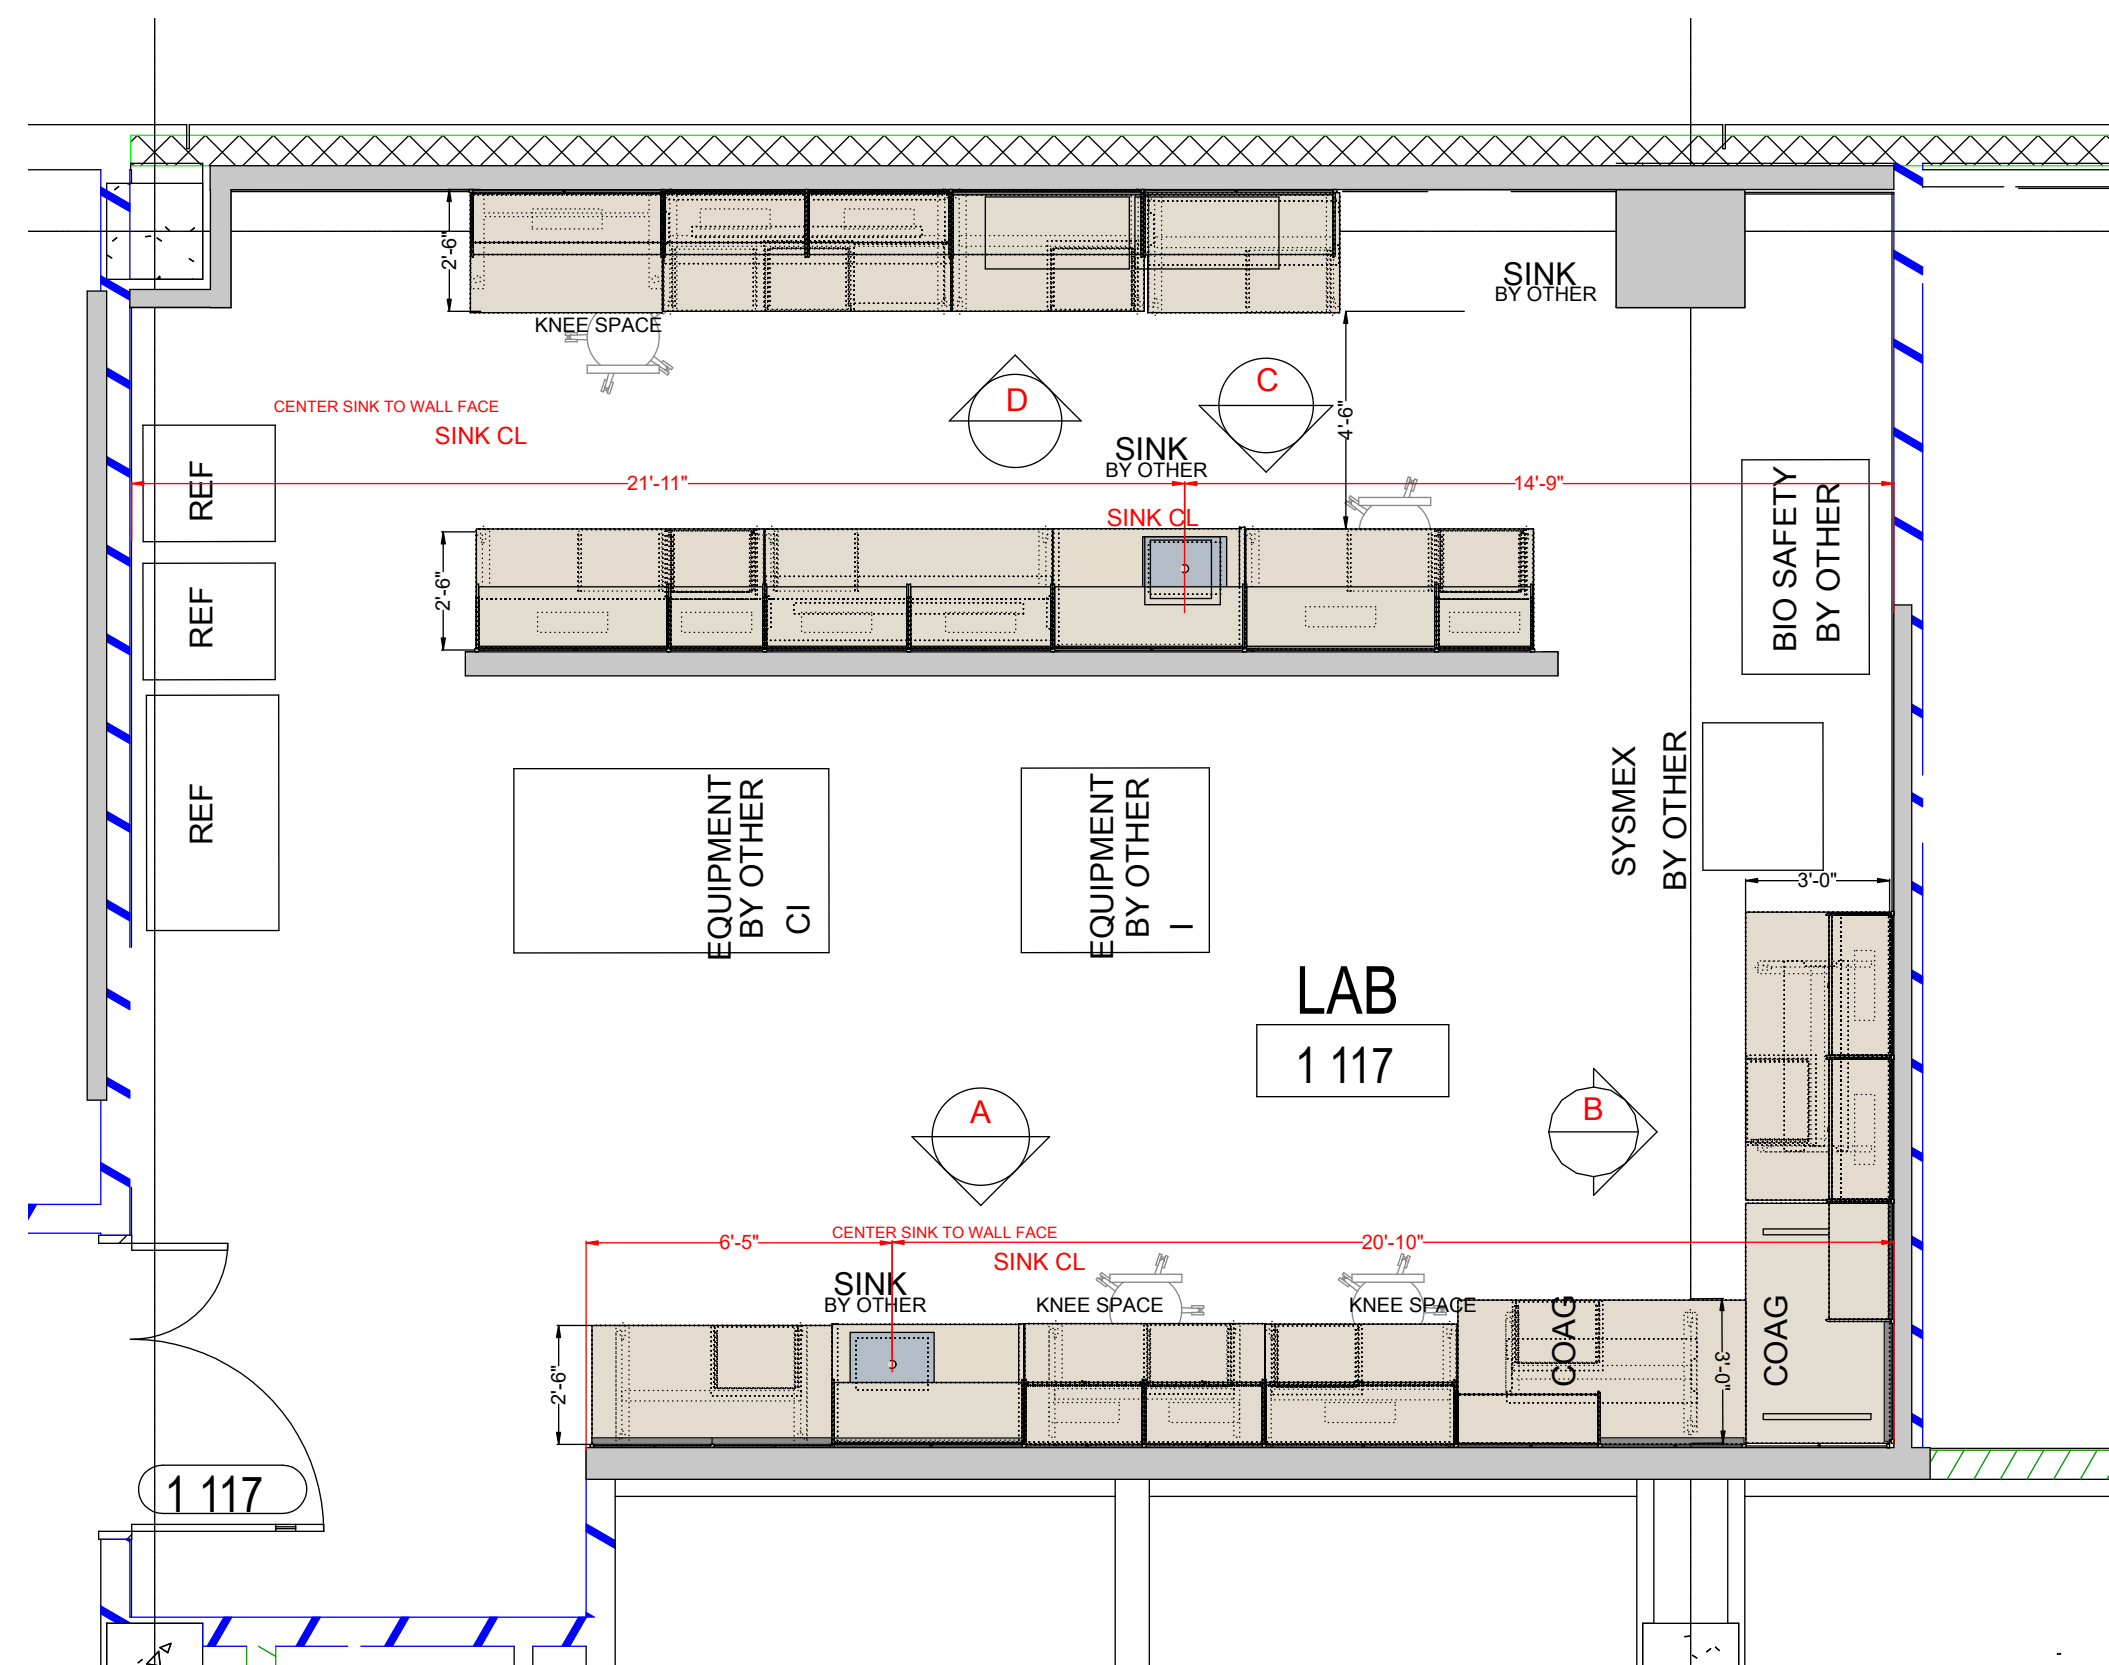

A LAB 1041 PLAN VIEW
SCALE: 3/8"=1'

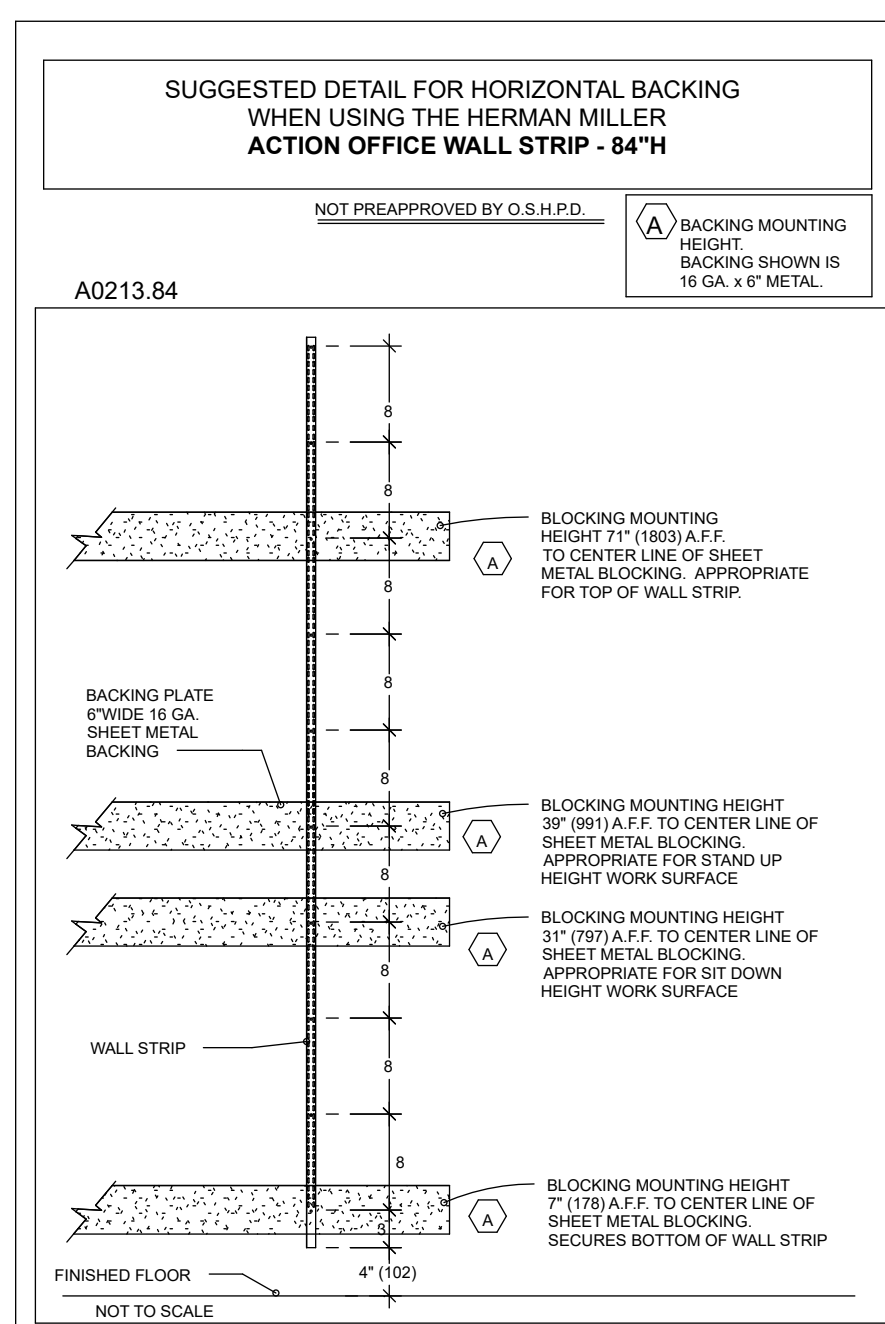

HORIZONTAL BACKING - ACTION OFFICE
WALL STRIP 84\"/>

GENERAL NOTES

HERMAN MILLER HEALTHCARE (HMHC)

- LAYOUT SUBJECT TO VERIFICATION OF FIELD DIMENSIONS AND CONDITIONS.
- ALL WALLS THAT ARE TO RECEIVE WALL HANGER STRIPS OR CO/STRUC RAIL MUST BE CONSTRUCTED WITH A MINIMUM 25 GA. METAL STUDS AT 16\"/>

GENERAL NOTES


3/4" = 1'-0"

CO/STRUC NOTES


- WIRE CHASE RAIL IS A MODULAR ELECTRICAL AND LOW-VOLTAGE, UL LISTED, CHASE SYSTEM INCLUDING RECEPTACLE COVERS SUPPLIED AND INSTALLED BY HERMAN MILLER HEALTHCARE (HMHC).
- HMHC WIRE CHASE RAIL IS COMPATIBLE WITH WIREMOLD AL4320 & AL3000 COMPONENTS. AVAILABLE IN EITHER A DOUBLE (C1313) OR SINGLE (C1314) VERSION. CHASE AND COVERS ARE ALUMINUM WITH A CLEAR ANODIZED (AH) FINISH.
- THE DOUBLE WIRE CHASE VERSION (C1313) CAN BE INSTALLED ALONE, OR THE SINGLE VERSION (C1314) CAN STACK BENEATH THE DOUBLE, PROVIDING 3 SEPARATE CHASES. THIS ISOLATING POWER, EMERGENCY POWER, AND LOW-VOLTAGE TELEPHONE / DATA LINES.
- TO PROVIDE CABLE ACCESS INTO THE WIRE CHASE RAILS, INSTALLERS MUST DRILL THE 1 3/8\"/>

CO/STRUC NOTES

3/4" = 1'-0"

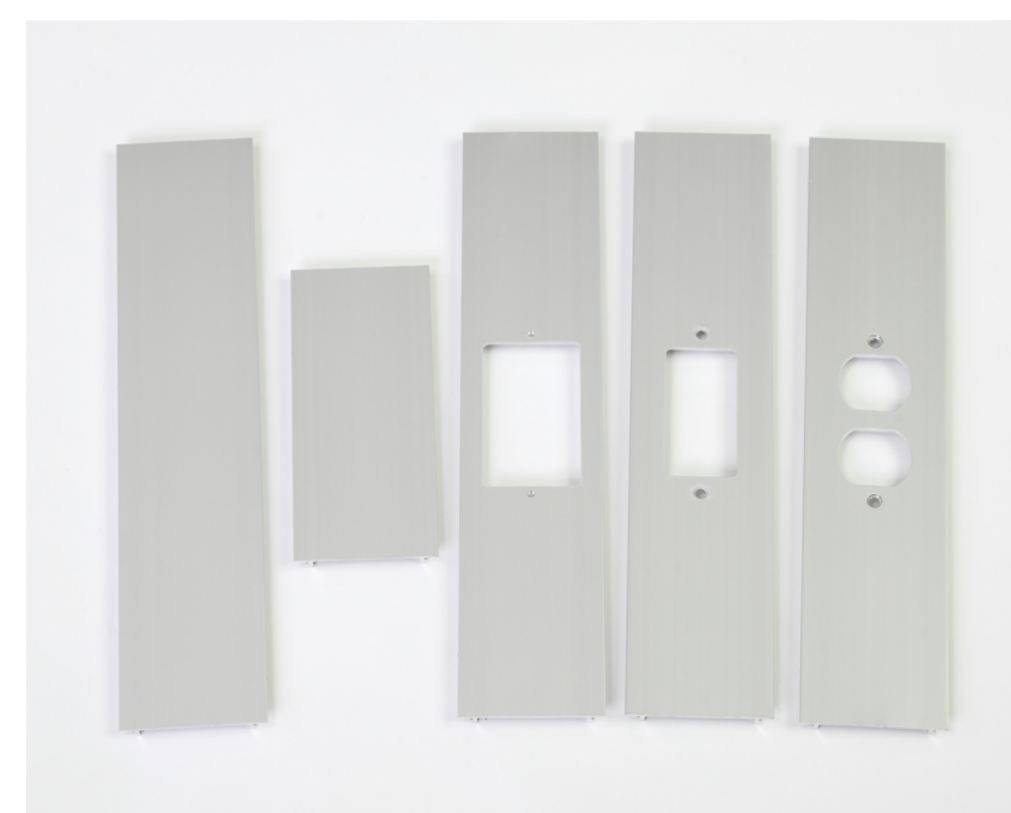

WCR COVERS

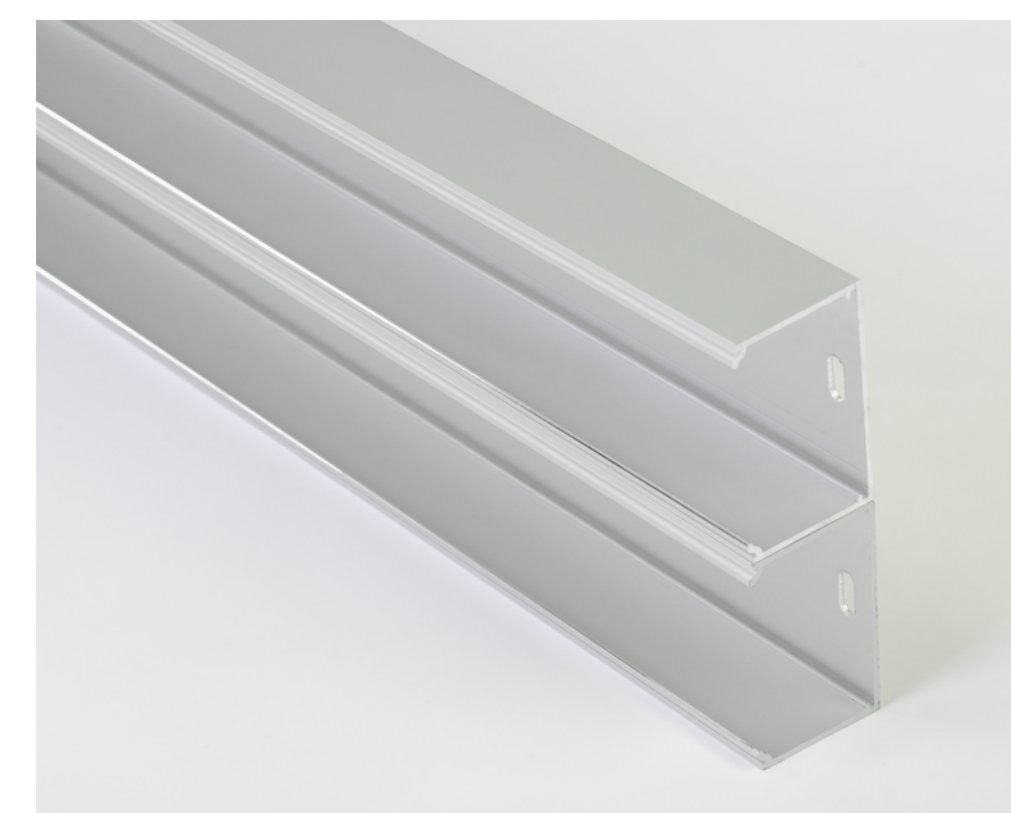


WIRE CHASE

Laboratory- Co-Struc Electrical



Co/Struc Electrical Installation

Wire Chase Rail


Routing Cabling and Mounting Faceplates

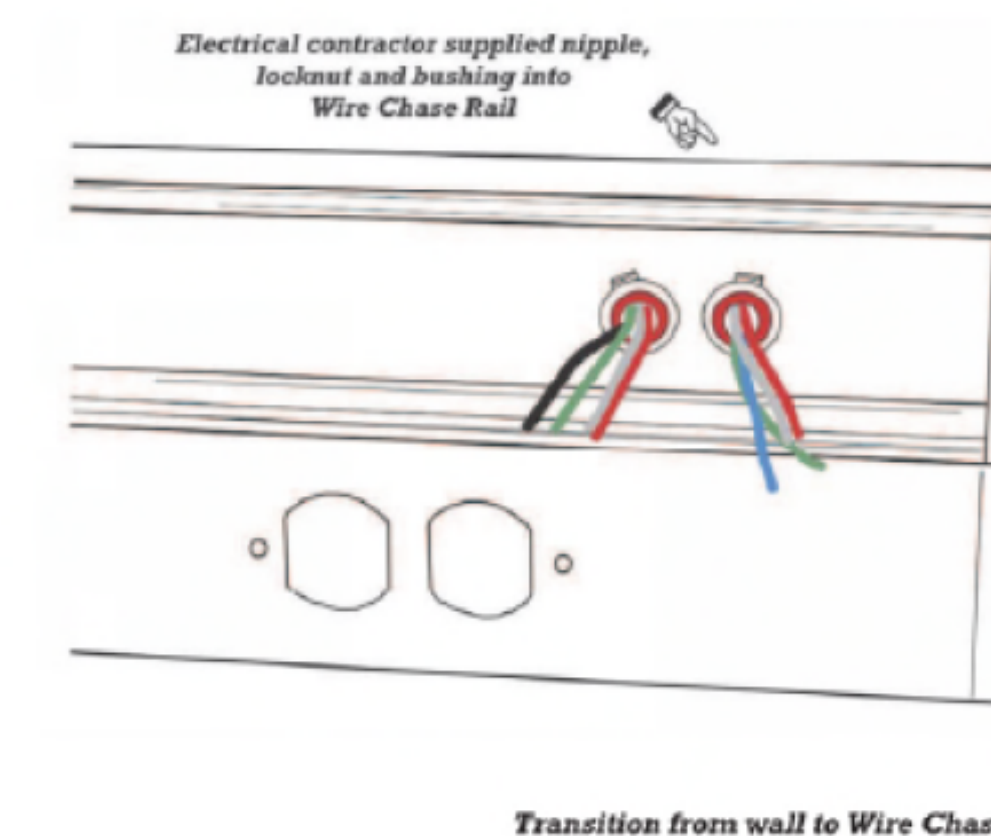


See the detail pages in the back of our drawing package for more information

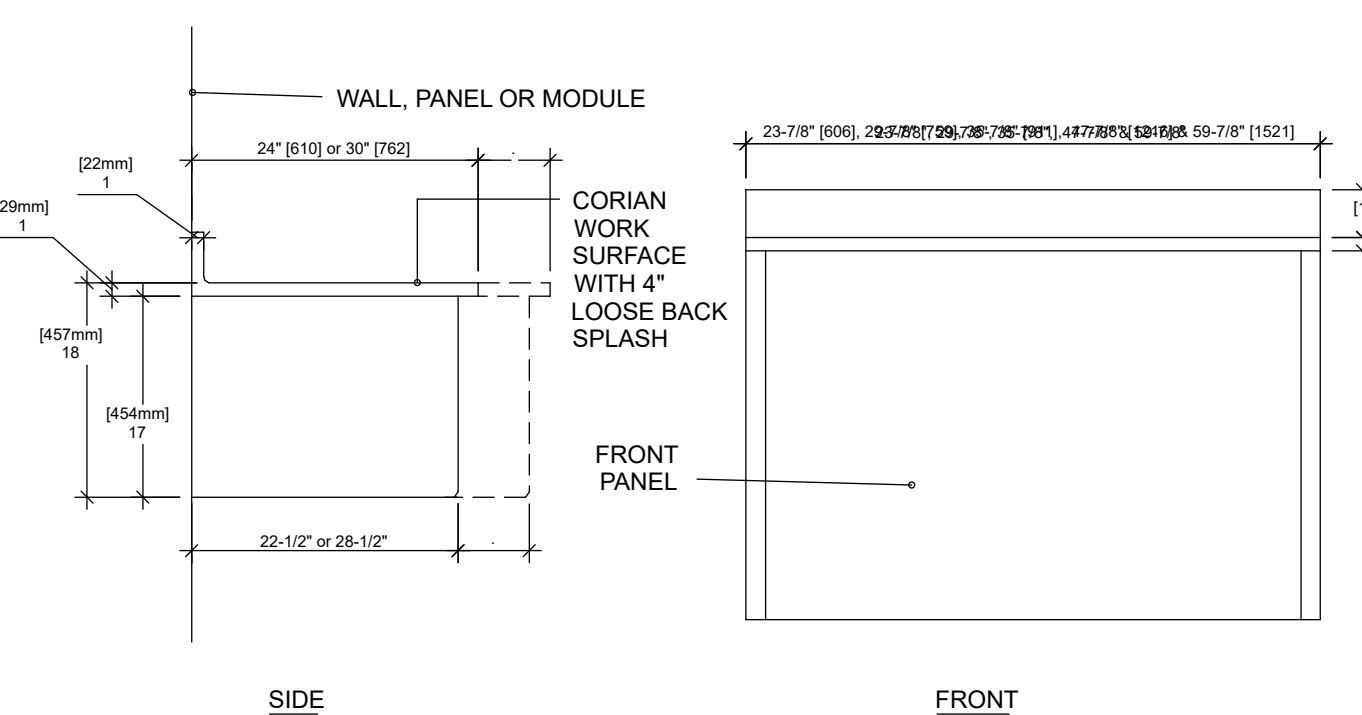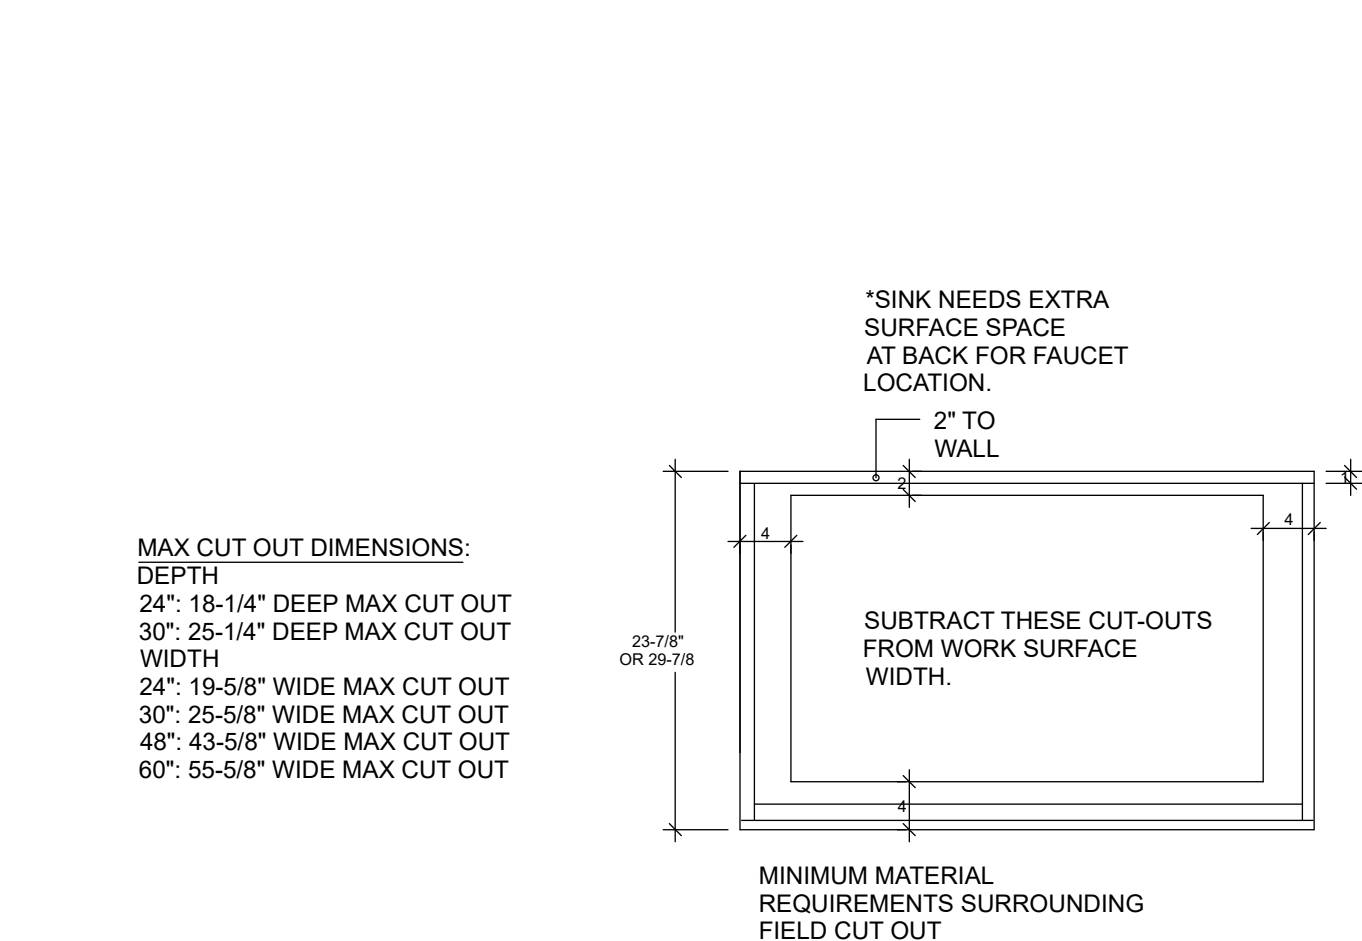

CO/STRUC SINK MODULE
3/4" = 1'-0"

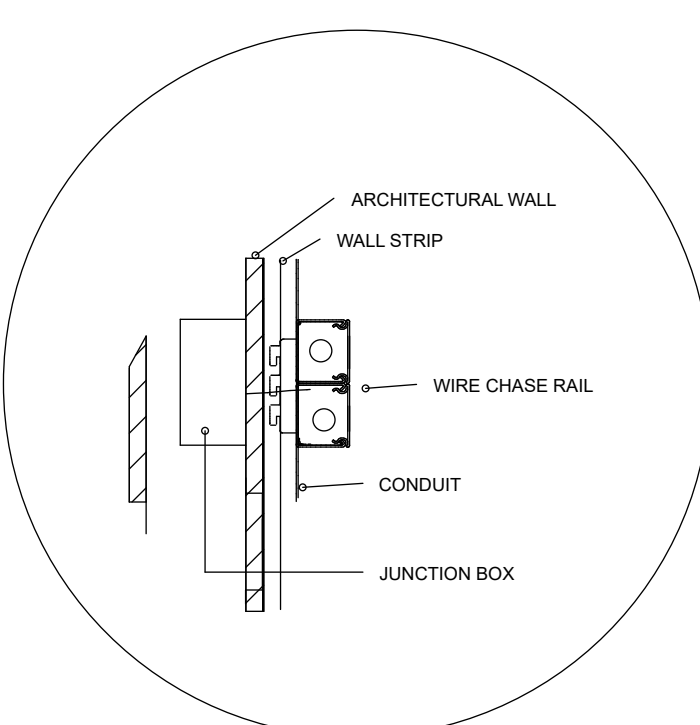

WIRE CHASE WALL ENTRY (WALL STRIP MOUNT)
1/4" = 1'-0"

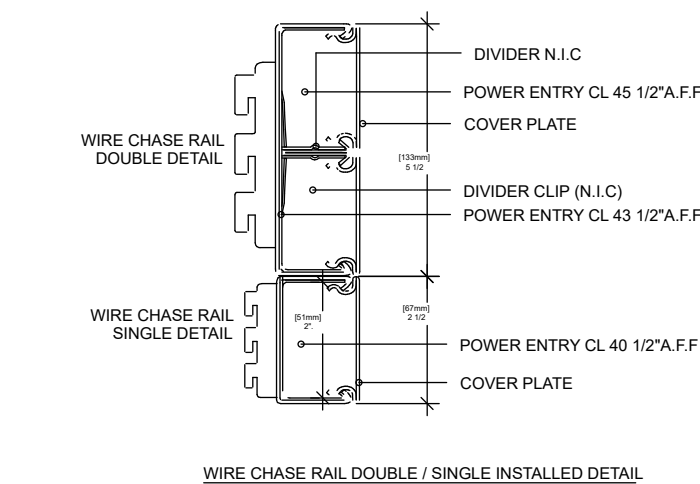

WIRE CHASE 3 TO 1 SCALE
3" = 1'-0"

WIRE CHASE DOUBLE/SINGLE RAIL - DRYWALL
3/4" = 1'-0"

Contractors/ Subcontractors to check and verify all dimensions on site prior to proceeding with the work.

This document and any associated materials are the sole property of Workscapes and are not for use other than to internally evaluate Workscapes' services. They are not to be disseminated, distributed, or otherwise conveyed to any third parties without the express written permission of Workscapes.

Project No.: 89853

Sheet Size: 24X36

Scale: SEE PLAN

Designer: K.COTTRELL

Location: TAMPA, FL

Date: 3/2/2026

Signed:

Revisions:

02-17-2026	R1	ADD FILLER
03-02-2026	R2	ADJ SCOPE
date		
date		
date		
date		
date		
date		

This drawing is intended to indicate furniture location and configuration only and is not to be used permitting or construction.

For exact architectural configurations, refer to architectural contract documents prepared by others.

Sheet: